

Drainage Plan

690 Tule Creek Road
Hayfork, CA

DESIGNER:
SCOTT WATKINS
BUILDABERG
575 Main Street
Weaverville
CA 96093
scott@buildaberg.com
cell: 530-953-5763


TENANT:
APN 014-430-75

DATE: 01/20/20

DRAWN: Patrick Flynn

SCALE: 1/200"
= 1'0"

DP1.0

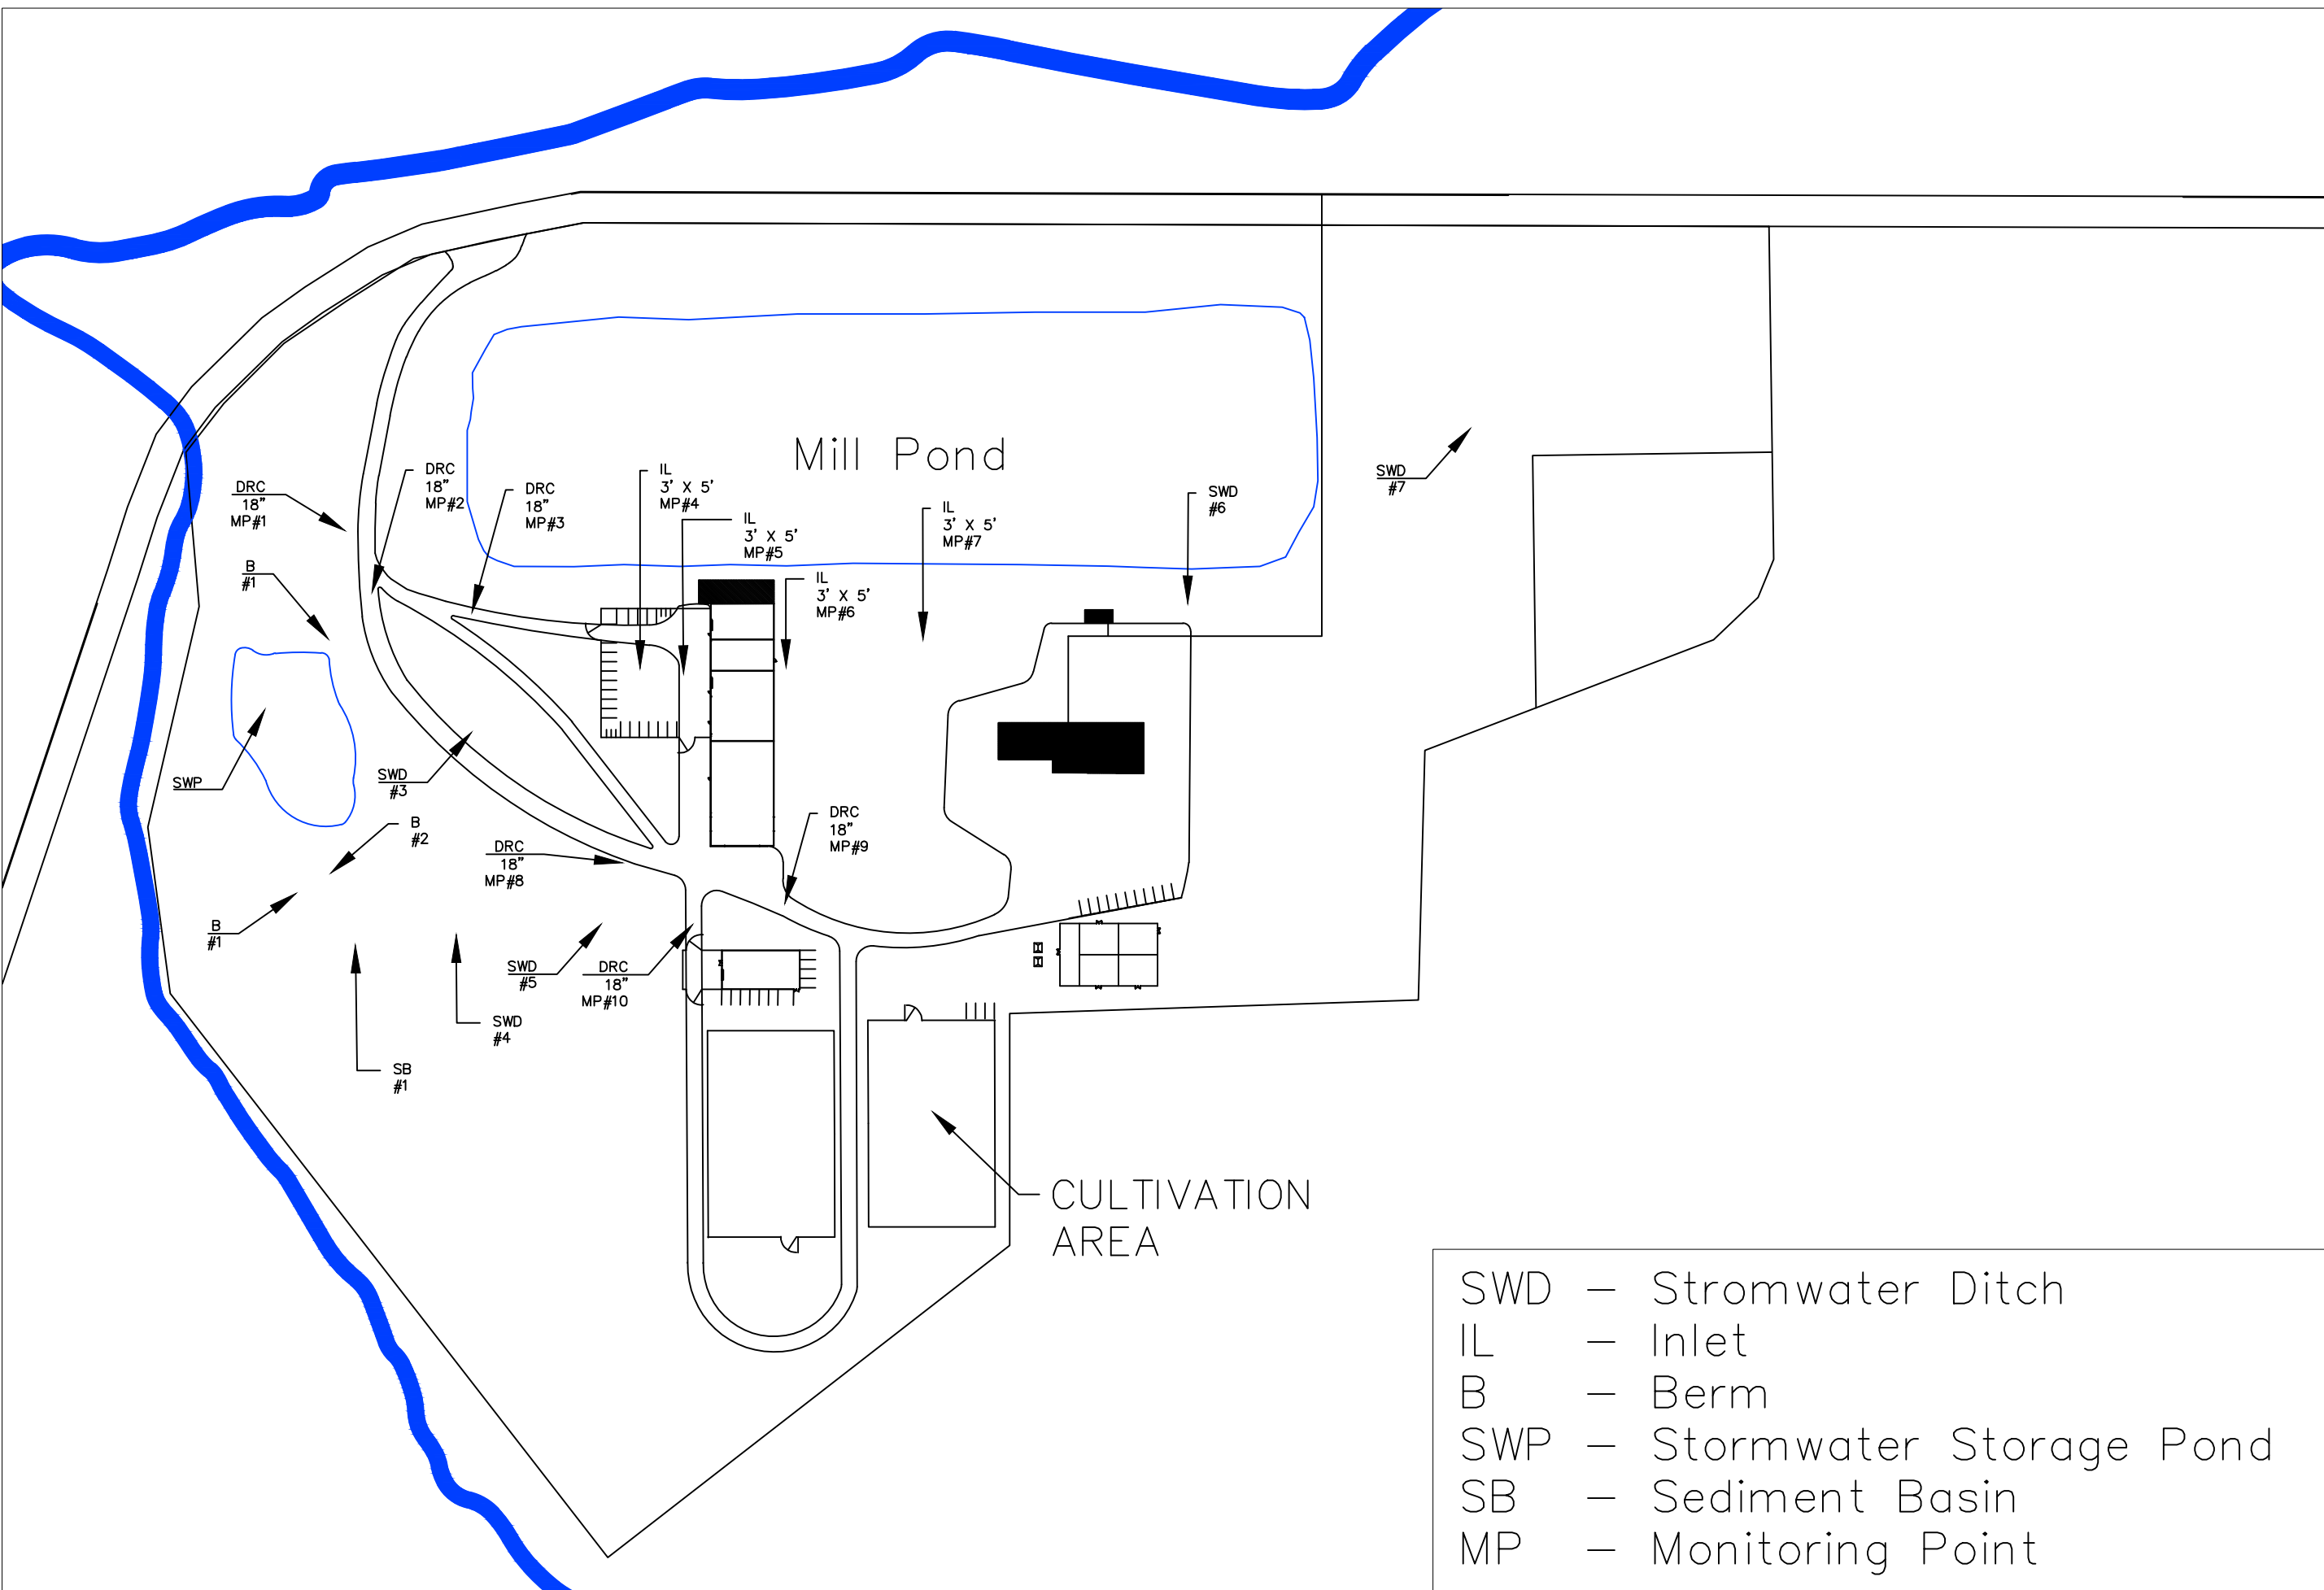

- SWD — Stormwater Ditch
- IL — Inlet
- B — Berm
- SWP — Stormwater Storage Pond
- SB — Sediment Basin
- MP — Monitoring Point