


# BEAUMONT POINTE SITE LIGHTS

BEAUMONT, CA

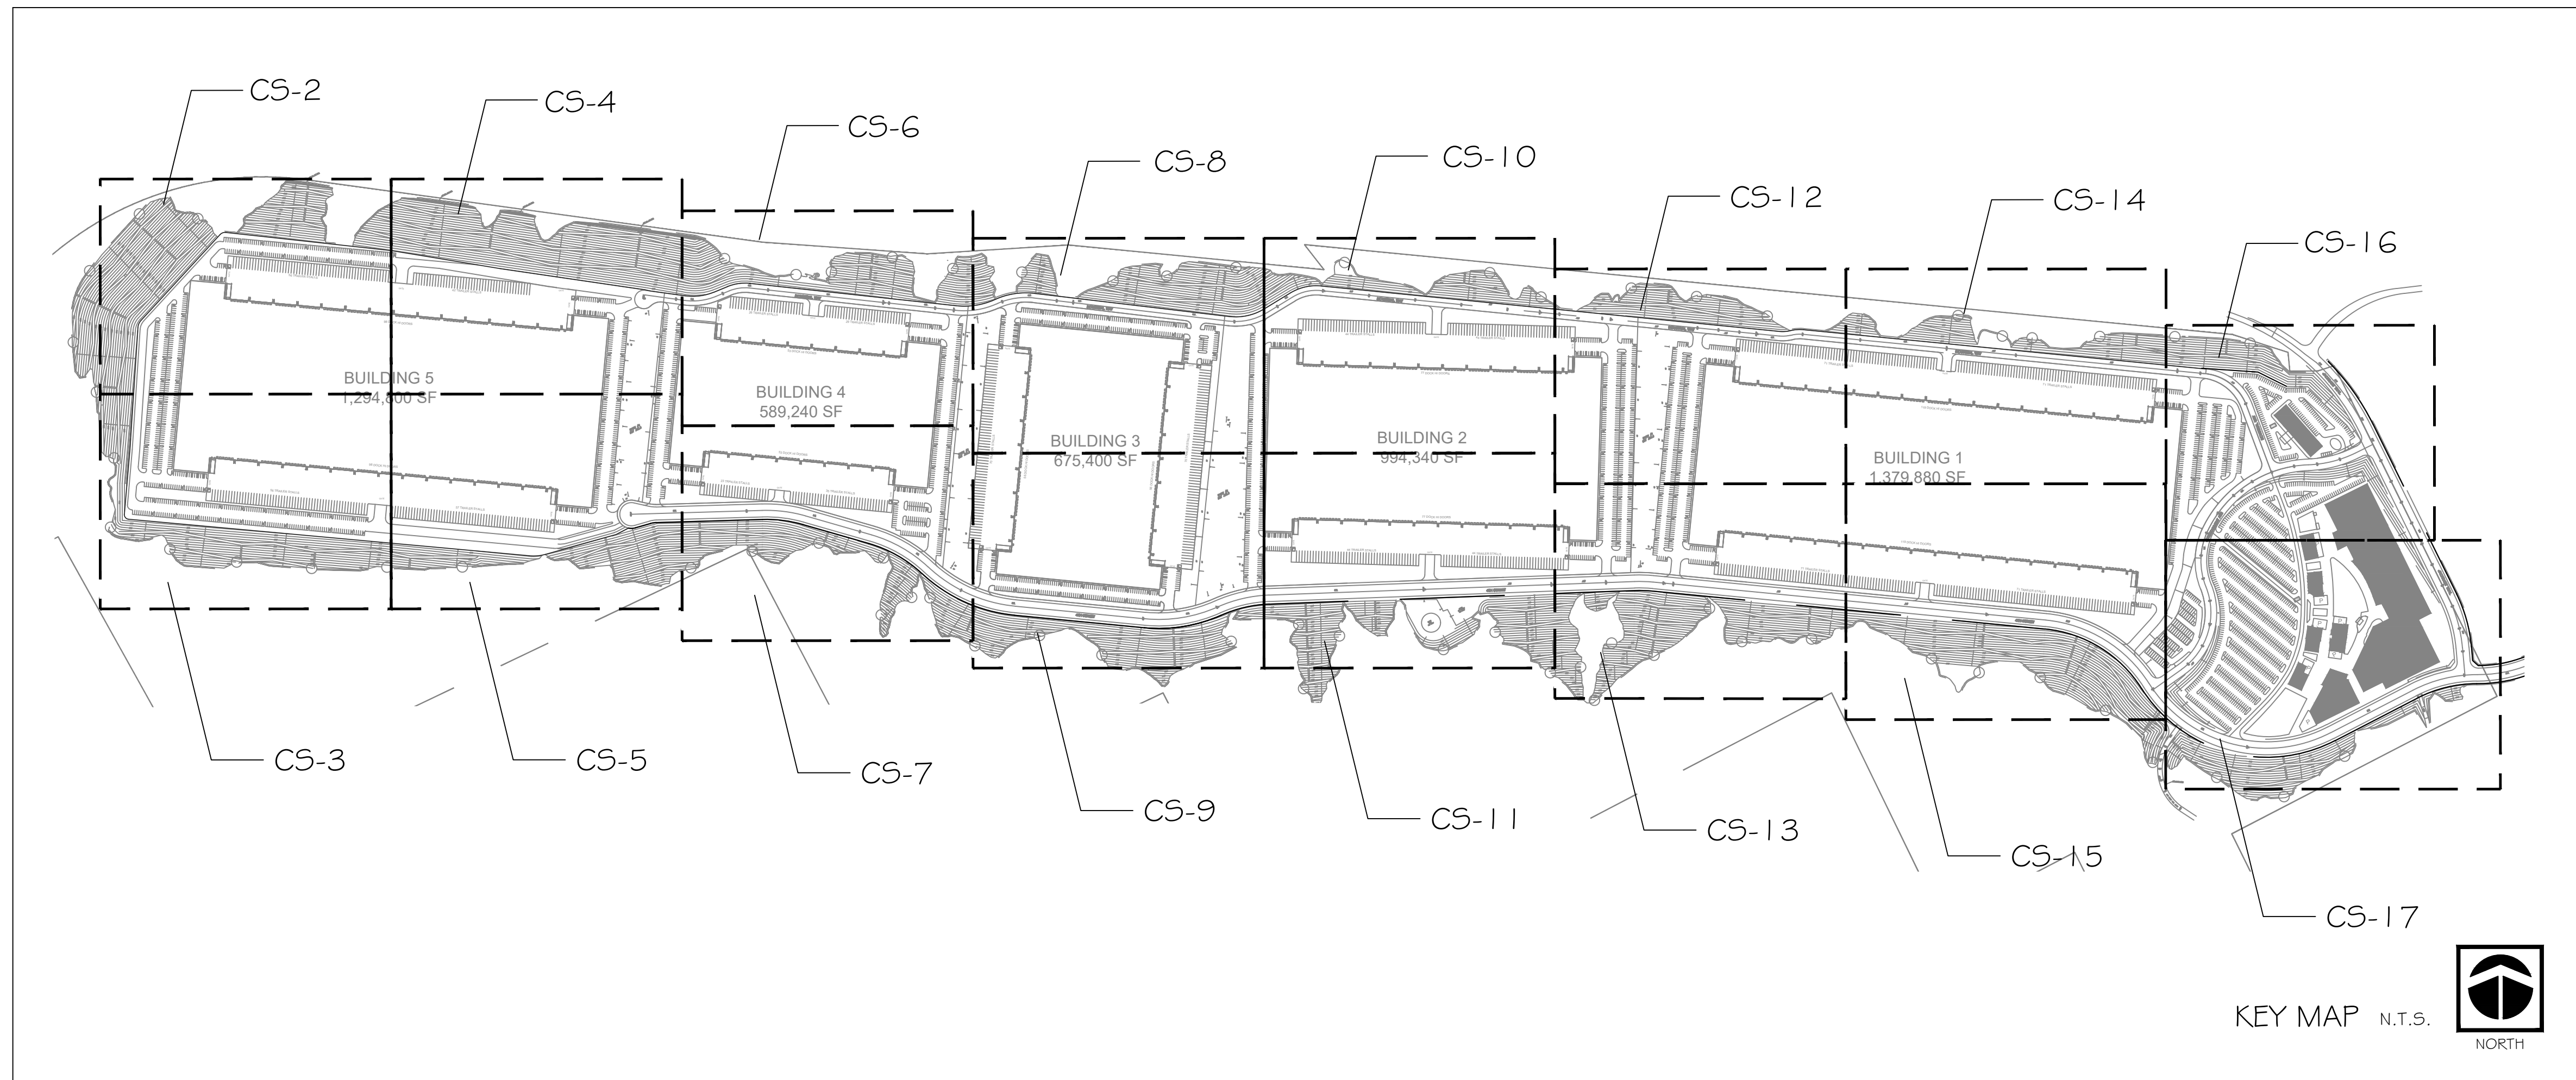

Symbol	Qty	Tag	Label	Arrangement	Lum. Lumens	BUG Rating	LLF	Description	Wattage
☒	115	WALL LIGHT	HUBBELL - AIRO MICRO STRIKE	SINGLE	32152	B3-U0-G5	0.900	ASL2-320L-235-4K7-4W-U @ 39'	235
☒	115	WALL LIGHT	HUBBELL - AIRO MICRO STRIKE	SINGLE	32796	B3-U0-G4	0.900	ASL2-320L-235-4K7-2-U @ 39'	235
▽	30	WALL LIGHT	HUBBELL - AIRO MICRO STRIKE	SINGLE	23853	B3-U0-G4	0.900	ASL2-320L-170-4K7-4W-U @ 25'	168
▽	29	WALL LIGHT	HUBBELL - AIRO MICRO STRIKE	SINGLE	24139	B3-U0-G4	0.900	ASL2-320L-170-4K7-3-U @ 25'	168
▽	20	WALL LIGHT	HUBBELL - AIRO MICRO STRIKE	SINGLE	24330	B3-U0-G3	0.900	ASL2-320L-170-4K7-2-U @ 25'	168
☒	32	POLE LIGHT	HUBBELL - AIRO MICRO STRIKE	SINGLE	23853	B1-U0-G2	0.900	ASL2-320L-170-4K7-4W-BC @ 20'	168
☒	174	POLE LIGHT	HUBBELL - AIRO MICRO STRIKE	SINGLE	23853	B3-U0-G4	0.900	ASL2-320L-170-4K7-4W-U @ 20'	168
☒	8	POLE LIGHT	HUBBELL - AIRO MICRO STRIKE	SINGLE	24139	B1-U0-G2	0.900	ASL2-320L-170-4K7-3-BC @ 20'	168
☒	23	POLE LIGHT	HUBBELL - AIRO MICRO STRIKE	SINGLE	24139	B3-U0-G4	0.900	ASL2-320L-170-4K7-3-U @ 20'	168
☒	5	POLE LIGHT	HUBBELL - AIRO MICRO STRIKE	SINGLE	24330	B1-U0-G2	0.900	ASL2-320L-170-4K7-2-BC @ 20'	168
☒	28	POLE LIGHT	HUBBELL - AIRO MICRO STRIKE	SINGLE	24330	B3-U0-G3	0.900	ASL2-320L-170-4K7-2-U @ 20'	168
☒	3	POLE LIGHT DBL	HUBBELL - AIRO MICRO STRIKE	2 @ 90 DEGREES	23853	B3-U0-G4	0.900	ASL2-320L-170-4K7-4W-U @ 20'	168
☒	44	POLE LIGHT DBL	HUBBELL - AIRO MICRO STRIKE	BACK-BACK	23853	B3-U0-G4	0.900	ASL2-320L-170-4K7-4W-U @ 20'	168


Label	CalcType	Units	Avg	Max	Min	Avg/Min	Max/Min
BLDG1	Illuminance	Fc	3.03	14.0	0.2	15.15	70.00
BLDG2	Illuminance	Fc	3.04	13.8	0.3	10.13	46.00
BLDG3	Illuminance	Fc	3.37	13.5	0.3	11.23	45.00
BLDG4	Illuminance	Fc	3.26	14.6	0.2	16.30	73.00
BLDG5	Illuminance	Fc	3.12	14.2	0.3	10.40	47.33
RETAIL SITE	Illuminance	Fc	3.64	12.2	0.7	5.20	17.43
TRESPASS	Illuminance	Fc	0.00	0.7	0.0	N.A.	N.A.



HUBBELL OUTDOOR LIGHTING  
AIRO MICRO STRIKE  
POLE LIGHT



HUBBELL OUTDOOR LIGHTING  
AIRO MICRO STRIKE  
WALL LIGHT

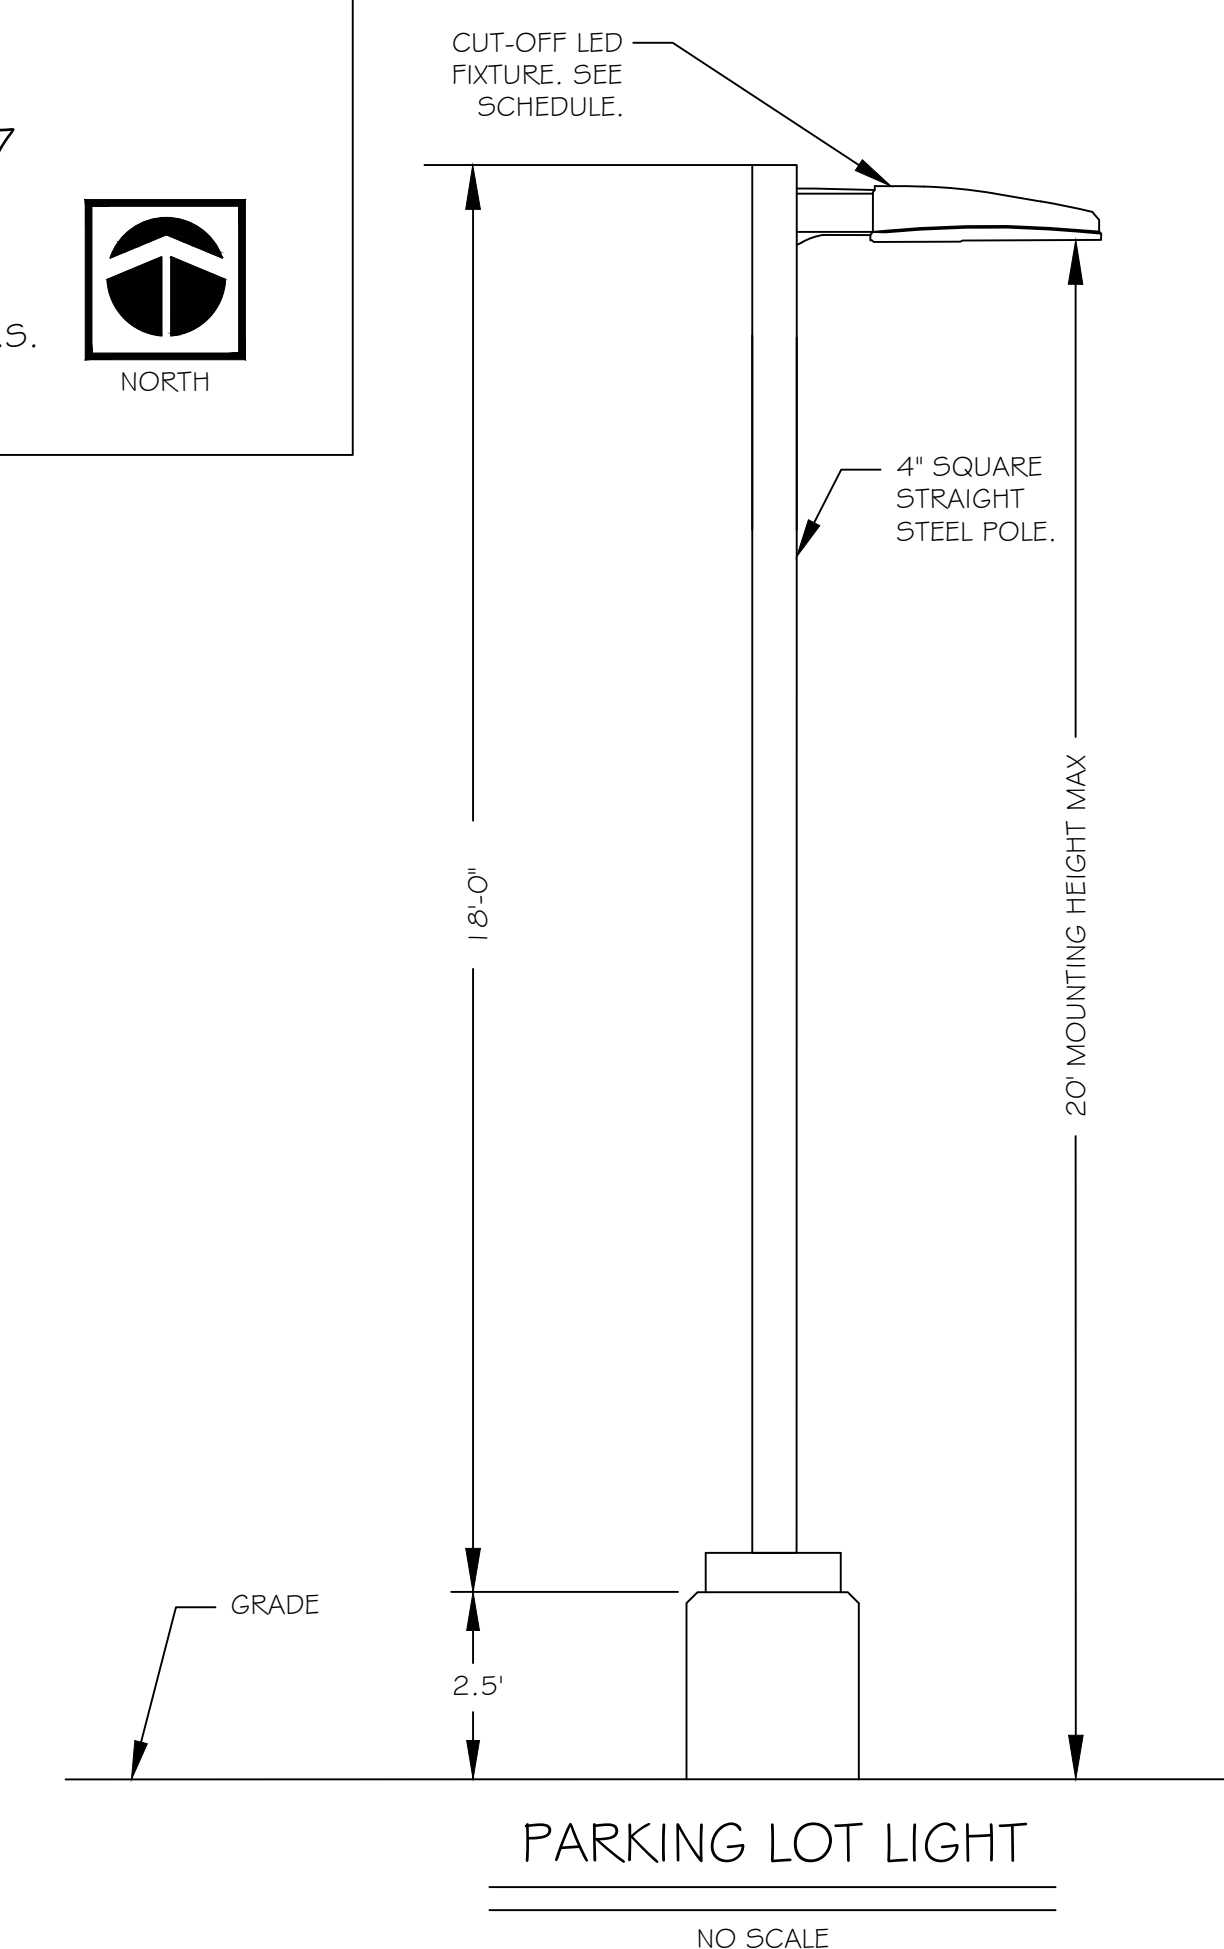

NOTE:

ANY CHANGE OR DEVIATION FROM THE LIGHTING SPECIFICATIONS ON PLAN SHALL INVALIDATE THIS PHOTOMETRIC ANALYSIS.

PRELIMINARY - NOT FOR CONSTRUCTION



OFF: 959-279-4503  
1858 MERCURY ST. STE. 210, SAN JOSE, CA 95128  
WWW.VISUALCONCEPTSLIGHTING.COM

Project:  
BEAUMONT POINTE  
SITE LIGHTS  
BEAUMONT, CA.

Client:  
JRT PBI, LLC  
18032 LEMON DE. STE. 367  
YORBA LINDA, CA 92886



Revisions:

Sheet Info:

Drawn By: AZ  
Checked By: KPJR  
Scale: N/A  
Date: 2/18/2021  
Job No.: JRT21/02011


Sheet Title:  
CONCEPTUAL  
SHEET 1

Sheet Reference:

CS-1


Sheet: 1 of 19

Luminaire Schedule										Calculation Summary							
Symbol	Qty	Tag	Label	Arrangement	Lum. Lumens	BUG Rating	LLF	Description	Wattage	Label	CalcType	Units	Avg	Max	Min	Avg/Min	Max/Min
★	115	WALL LIGHT	HUBBELL - AIRO MICRO STRIKE	SINGLE	32152	B3-U0-G5	0.900	ASL2-320L-235-4K7-4W-U @ 39'	235	BLDG1	Illuminance	Fc	3.03	14.0	0.2	15.15	70.00
★	115	WALL LIGHT	HUBBELL - AIRO MICRO STRIKE	SINGLE	32796	B3-U0-G4	0.900	ASL2-320L-235-4K7-2-U @ 39'	235	BLDG2	Illuminance	Fc	3.04	13.8	0.3	10.13	46.00
▽	30	WALL LIGHT	HUBBELL - AIRO MICRO STRIKE	SINGLE	23853	B3-U0-G4	0.900	ASL2-320L-170-4K7-4W-U @ 25'	168	BLDG3	Illuminance	Fc	3.37	13.5	0.3	11.23	45.00
▽	29	WALL LIGHT	HUBBELL - AIRO MICRO STRIKE	SINGLE	24139	B3-U0-G4	0.900	ASL2-320L-170-4K7-3-U @ 25'	168	BLDG4	Illuminance	Fc	3.26	14.6	0.2	16.30	73.00
▽	20	WALL LIGHT	HUBBELL - AIRO MICRO STRIKE	SINGLE	24330	B3-U0-G3	0.900	ASL2-320L-170-4K7-2-U @ 25'	168	BLDG5	Illuminance	Fc	3.12	14.2	0.3	10.40	47.33
□	32	POLE LIGHT	HUBBELL - AIRO MICRO STRIKE	SINGLE	23853	B1-U0-G2	0.900	ASL2-320L-170-4K7-4W-BC @ 20'	168	RETAIL SITE	Illuminance	Fc	3.64	12.2	0.7	5.20	17.43
□	174	POLE LIGHT	HUBBELL - AIRO MICRO STRIKE	SINGLE	23853	B3-U0-G4	0.900	ASL2-320L-170-4K7-4W-U @ 20'	168	TRESPASS	Illuminance	Fc	0.00	0.7	0.0	N.A.	N.A.
□	8	POLE LIGHT	HUBBELL - AIRO MICRO STRIKE	SINGLE	24139	B1-U0-G2	0.900	ASL2-320L-170-4K7-3-BC @ 20'	168								
□	23	POLE LIGHT	HUBBELL - AIRO MICRO STRIKE	SINGLE	24139	B3-U0-G4	0.900	ASL2-320L-170-4K7-3-U @ 20'	168								
□	5	POLE LIGHT	HUBBELL - AIRO MICRO STRIKE	SINGLE	24330	B1-U0-G2	0.900	ASL2-320L-170-4K7-2-BC @ 20'	168								
□	28	POLE LIGHT	HUBBELL - AIRO MICRO STRIKE	SINGLE	24330	B3-U0-G3	0.900	ASL2-320L-170-4K7-2-U @ 20'	168								
□	3	POLE LIGHT DBL	HUBBELL - AIRO MICRO STRIKE	2 @ 90 DEGREES	23853	B3-U0-G4	0.900	ASL2-320L-170-4K7-4W-U @ 20'	168								
□	44	POLE LIGHT DBL	HUBBELL - AIRO MICRO STRIKE	BACK-BACK	23853	B3-U0-G4	0.900	ASL2-320L-170-4K7-4W-U @ 20'	168								

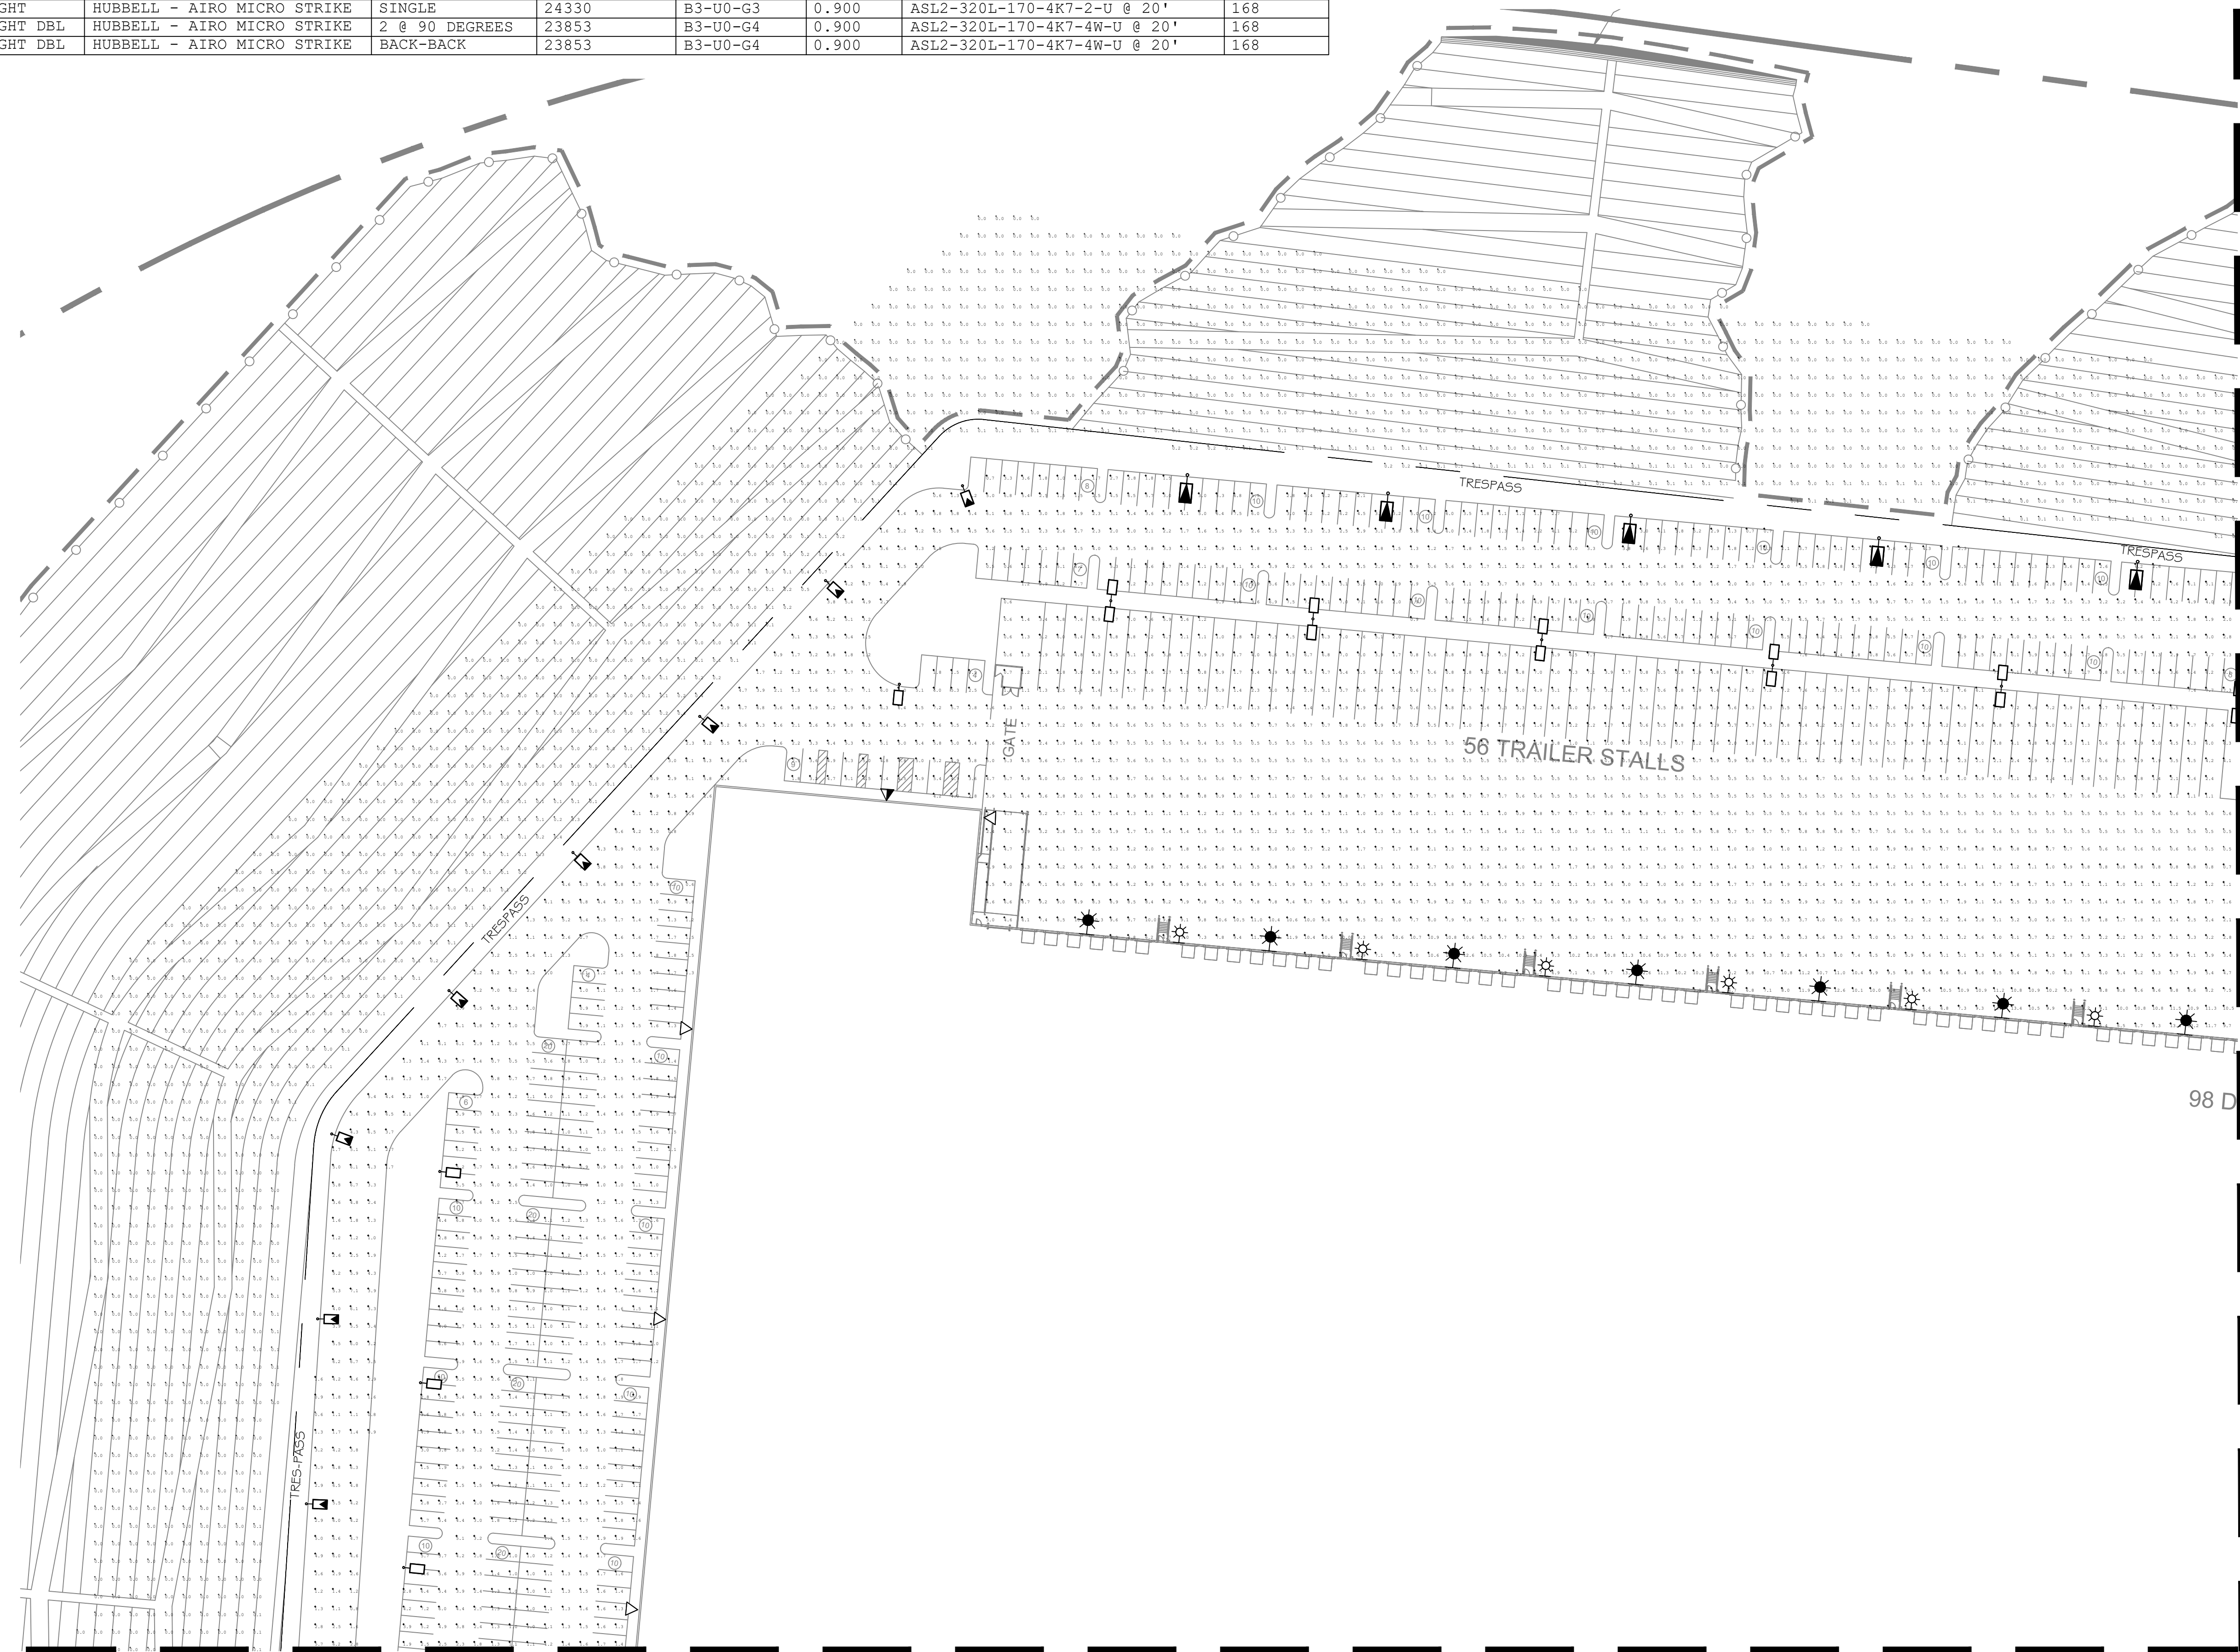


MATCHLINE - SEE SHEET CS-3

MATCHLINE - SEE SHEET CS-4

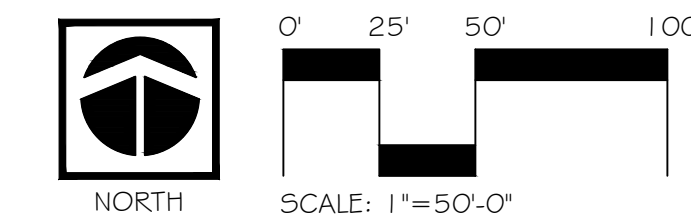

PRELIMINARY - NOT FOR CONSTRUCTION

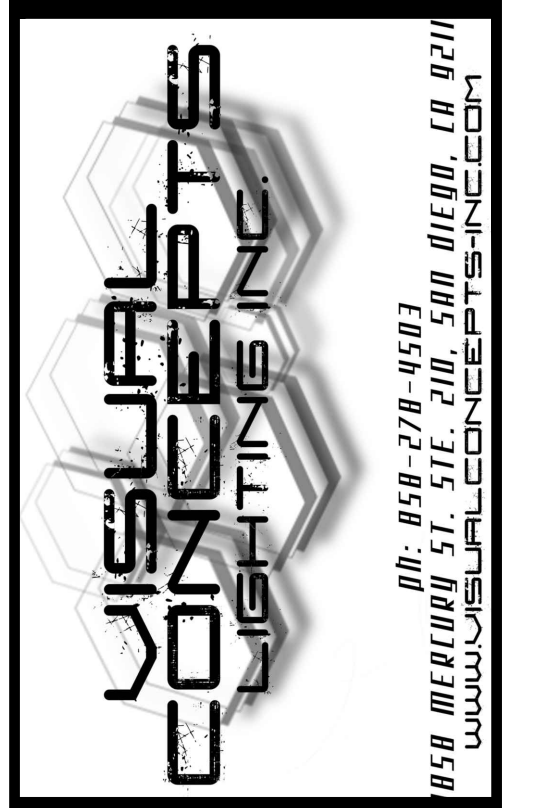

Project:  
BEAUMONT POINTE  
SITE LIGHTS  
BEAUMONT, CA.

Client:  
JRT PBI, LLC  
18032 LEMON DE. STE. 367  
YORBA LINDA, CA 92886



Revisions:


Sheet Info:  
Drawn By: AZ  
Checked By: KPJR  
Scale: 1"=50'-0"  
Date: 2/18/2021  
Job No.: JRT21/02011

Sheet Title:  
CONCEPTUAL  
PLAN 2

Sheet Reference:



CS-2  
Sheet: 2 of 19

MATCHLINE - SEE SHEET CS-2

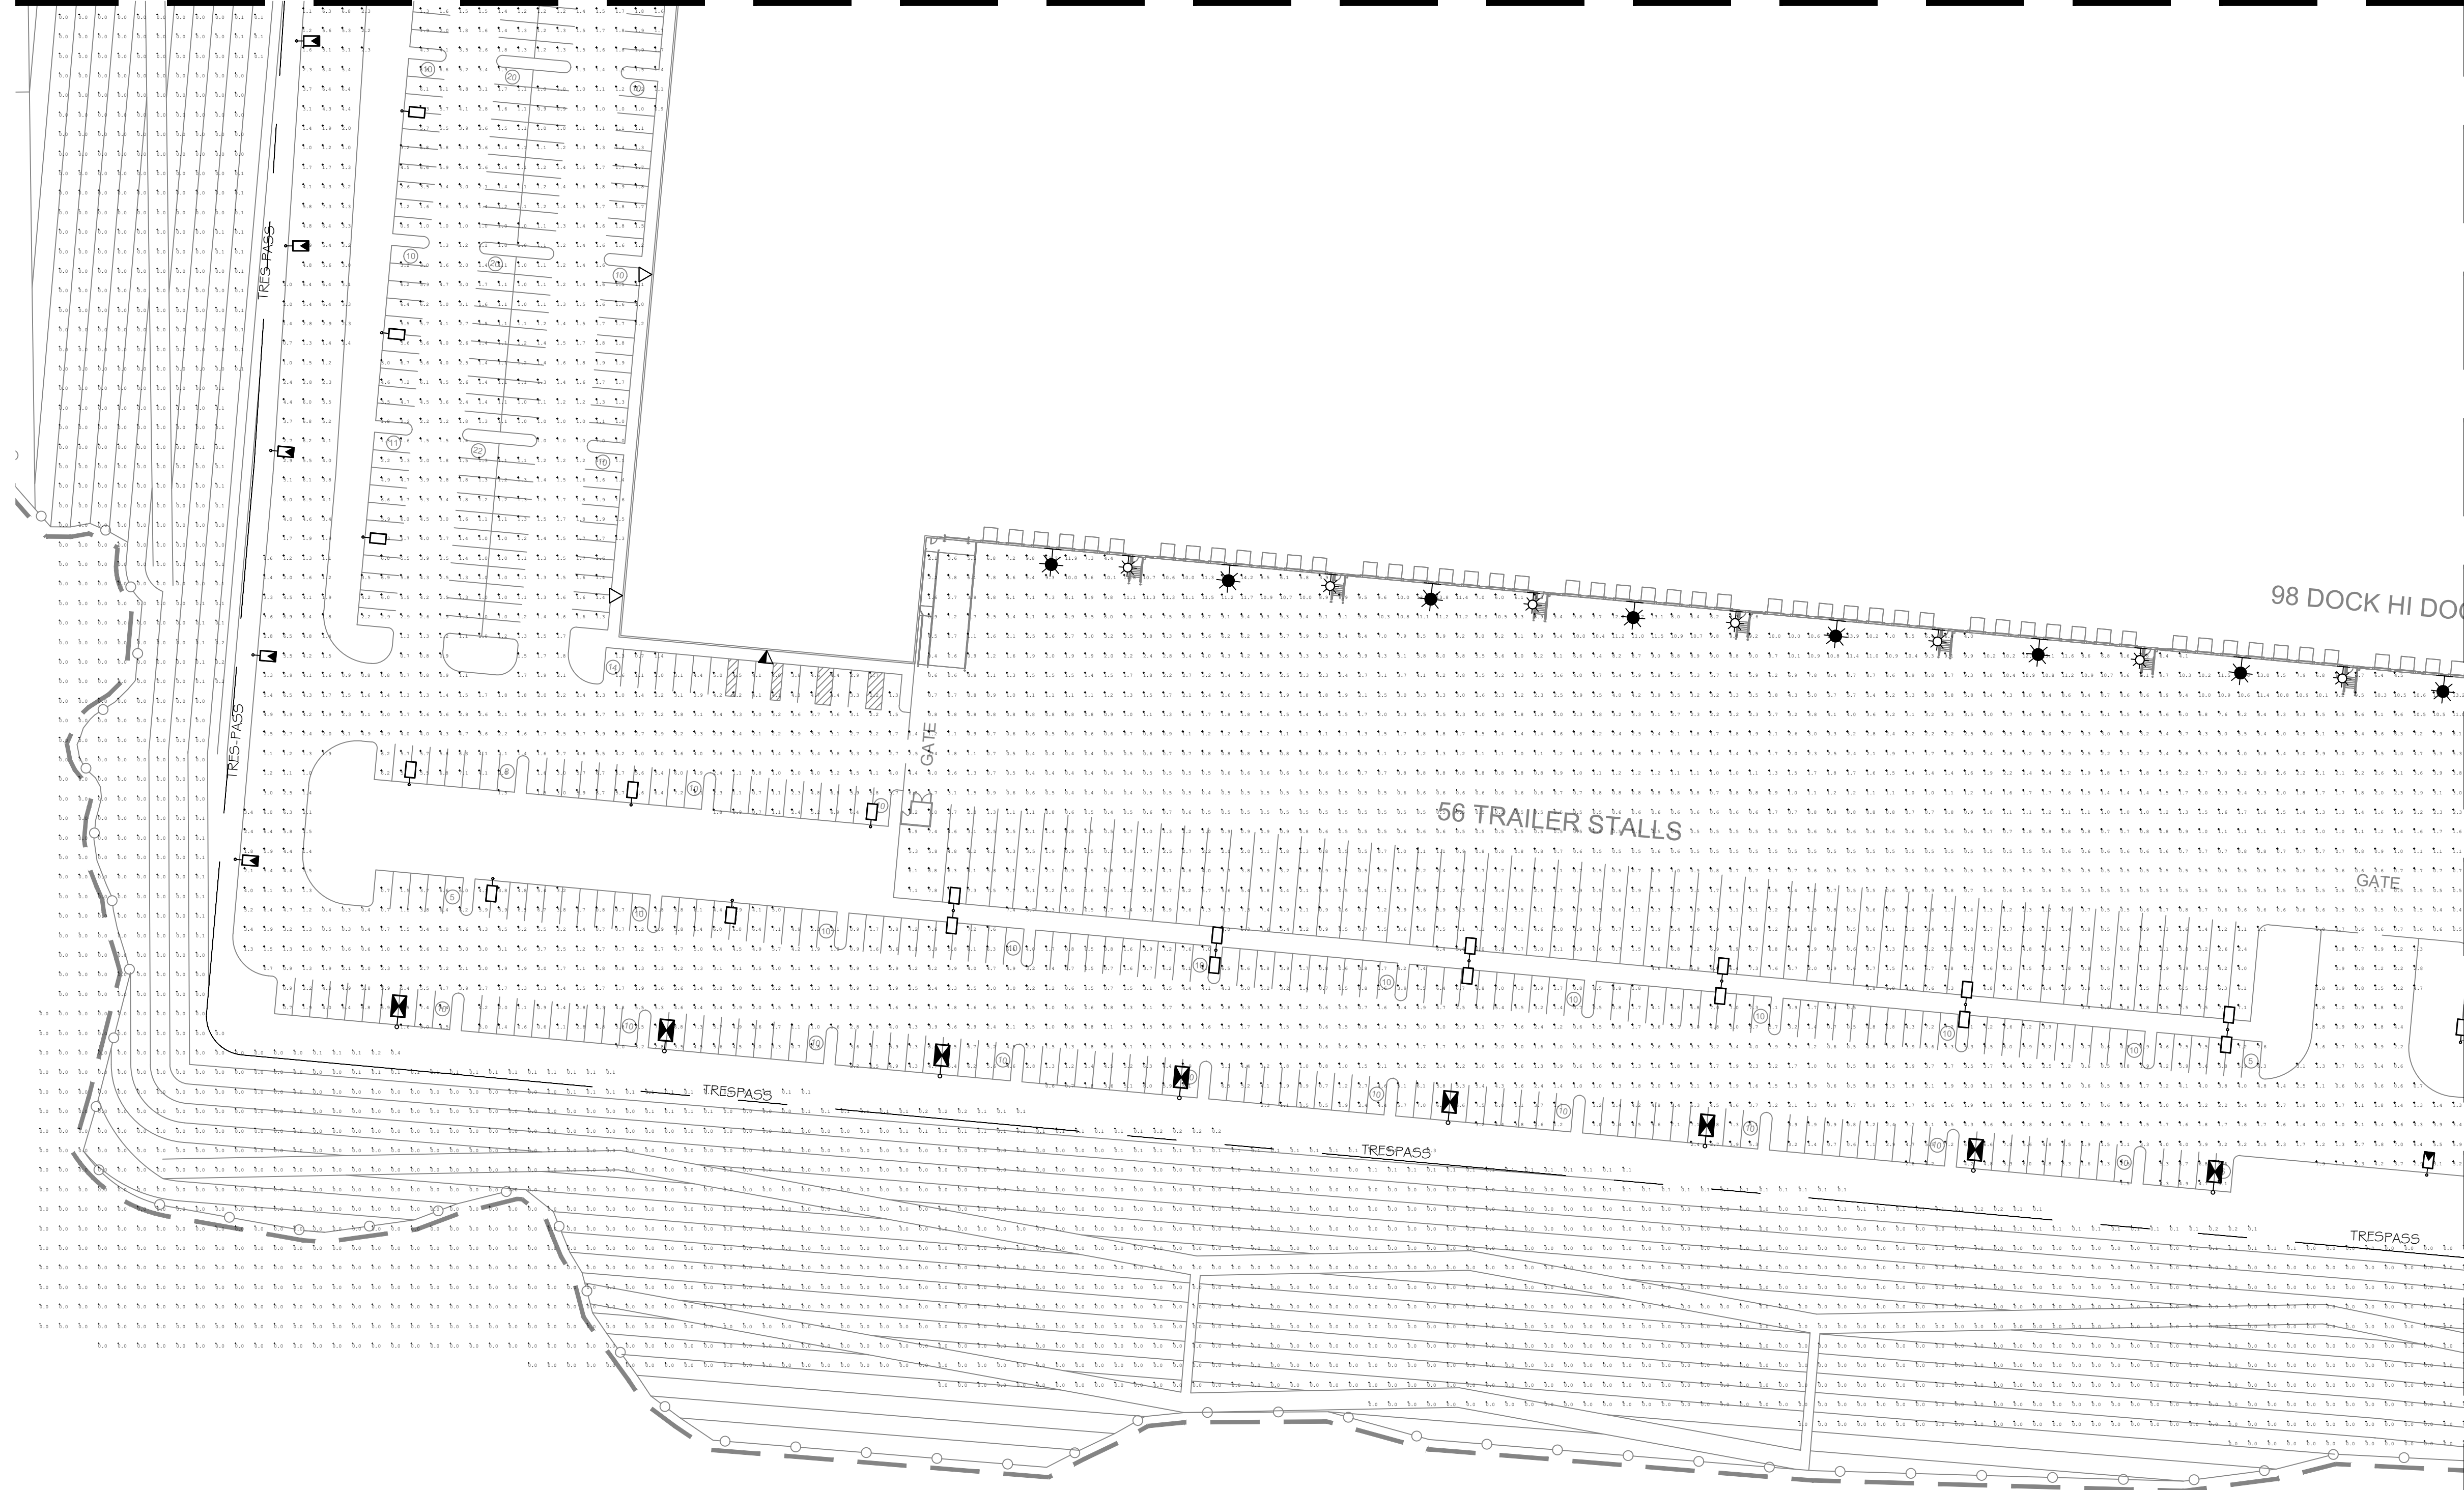

Symbol	Qty	Tag	Label	Arrangement	Lum. Lumens	BUG Rating	LLF	Description	Wattage
⊗	115	WALL LIGHT	HUBBELL - AIRO MICRO STRIKE	SINGLE	32152	B3-U0-G5	0.900	ASL2-320L-235-4K7-4W-U @ 39'	235
⊗	115	WALL LIGHT	HUBBELL - AIRO MICRO STRIKE	SINGLE	32796	B3-U0-G4	0.900	ASL2-320L-235-4K7-2-U @ 39'	235
▽	30	WALL LIGHT	HUBBELL - AIRO MICRO STRIKE	SINGLE	23853	B3-U0-G4	0.900	ASL2-320L-170-4K7-4W-U @ 25'	168
▽	29	WALL LIGHT	HUBBELL - AIRO MICRO STRIKE	SINGLE	24139	B3-U0-G4	0.900	ASL2-320L-170-4K7-3-U @ 25'	168
▽	20	WALL LIGHT	HUBBELL - AIRO MICRO STRIKE	SINGLE	24330	B3-U0-G3	0.900	ASL2-320L-170-4K7-2-U @ 25'	168
⊠	32	POLE LIGHT	HUBBELL - AIRO MICRO STRIKE	SINGLE	23853	B1-U0-G2	0.900	ASL2-320L-170-4K7-4W-BC @ 20'	168
⊠	174	POLE LIGHT	HUBBELL - AIRO MICRO STRIKE	SINGLE	23853	B3-U0-G4	0.900	ASL2-320L-170-4K7-4W-U @ 20'	168
⊠	8	POLE LIGHT	HUBBELL - AIRO MICRO STRIKE	SINGLE	24139	B1-U0-G2	0.900	ASL2-320L-170-4K7-3-BC @ 20'	168
⊠	23	POLE LIGHT	HUBBELL - AIRO MICRO STRIKE	SINGLE	24139	B3-U0-G4	0.900	ASL2-320L-170-4K7-3-U @ 20'	168
⊠	5	POLE LIGHT	HUBBELL - AIRO MICRO STRIKE	SINGLE	24330	B1-U0-G2	0.900	ASL2-320L-170-4K7-2-BC @ 20'	168
⊠	28	POLE LIGHT	HUBBELL - AIRO MICRO STRIKE	SINGLE	24330	B3-U0-G3	0.900	ASL2-320L-170-4K7-2-U @ 20'	168
⊠	3	POLE LIGHT DBL	HUBBELL - AIRO MICRO STRIKE	2 @ 90 DEGREES	23853	B3-U0-G4	0.900	ASL2-320L-170-4K7-4W-U @ 20'	168
⊠	44	POLE LIGHT DBL	HUBBELL - AIRO MICRO STRIKE	BACK-BACK	23853	B3-U0-G4	0.900	ASL2-320L-170-4K7-4W-U @ 20'	168

Label	CalcType	Units	Avg	Max	Min	Avg/Min	Max/Min
BLDG1	Illuminance	Fc	3.03	14.0	0.2	15.15	70.00
BLDG2	Illuminance	Fc	3.04	13.8	0.3	10.13	46.00
BLDG3	Illuminance	Fc	3.37	13.5	0.3	11.23	45.00
BLDG4	Illuminance	Fc	3.26	14.6	0.2	16.30	73.00
BLDG5	Illuminance	Fc	3.12	14.2	0.3	10.40	47.33
RETAIL SITE	Illuminance	Fc	3.64	12.2	0.7	5.20	17.43
TRESPASS	Illuminance	Fc	0.00	0.7	0.0	N.A.	N.A.

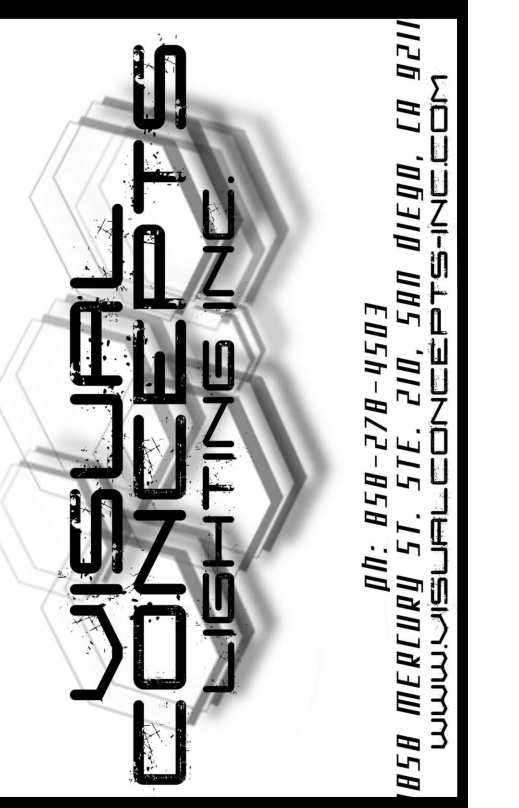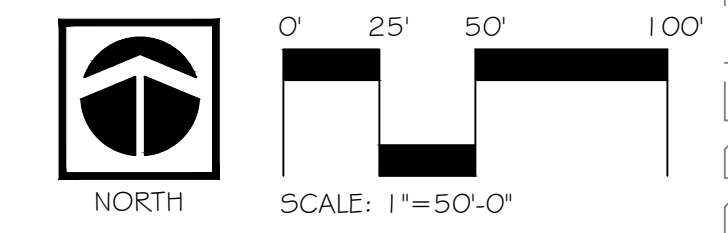

Project:  
BEAUMONT POINTE  
SITE LIGHTS  
BEAUMONT, CA.

Client:  
JRT PBI, LLC  
18032 LEMON DE. STE. 367  
YORBA LINDA, CA 92886



Revisions:


Sheet Info:  
Drawn By: AZ  
Checked By: KPJR  
Scale: 1" = 50'-0"  
Date: 2/18/2021  
Job No.: JRT21/02011


Sheet Title:  
CONCEPTUAL  
PLAN 3

Sheet Reference:

CS-3  
Sheet: 3 of 19

PRELIMINARY - NOT FOR CONSTRUCTION


Luminaire Schedule										Calculation Summary							
Symbol	Qty	Tag	Label	Arrangement	Lum. Lumens	BUG Rating	LLF	Description	Wattage	Label	CalcType	Units	Avg	Max	Min	Avg/Min	Max/Min
★	115	WALL LIGHT	HUBBELL - AIRO MICRO STRIKE	SINGLE	32152	B3-U0-G5	0.900	ASL2-320L-235-4K7-4W-U @ 39'	235	BLDG1	Illuminance	Fc	3.03	14.0	0.2	15.15	70.00
★	115	WALL LIGHT	HUBBELL - AIRO MICRO STRIKE	SINGLE	32796	B3-U0-G4	0.900	ASL2-320L-235-4K7-2-U @ 39'	235	BLDG2	Illuminance	Fc	3.04	13.8	0.3	10.13	46.00
▽	30	WALL LIGHT	HUBBELL - AIRO MICRO STRIKE	SINGLE	23853	B3-U0-G4	0.900	ASL2-320L-170-4K7-4W-U @ 25'	168	BLDG3	Illuminance	Fc	3.37	13.5	0.3	11.23	45.00
▽	29	WALL LIGHT	HUBBELL - AIRO MICRO STRIKE	SINGLE	24139	B3-U0-G4	0.900	ASL2-320L-170-4K7-3-U @ 25'	168	BLDG4	Illuminance	Fc	3.26	14.6	0.2	16.30	73.00
▽	20	WALL LIGHT	HUBBELL - AIRO MICRO STRIKE	SINGLE	24330	B3-U0-G3	0.900	ASL2-320L-170-4K7-2-U @ 25'	168	BLDG5	Illuminance	Fc	3.12	14.2	0.3	10.40	47.33
□	32	POLE LIGHT	HUBBELL - AIRO MICRO STRIKE	SINGLE	23853	B1-U0-G2	0.900	ASL2-320L-170-4K7-4W-BC @ 20'	168	RETAIL SITE	Illuminance	Fc	3.64	12.2	0.7	5.20	17.43
□	174	POLE LIGHT	HUBBELL - AIRO MICRO STRIKE	SINGLE	23853	B3-U0-G4	0.900	ASL2-320L-170-4K7-4W-U @ 20'	168	TRESPASS	Illuminance	Fc	0.00	0.7	0.0	N.A.	N.A.
□	8	POLE LIGHT	HUBBELL - AIRO MICRO STRIKE	SINGLE	24139	B1-U0-G2	0.900	ASL2-320L-170-4K7-3-BC @ 20'	168								
□	23	POLE LIGHT	HUBBELL - AIRO MICRO STRIKE	SINGLE	24139	B3-U0-G4	0.900	ASL2-320L-170-4K7-3-U @ 20'	168								
□	5	POLE LIGHT	HUBBELL - AIRO MICRO STRIKE	SINGLE	24330	B1-U0-G2	0.900	ASL2-320L-170-4K7-2-BC @ 20'	168								
□	28	POLE LIGHT	HUBBELL - AIRO MICRO STRIKE	SINGLE	24330	B3-U0-G3	0.900	ASL2-320L-170-4K7-2-U @ 20'	168								
□	3	POLE LIGHT DBL	HUBBELL - AIRO MICRO STRIKE	2 @ 90 DEGREES	23853	B3-U0-G4	0.900	ASL2-320L-170-4K7-4W-U @ 20'	168								
□	44	POLE LIGHT DBL	HUBBELL - AIRO MICRO STRIKE	BACK-BACK	23853	B3-U0-G4	0.900	ASL2-320L-170-4K7-4W-U @ 20'	168								

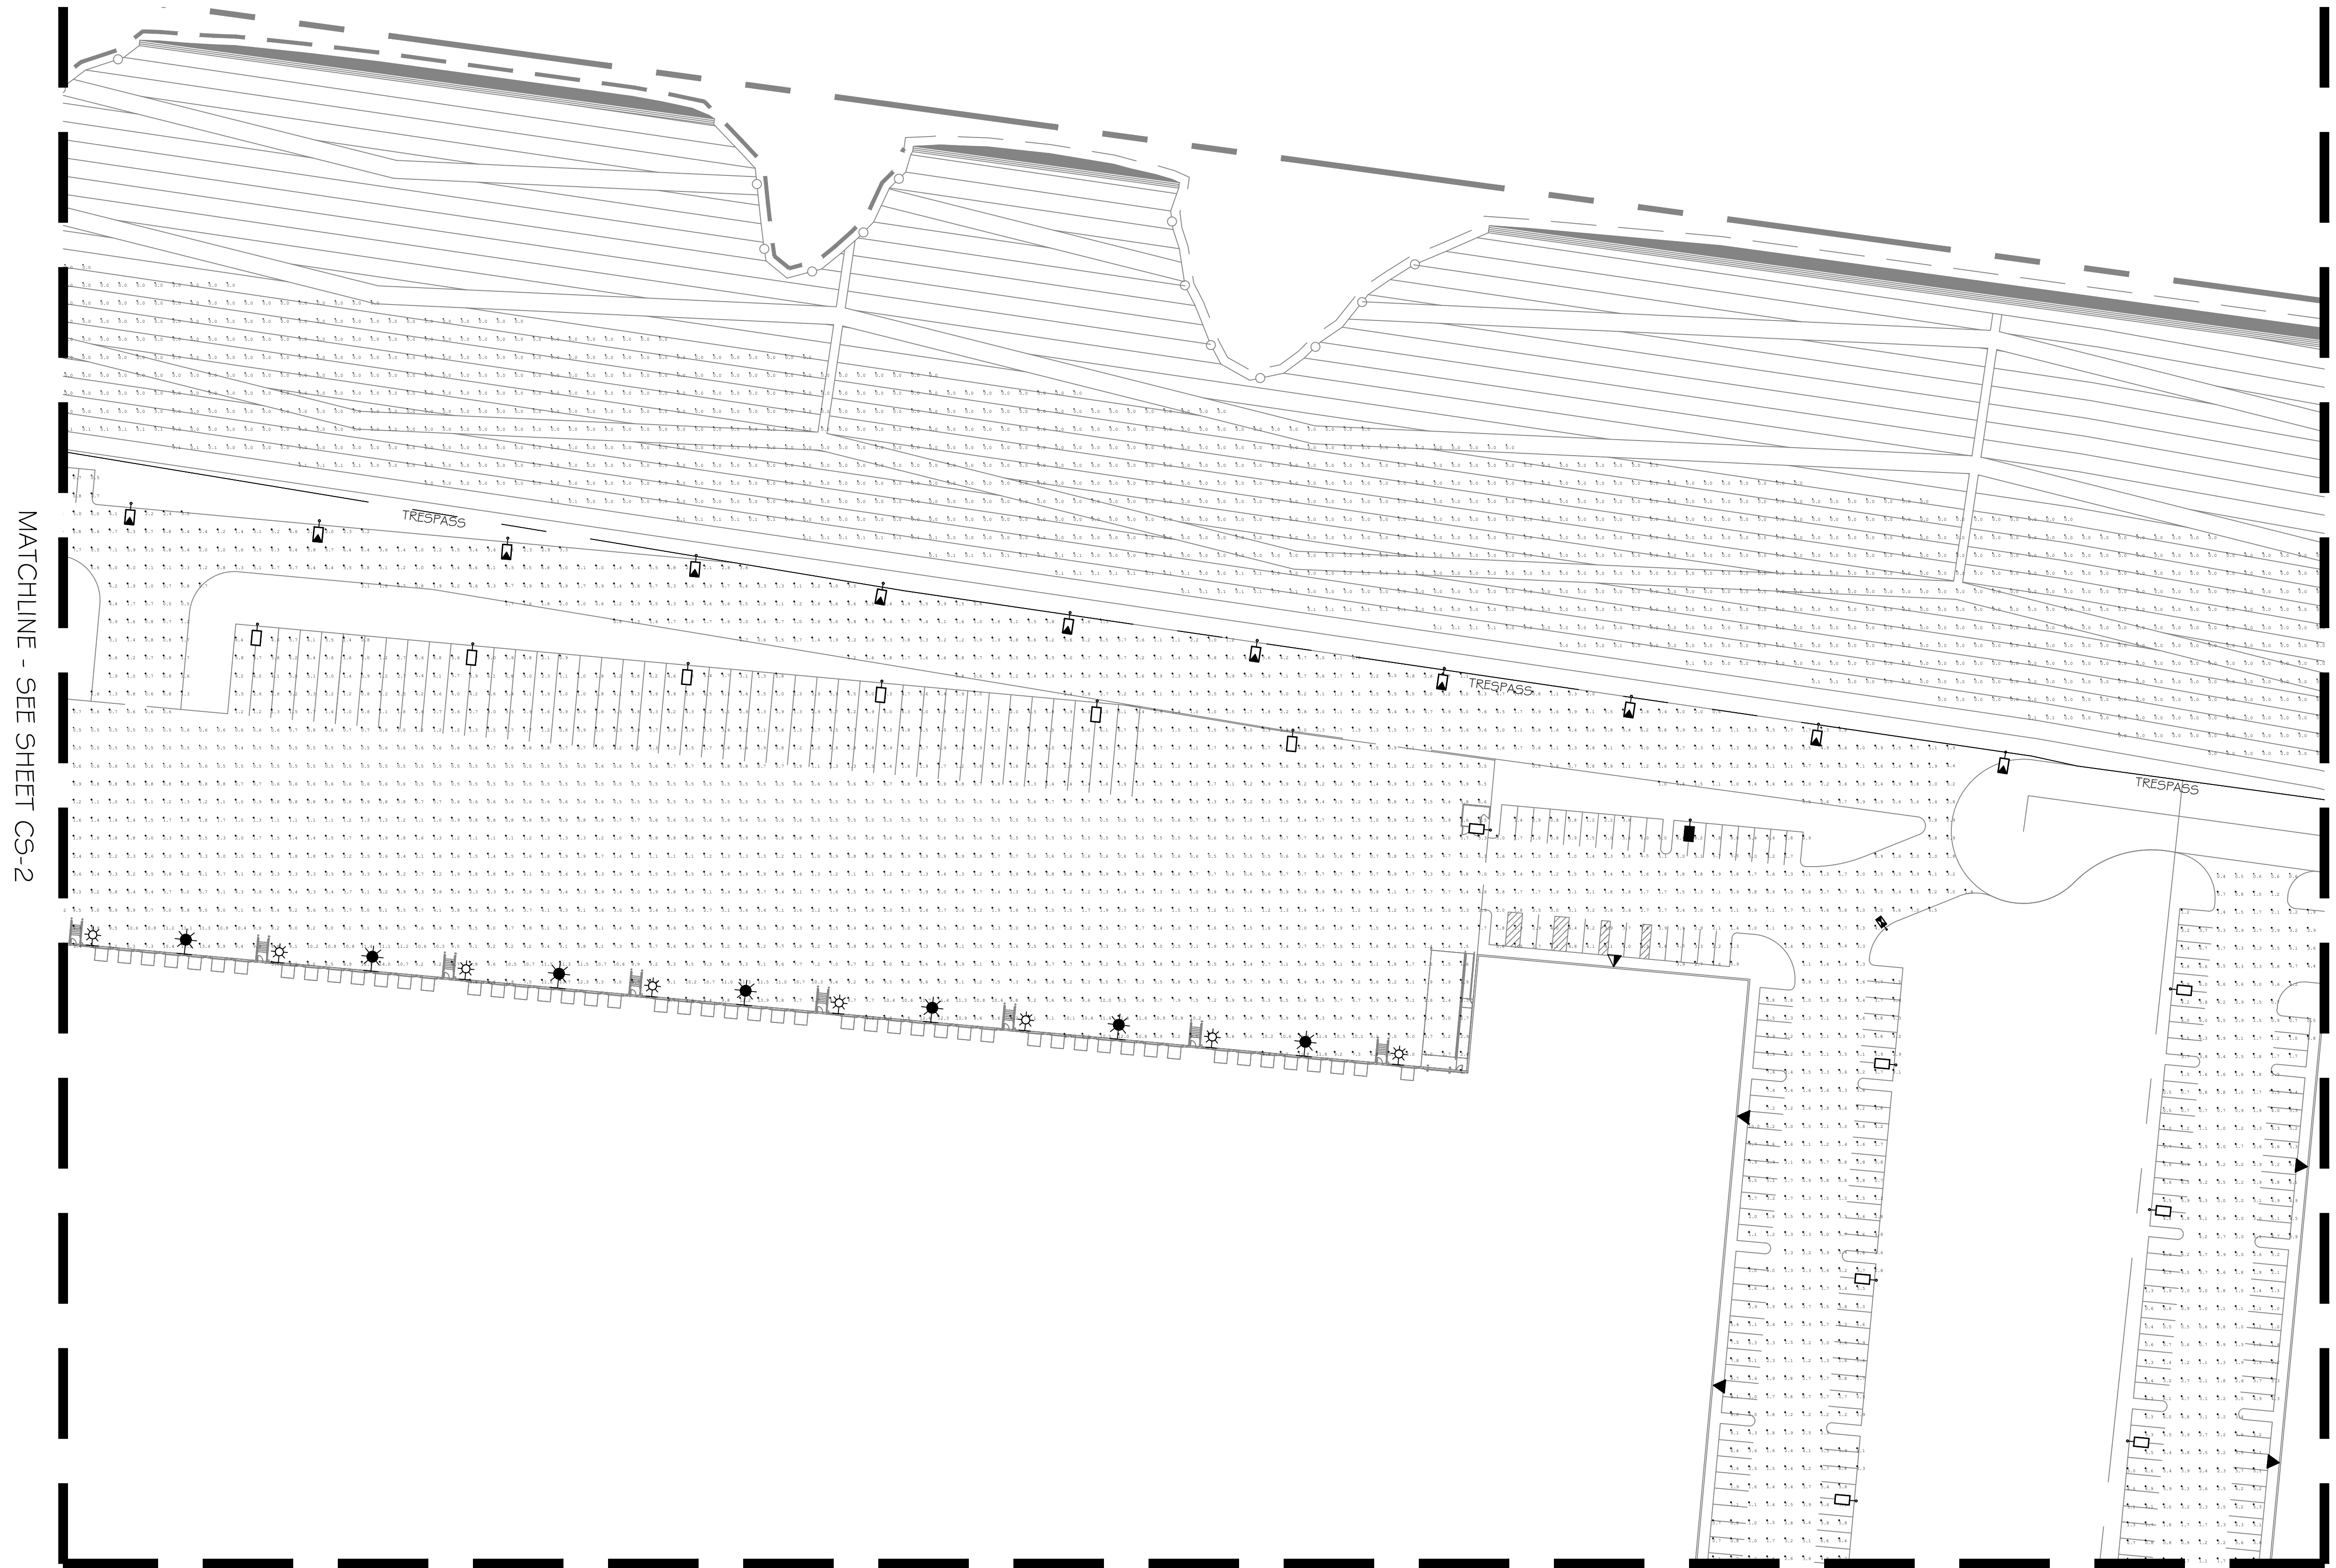


MATCHLINE - SEE SHEET CS-2

MATCHLINE - SEE SHEET CS-6

MATCHLINE - SEE SHEET CS-5

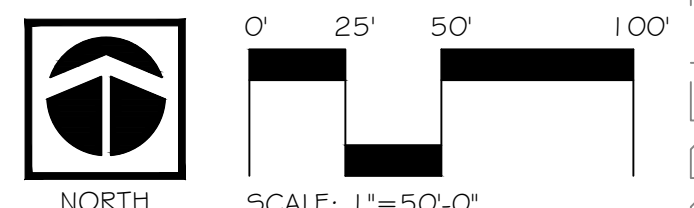

PRELIMINARY - NOT FOR CONSTRUCTION

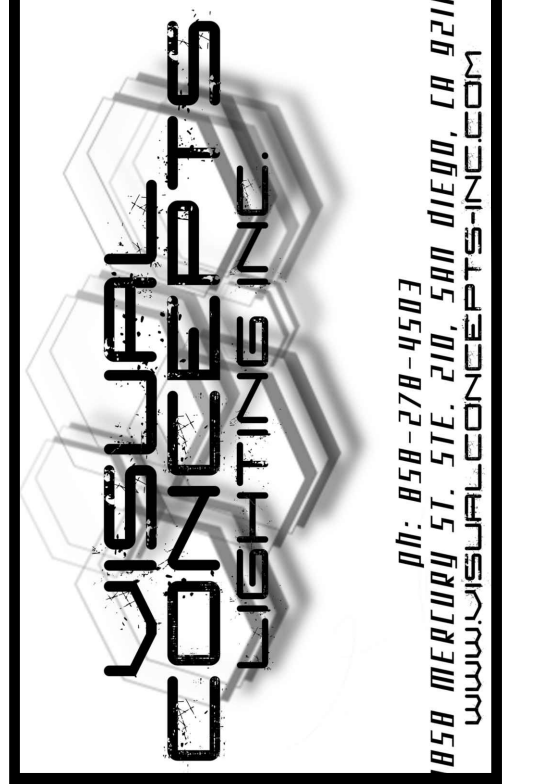

Project:  
BEAUMONT POINTE  
SITE LIGHTS  
BEAUMONT, CA.

Client:  
JRT PBI, LLC  
18032 LEMON DE. STE. 367  
YORBA LINDA, CA 92886




Revisions:


Sheet Info:  
Drawn By: AZ  
Checked By: KPJR  
Scale: 1"=50'-0"  
Date: 2/18/2021  
Job No.: JRT21/02011


Sheet Title:  
CONCEPTUAL  
PLAN 4

Sheet Reference:

CS-4  
Sheet: 3 of 19

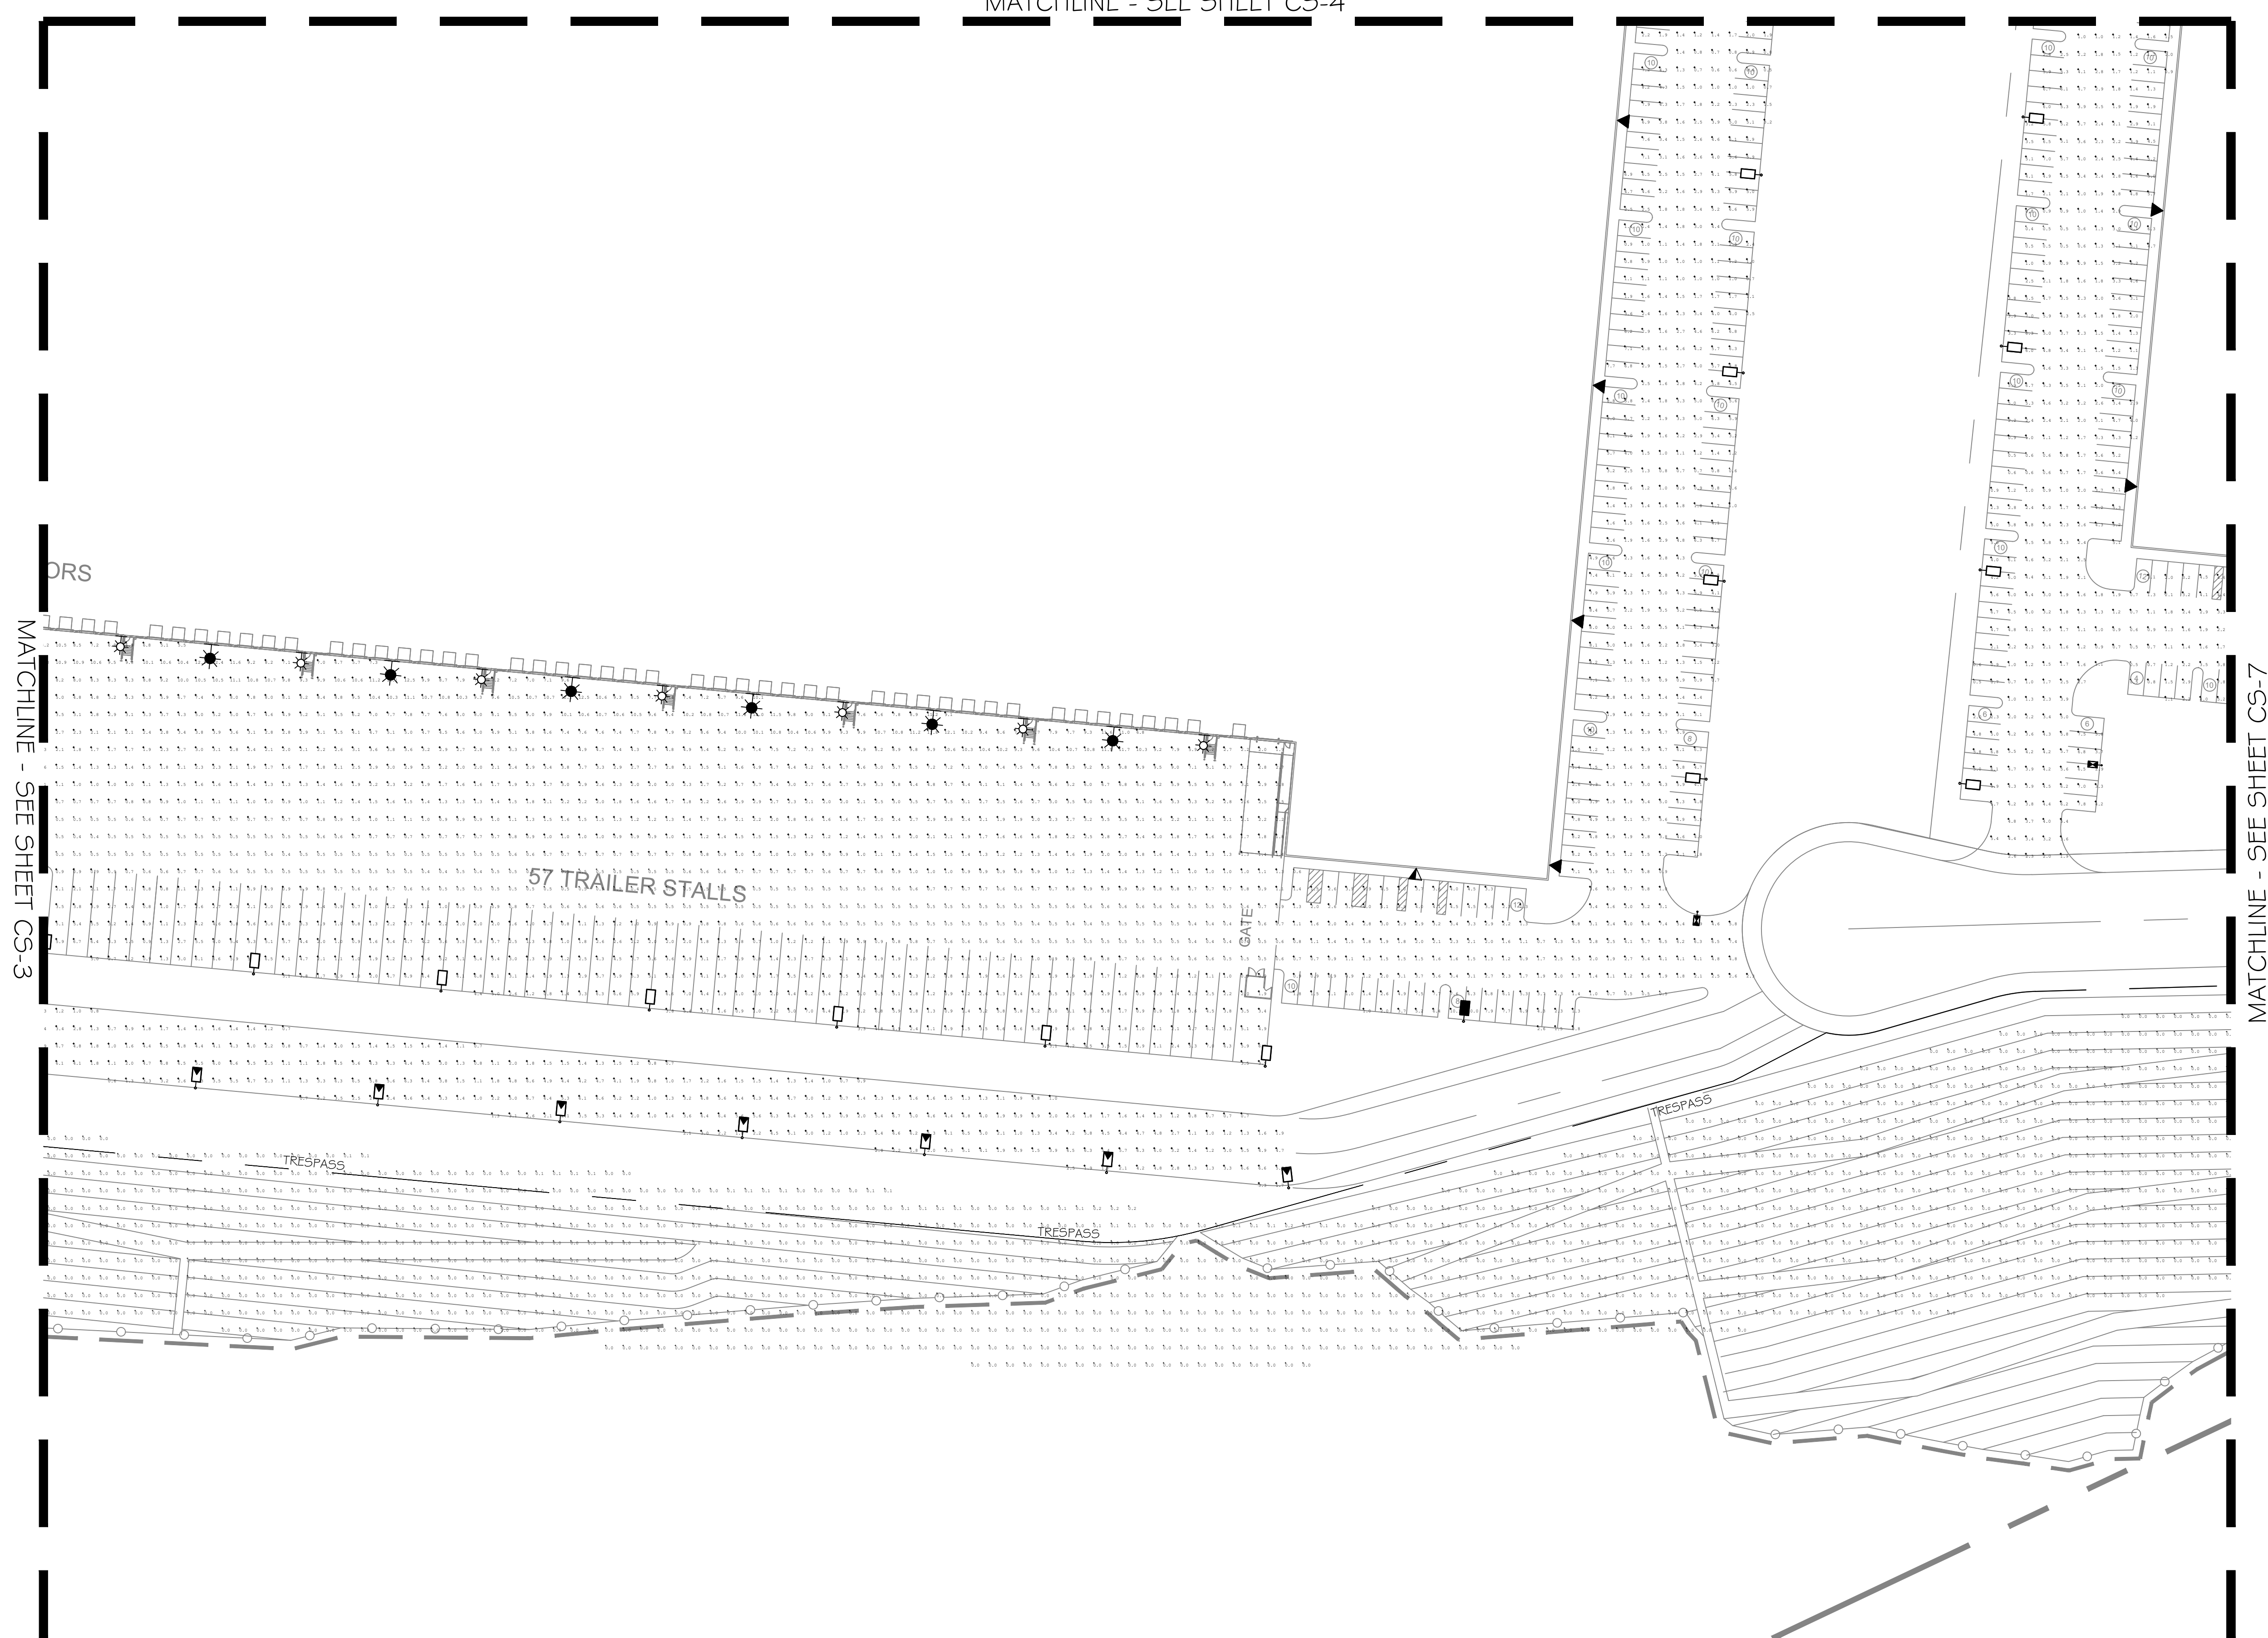


Luminaire Schedule										Calculation Summary							
Symbol	Qty	Tag	Label	Arrangement	Lum. Lumens	BUG Rating	LLF	Description	Wattage	Label	CalcType	Units	Avg	Max	Min	Avg/Min	Max/Min
✱	115		HUBBELL - AIRO MICRO STRIKE	SINGLE	32152	B3-U0-G5	0.900	ASL2-320L-235-4K7-4W-U @ 39'	235	BLDG1	Illuminance	Fc	3.03	14.0	0.2	15.15	70.00
✱	115		HUBBELL - AIRO MICRO STRIKE	SINGLE	32796	B3-U0-G4	0.900	ASL2-320L-235-4K7-2-U @ 39'	235	BLDG2	Illuminance	Fc	3.04	13.8	0.3	10.13	46.00
▽	30		HUBBELL - AIRO MICRO STRIKE	SINGLE	23853	B3-U0-G4	0.900	ASL2-320L-170-4K7-4W-U @ 25'	168	BLDG3	Illuminance	Fc	3.37	13.5	0.3	11.23	45.00
▽	29		HUBBELL - AIRO MICRO STRIKE	SINGLE	24139	B3-U0-G4	0.900	ASL2-320L-170-4K7-3-U @ 25'	168	BLDG4	Illuminance	Fc	3.26	14.6	0.2	16.30	73.00
▽	20		HUBBELL - AIRO MICRO STRIKE	SINGLE	24330	B3-U0-G3	0.900	ASL2-320L-170-4K7-2-U @ 25'	168	BLDG5	Illuminance	Fc	3.12	14.2	0.3	10.40	47.33
□	32		HUBBELL - AIRO MICRO STRIKE	SINGLE	23853	B1-U0-G2	0.900	ASL2-320L-170-4K7-4W-BC @ 20'	168	RETAIL SITE	Illuminance	Fc	3.64	12.2	0.7	5.20	17.43
□	174		HUBBELL - AIRO MICRO STRIKE	SINGLE	23853	B3-U0-G4	0.900	ASL2-320L-170-4K7-4W-U @ 20'	168	TRSPASS	Illuminance	Fc	0.00	0.7	0.0	N.A.	N.A.
□	8		HUBBELL - AIRO MICRO STRIKE	SINGLE	24139	B1-U0-G2	0.900	ASL2-320L-170-4K7-3-BC @ 20'	168								
□	23		HUBBELL - AIRO MICRO STRIKE	SINGLE	24139	B3-U0-G4	0.900	ASL2-320L-170-4K7-3-U @ 20'	168								
□	5		HUBBELL - AIRO MICRO STRIKE	SINGLE	24330	B1-U0-G2	0.900	ASL2-320L-170-4K7-2-BC @ 20'	168								
□	28		HUBBELL - AIRO MICRO STRIKE	SINGLE	24330	B3-U0-G3	0.900	ASL2-320L-170-4K7-2-U @ 20'	168								
□	3		HUBBELL - AIRO MICRO STRIKE	2 @ 90 DEGREES	23853	B3-U0-G4	0.900	ASL2-320L-170-4K7-4W-U @ 20'	168								
□	44		HUBBELL - AIRO MICRO STRIKE	BACK-BACK	23853	B3-U0-G4	0.900	ASL2-320L-170-4K7-4W-U @ 20'	168								

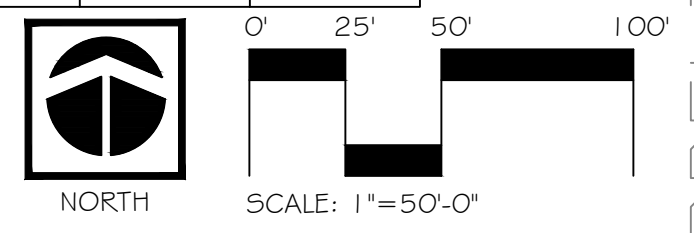

MATCHLINE - SEE SHEET CS-3

MATCHLINE - SEE SHEET CS-7

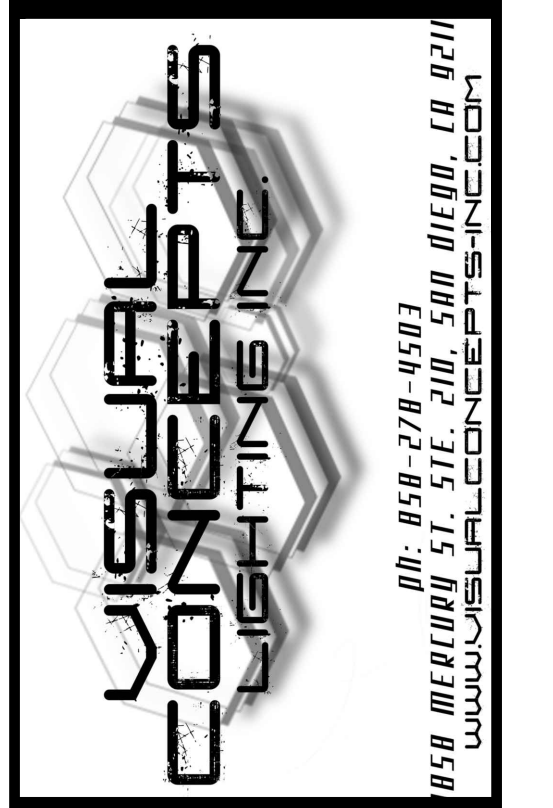

Project:  
BEAUMONT POINTE  
SITE LIGHTS  
BEAUMONT, CA.

Client:  
JRT PBI, LLC  
18032 LEMON DE. STE. 367  
YORBA LINDA, CA 92886



Revisions:


Sheet Info:  
Drawn By: AZ  
Checked By: KPJR  
Scale: 1"=50'-0"  
Date: 2/18/2021  
Job No.: JRT21/02011

Sheet Title:  
CONCEPTUAL  
SHEET 5

Sheet Reference:


CS-5  
Sheet: 5 of 19

PRELIMINARY - NOT FOR CONSTRUCTION


Luminaire Schedule										Calculation Summary							
Symbol	Qty	Tag	Label	Arrangement	Lum. Lumens	BUG Rating	LLF	Description	Wattage	Label	CalcType	Units	Avg	Max	Min	Avg/Min	Max/Min
☼	115	WALL LIGHT	HUBBELL - AIRO MICRO STRIKE	SINGLE	32152	B3-U0-G5	0.900	ASL2-320L-235-4K7-4W-U @ 39'	235	BLDG1	ILLUMINANCE	Fc	3.03	14.0	0.2	15.15	70.00
☼	115	WALL LIGHT	HUBBELL - AIRO MICRO STRIKE	SINGLE	32796	B3-U0-G4	0.900	ASL2-320L-235-4K7-2-U @ 39'	235	BLDG2	ILLUMINANCE	Fc	3.04	13.8	0.3	10.13	46.00
▽	30	WALL LIGHT	HUBBELL - AIRO MICRO STRIKE	SINGLE	23853	B3-U0-G4	0.900	ASL2-320L-170-4K7-4W-U @ 25'	168	BLDG3	ILLUMINANCE	Fc	3.37	13.5	0.3	11.23	45.00
▽	29	WALL LIGHT	HUBBELL - AIRO MICRO STRIKE	SINGLE	24139	B3-U0-G4	0.900	ASL2-320L-170-4K7-3-U @ 25'	168	BLDG4	ILLUMINANCE	Fc	3.26	14.6	0.2	16.30	73.00
▽	20	WALL LIGHT	HUBBELL - AIRO MICRO STRIKE	SINGLE	24330	B3-U0-G3	0.900	ASL2-320L-170-4K7-2-U @ 25'	168	BLDG5	ILLUMINANCE	Fc	3.12	14.2	0.3	10.40	47.33
☼	32	POLE LIGHT	HUBBELL - AIRO MICRO STRIKE	SINGLE	23853	B1-U0-G2	0.900	ASL2-320L-170-4K7-4W-BC @ 20'	168	RETAIL SITE	ILLUMINANCE	Fc	3.64	12.2	0.7	5.20	17.43
☼	174	POLE LIGHT	HUBBELL - AIRO MICRO STRIKE	SINGLE	23853	B3-U0-G4	0.900	ASL2-320L-170-4K7-4W-U @ 20'	168	TRESPASS	ILLUMINANCE	Fc	0.00	0.7	0.0	N.A.	N.A.
☼	8	POLE LIGHT	HUBBELL - AIRO MICRO STRIKE	SINGLE	24139	B1-U0-G2	0.900	ASL2-320L-170-4K7-3-BC @ 20'	168								
☼	23	POLE LIGHT	HUBBELL - AIRO MICRO STRIKE	SINGLE	24139	B3-U0-G4	0.900	ASL2-320L-170-4K7-3-U @ 20'	168								
☼	5	POLE LIGHT	HUBBELL - AIRO MICRO STRIKE	SINGLE	24330	B1-U0-G2	0.900	ASL2-320L-170-4K7-2-BC @ 20'	168								
☼	28	POLE LIGHT	HUBBELL - AIRO MICRO STRIKE	SINGLE	24330	B3-U0-G3	0.900	ASL2-320L-170-4K7-2-U @ 20'	168								
☼	3	POLE LIGHT DBL	HUBBELL - AIRO MICRO STRIKE	2 @ 90 DEGREES	23853	B3-U0-G4	0.900	ASL2-320L-170-4K7-4W-U @ 20'	168								
☼	44	POLE LIGHT DBL	HUBBELL - AIRO MICRO STRIKE	BACK-BACK	23853	B3-U0-G4	0.900	ASL2-320L-170-4K7-4W-U @ 20'	168								



MATCHLINE - SEE SHEET CS-7

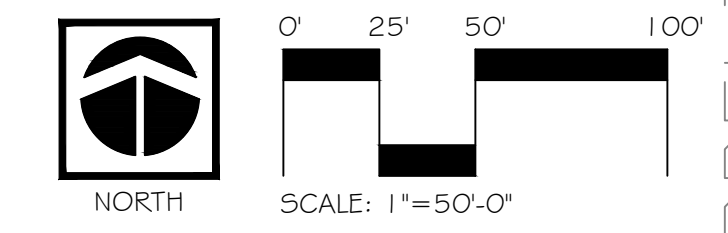

PRELIMINARY - NOT FOR CONSTRUCTION

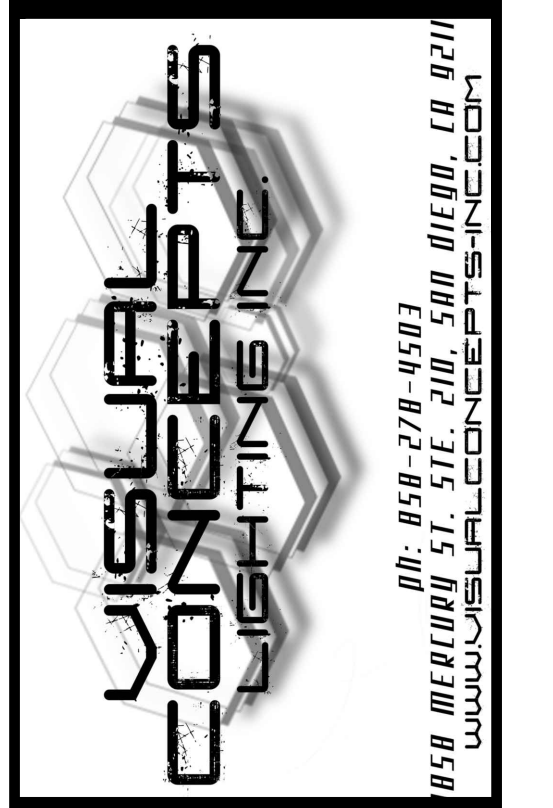

Project:  
BEAUMONT POINTE  
SITE LIGHTS  
BEAUMONT, CA.

Client:  
JRT PBI, LLC  
18032 LEMON DE. STE. 367  
YORBA LINDA, CA 92886



Revisions:

Sheet Info:  
Drawn By: AZ  
Checked By: KPJR  
Scale: 1"= 50'-0"  
Date: 2/18/2021  
Job No.: JRT21/02011

Sheet Title:  
CONCEPTUAL  
PLAN 6


Sheet Reference:

CS-6  
Sheet: 6 of 19


MATCHLINE - SEE SHEET CS-6

MATCHLINE - SEE SHEET CS-5


MATCHLINE - SEE SHEET CS-9

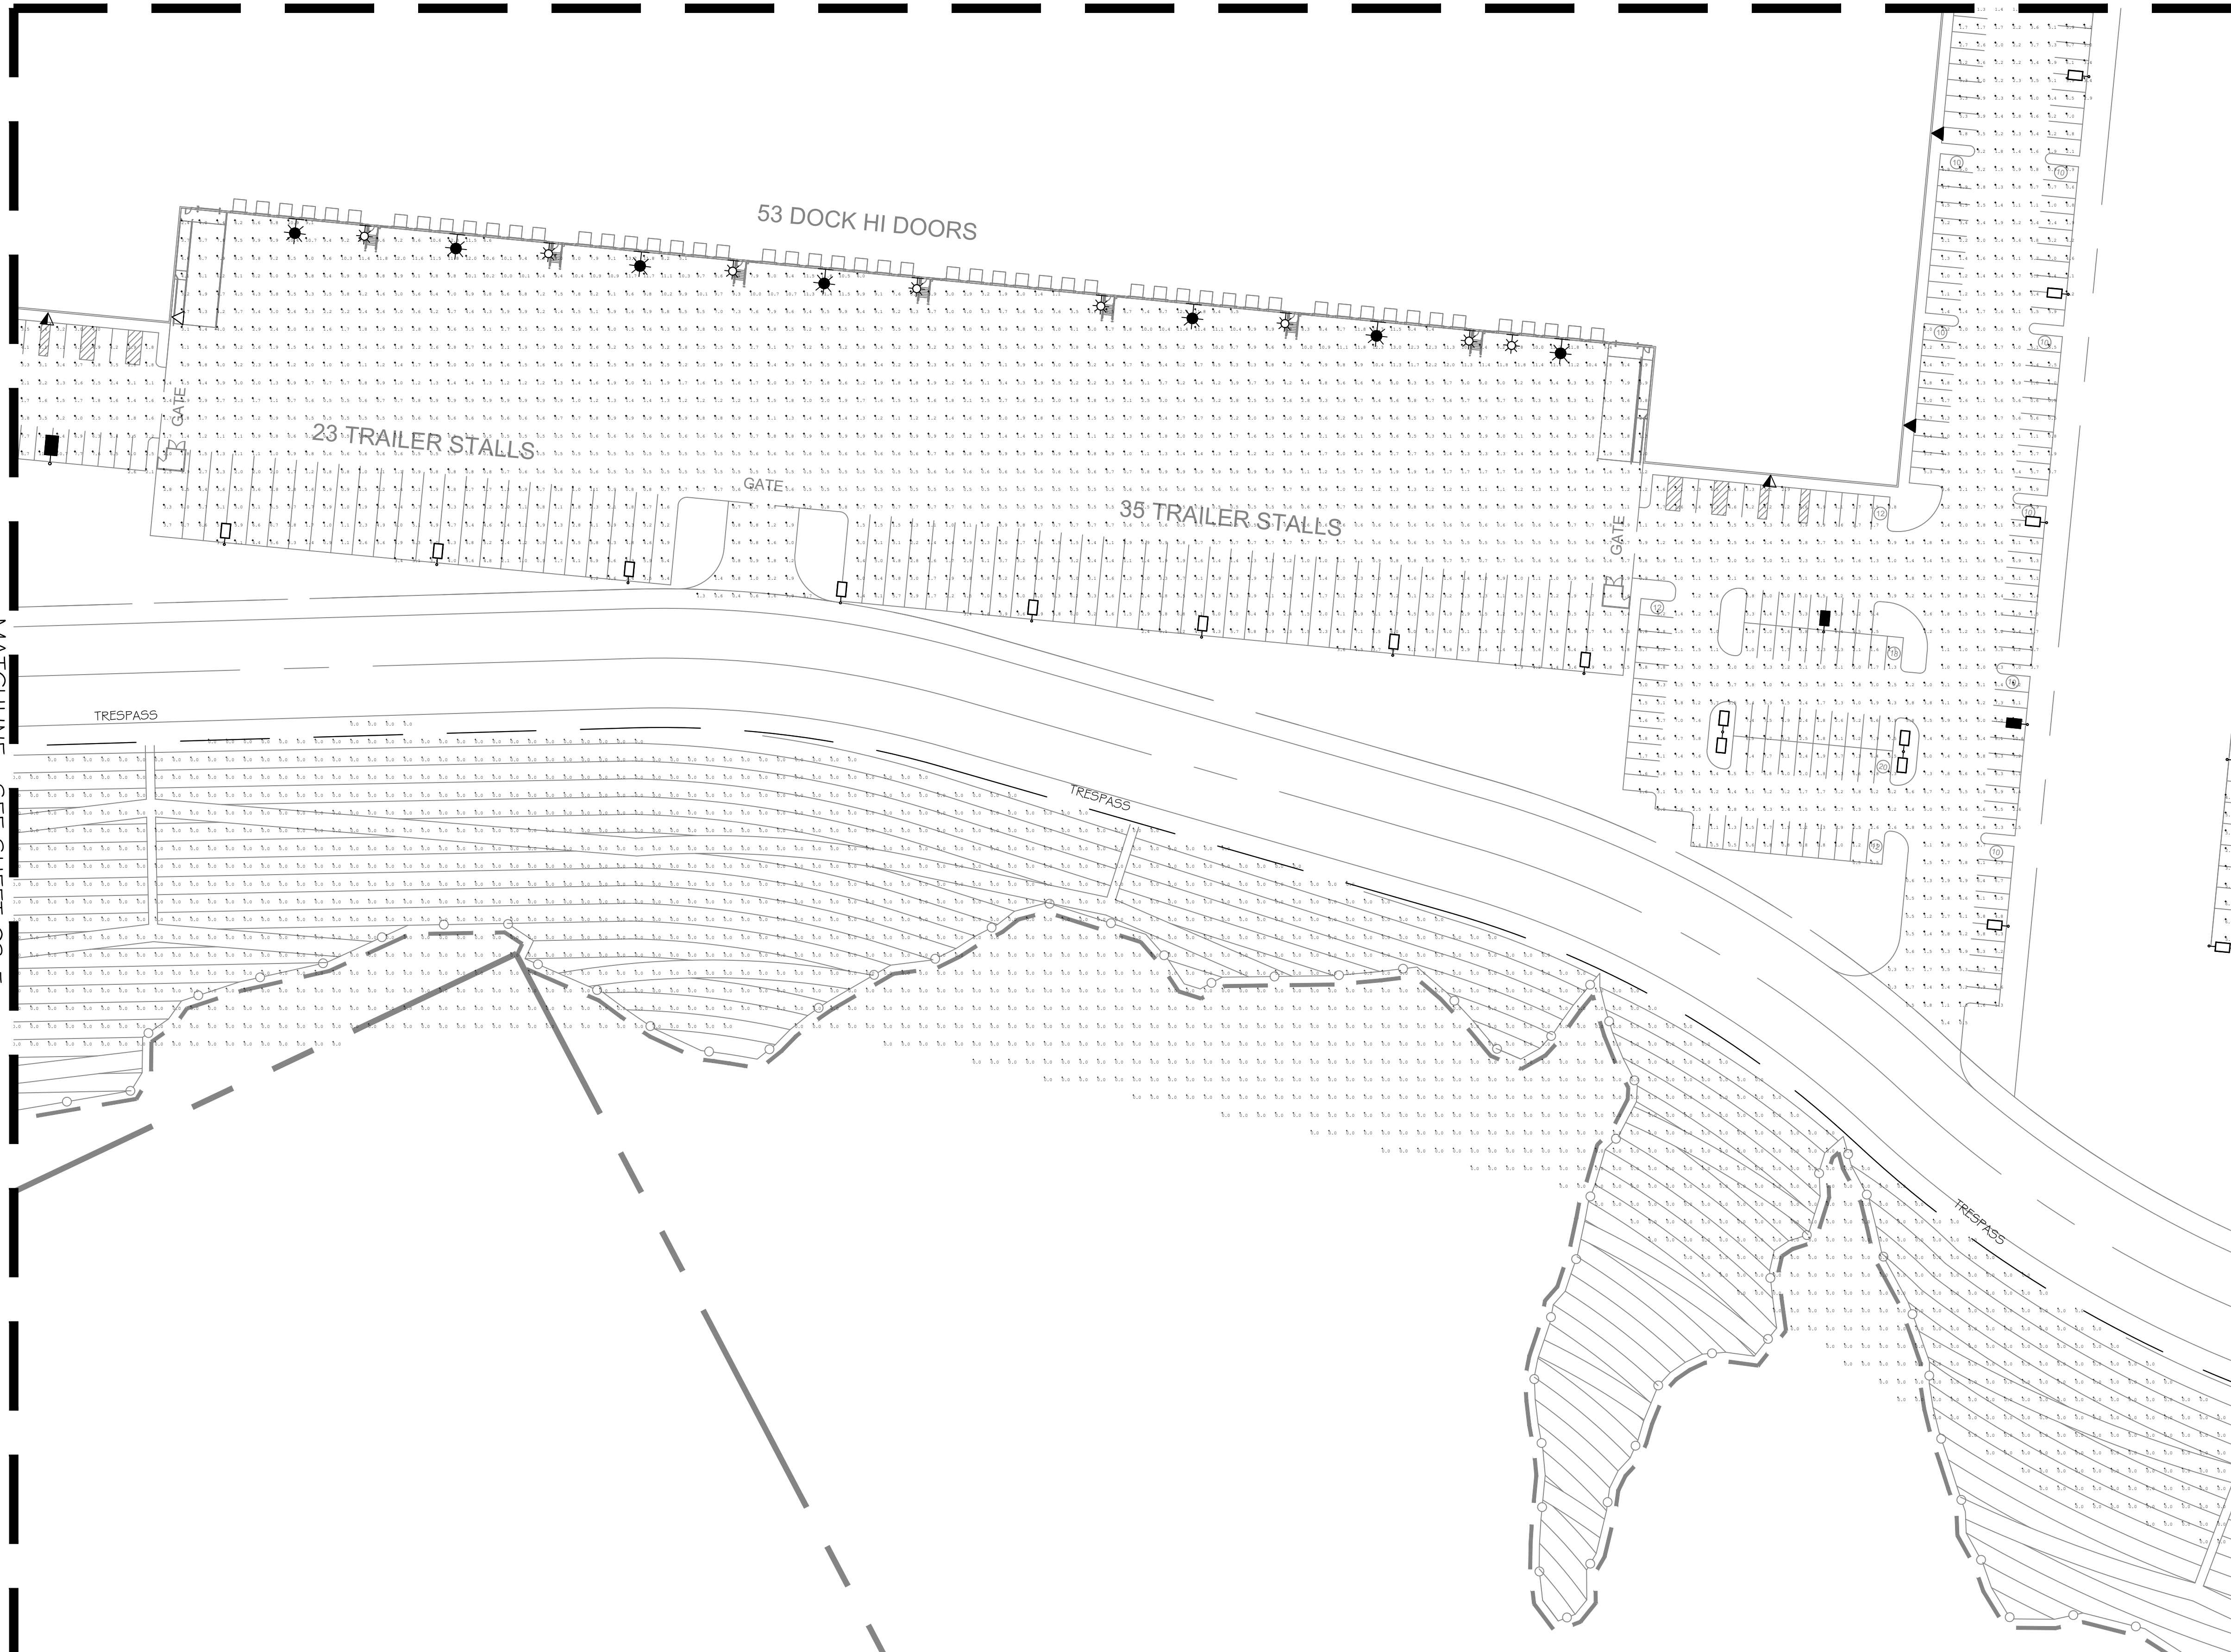

Luminaire Schedule										Calculation Summary							
Symbol	Qty	Tag	Label	Arrangement	Lum. Lumens	BUG Rating	LLF	Description	Wattage	Label	CalcType	Units	Avg	Max	Min	Avg/Min	Max/Min
☒	115		WALL LIGHT	HUBBELL - AIRO MICRO STRIKE	SINGLE	32152	0.900	B3-U0-G5 ASL2-320L-235-4K7-4W-U @ 39'	235	BLDG1	Illuminance	Fc	3.03	14.0	0.2	15.15	70.00
☒	115		WALL LIGHT	HUBBELL - AIRO MICRO STRIKE	SINGLE	32796	0.900	B3-U0-G4 ASL2-320L-235-4K7-2-U @ 39'	235	BLDG2	Illuminance	Fc	3.04	13.8	0.3	10.13	46.00
▽	30		WALL LIGHT	HUBBELL - AIRO MICRO STRIKE	SINGLE	23853	0.900	B3-U0-G4 ASL2-320L-170-4K7-4W-U @ 25'	168	BLDG3	Illuminance	Fc	3.37	13.5	0.3	11.23	45.00
▽	29		WALL LIGHT	HUBBELL - AIRO MICRO STRIKE	SINGLE	24139	0.900	B3-U0-G4 ASL2-320L-170-4K7-3-U @ 25'	168	BLDG4	Illuminance	Fc	3.26	14.6	0.2	16.30	73.00
▽	20		WALL LIGHT	HUBBELL - AIRO MICRO STRIKE	SINGLE	24330	0.900	B3-U0-G3 ASL2-320L-170-4K7-2-U @ 25'	168	BLDG5	Illuminance	Fc	3.12	14.2	0.3	10.40	47.33
☐	32		POLE LIGHT	HUBBELL - AIRO MICRO STRIKE	SINGLE	23853	0.900	B1-U0-G2 ASL2-320L-170-4K7-4W-BC @ 20'	168	RETAIL SITE	Illuminance	Fc	3.64	12.2	0.7	5.20	17.43
☐	174		POLE LIGHT	HUBBELL - AIRO MICRO STRIKE	SINGLE	23853	0.900	B3-U0-G4 ASL2-320L-170-4K7-4W-U @ 20'	168	TRESPASS	Illuminance	Fc	0.00	0.7	0.0	N.A.	N.A.
☐	8		POLE LIGHT	HUBBELL - AIRO MICRO STRIKE	SINGLE	24139	0.900	B1-U0-G2 ASL2-320L-170-4K7-3-BC @ 20'	168								
☐	23		POLE LIGHT	HUBBELL - AIRO MICRO STRIKE	SINGLE	24139	0.900	B3-U0-G4 ASL2-320L-170-4K7-3-U @ 20'	168								
☐	5		POLE LIGHT	HUBBELL - AIRO MICRO STRIKE	SINGLE	24330	0.900	B1-U0-G2 ASL2-320L-170-4K7-2-BC @ 20'	168								
☐	28		POLE LIGHT	HUBBELL - AIRO MICRO STRIKE	SINGLE	24330	0.900	B3-U0-G3 ASL2-320L-170-4K7-2-U @ 20'	168								
☐	3		POLE LIGHT DBL	HUBBELL - AIRO MICRO STRIKE	2 @ 90 DEGREES	23853	0.900	B3-U0-G4 ASL2-320L-170-4K7-4W-U @ 20'	168								
☐	44		POLE LIGHT DBL	HUBBELL - AIRO MICRO STRIKE	BACK-BACK	23853	0.900	B3-U0-G4 ASL2-320L-170-4K7-4W-U @ 20'	168								

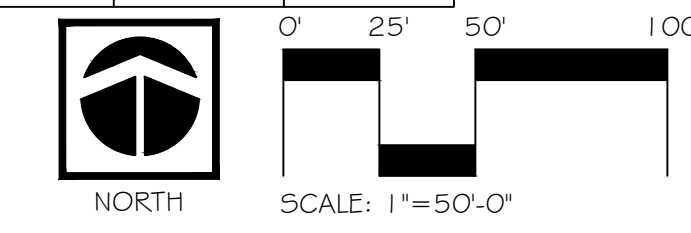

PRELIMINARY - NOT FOR CONSTRUCTION

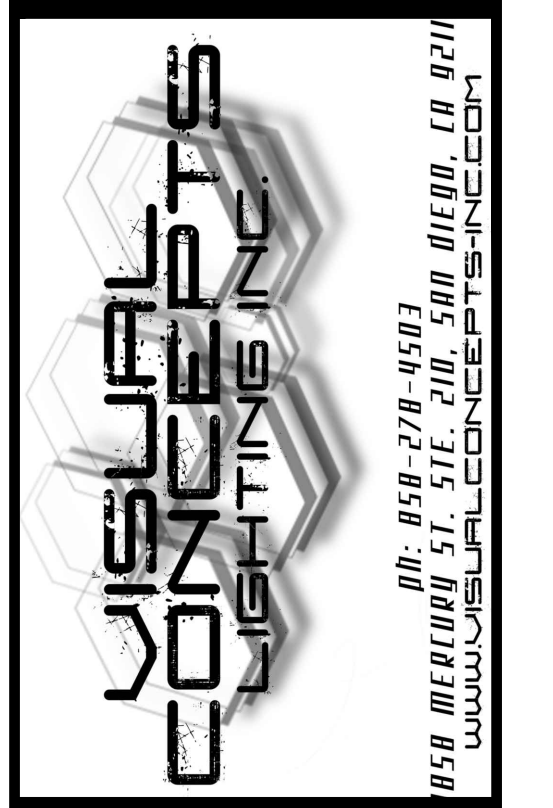

Project:  
BEAUMONT POINTE  
SITE LIGHTS  
BEAUMONT, CA.

Client:  
JRT PBI, LLC  
18032 LEMON DE. STE. 367  
YORBA LINDA, CA 92886



Revisions:



Sheet Info:  
Drawn By: AZ  
Checked By: KPJR  
Scale: 1" = 50'-0"  
Date: 2/18/2021  
Job No.: JRT21/02011

Sheet Title:  
CONCEPTUAL  
PLAN 7

Sheet Reference:


CS-7  
Sheet: 7 of 19

Luminaire Schedule										Calculation Summary							
Symbol	Qty	Tag	Label	Arrangement	Lum. Lumens	BUG Rating	LLF	Description	Wattage	Label	CalcType	Units	Avg	Max	Min	Avg/Min	Max/Min
★	115	WALL LIGHT	HUBBELL - AIRO MICRO STRIKE	SINGLE	32152	B3-U0-G5	0.900	ASL2-320L-235-4K7-4W-U @ 39'	235	BLDG1	Illuminance	Fc	3.03	14.0	0.2	15.15	70.00
★	115	WALL LIGHT	HUBBELL - AIRO MICRO STRIKE	SINGLE	32796	B3-U0-G4	0.900	ASL2-320L-235-4K7-2-U @ 39'	235	BLDG2	Illuminance	Fc	3.04	13.8	0.3	10.13	46.00
▽	30	WALL LIGHT	HUBBELL - AIRO MICRO STRIKE	SINGLE	23853	B3-U0-G4	0.900	ASL2-320L-170-4K7-4W-U @ 25'	168	BLDG3	Illuminance	Fc	3.37	13.5	0.3	11.23	45.00
▽	29	WALL LIGHT	HUBBELL - AIRO MICRO STRIKE	SINGLE	24139	B3-U0-G4	0.900	ASL2-320L-170-4K7-3-U @ 25'	168	BLDG4	Illuminance	Fc	3.26	14.6	0.2	16.30	73.00
▽	20	WALL LIGHT	HUBBELL - AIRO MICRO STRIKE	SINGLE	24330	B3-U0-G3	0.900	ASL2-320L-170-4K7-2-U @ 25'	168	BLDG5	Illuminance	Fc	3.12	14.2	0.3	10.40	47.33
□	32	POLE LIGHT	HUBBELL - AIRO MICRO STRIKE	SINGLE	23853	B1-U0-G2	0.900	ASL2-320L-170-4K7-4W-BC @ 20'	168	RETAIL SITE	Illuminance	Fc	3.64	12.2	0.7	5.20	17.43
□	174	POLE LIGHT	HUBBELL - AIRO MICRO STRIKE	SINGLE	23853	B3-U0-G4	0.900	ASL2-320L-170-4K7-4W-U @ 20'	168	TRESPASS	Illuminance	Fc	0.00	0.7	0.0	N.A.	N.A.
□	8	POLE LIGHT	HUBBELL - AIRO MICRO STRIKE	SINGLE	24139	B1-U0-G2	0.900	ASL2-320L-170-4K7-3-BC @ 20'	168								
□	23	POLE LIGHT	HUBBELL - AIRO MICRO STRIKE	SINGLE	24139	B3-U0-G4	0.900	ASL2-320L-170-4K7-3-U @ 20'	168								
□	5	POLE LIGHT	HUBBELL - AIRO MICRO STRIKE	SINGLE	24330	B1-U0-G2	0.900	ASL2-320L-170-4K7-2-BC @ 20'	168								
□	28	POLE LIGHT	HUBBELL - AIRO MICRO STRIKE	SINGLE	24330	B3-U0-G3	0.900	ASL2-320L-170-4K7-2-U @ 20'	168								
□	3	POLE LIGHT DBL	HUBBELL - AIRO MICRO STRIKE	2 @ 90 DEGREES	23853	B3-U0-G4	0.900	ASL2-320L-170-4K7-4W-U @ 20'	168								
□	44	POLE LIGHT DBL	HUBBELL - AIRO MICRO STRIKE	BACK-BACK	23853	B3-U0-G4	0.900	ASL2-320L-170-4K7-4W-U @ 20'	168								

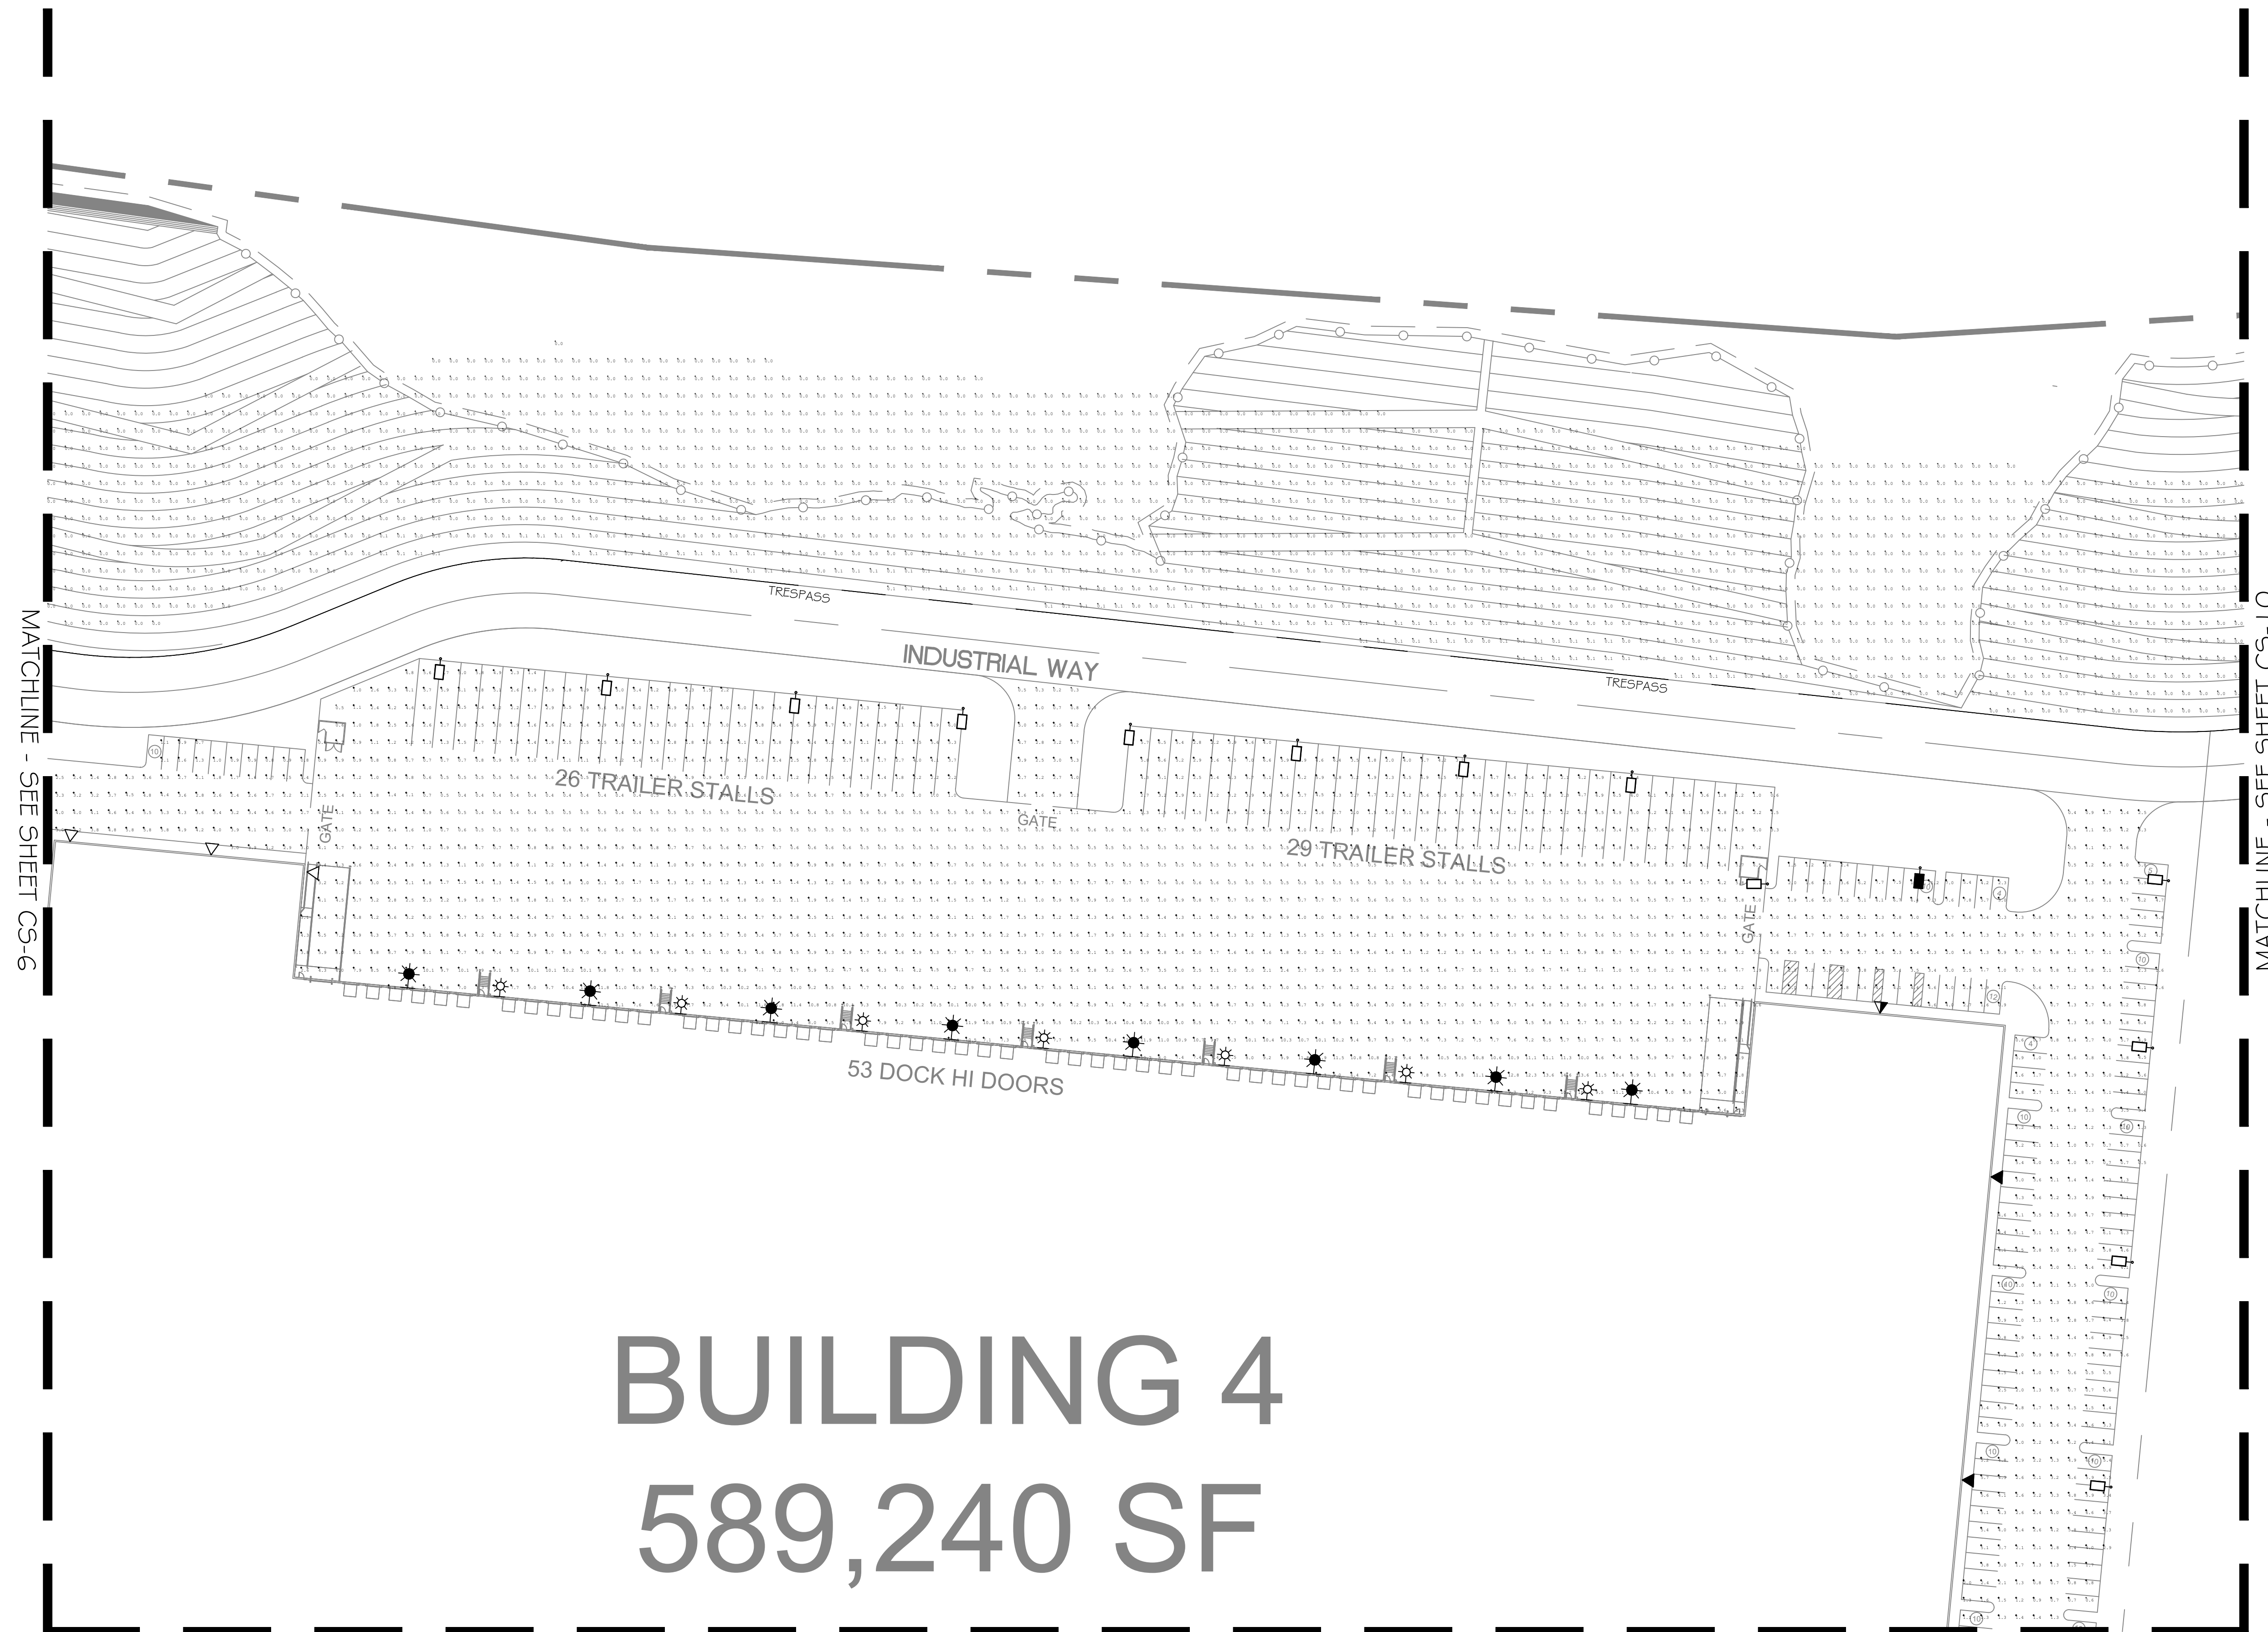


**BUILDING 4**  
**589,240 SF**

MATCHLINE - SEE SHEET CS-9

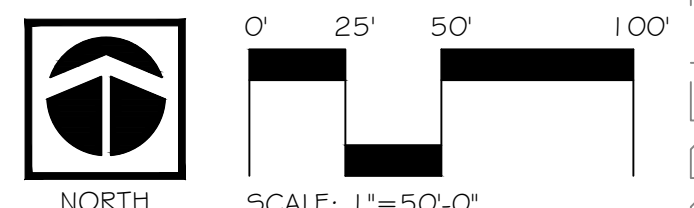

PRELIMINARY - NOT FOR CONSTRUCTION

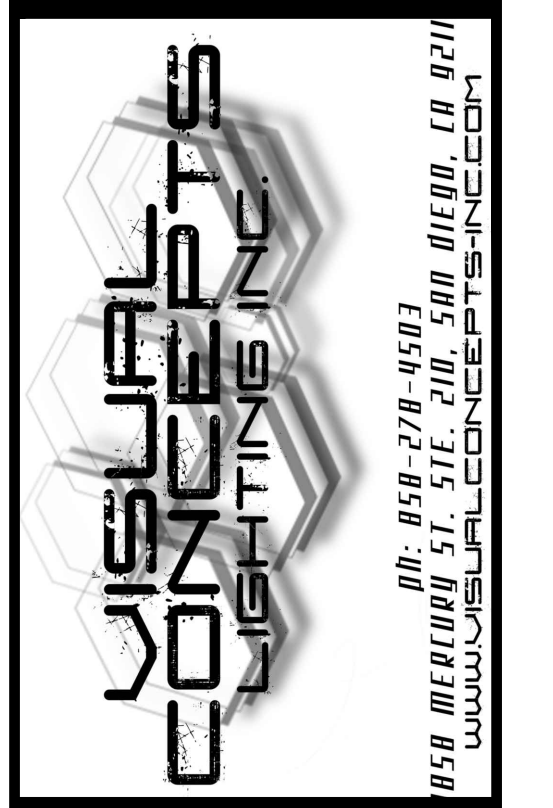

Project:  
BEAUMONT POINTE  
SITE LIGHTS  
BEAUMONT, CA.

Client:  
JRT PBI, LLC  
18032 LEMON DE. STE. 367  
YORBA LINDA, CA 92886



Revisions:

Sheet Info:  
Drawn By: AZ  
Checked By: KPJR  
Scale: 1"=50'-0"  
Date: 2/18/2021  
Job No.: JRT21/02011

Sheet Title:  
CONCEPTUAL  
PLAN 8

Sheet Reference:


**CS-8**  
Sheet: 8 of 19




MATCHLINE - SEE SHEET CS-8

# 675,400 SF


MATCHLINE - SEE SHEET CS-7

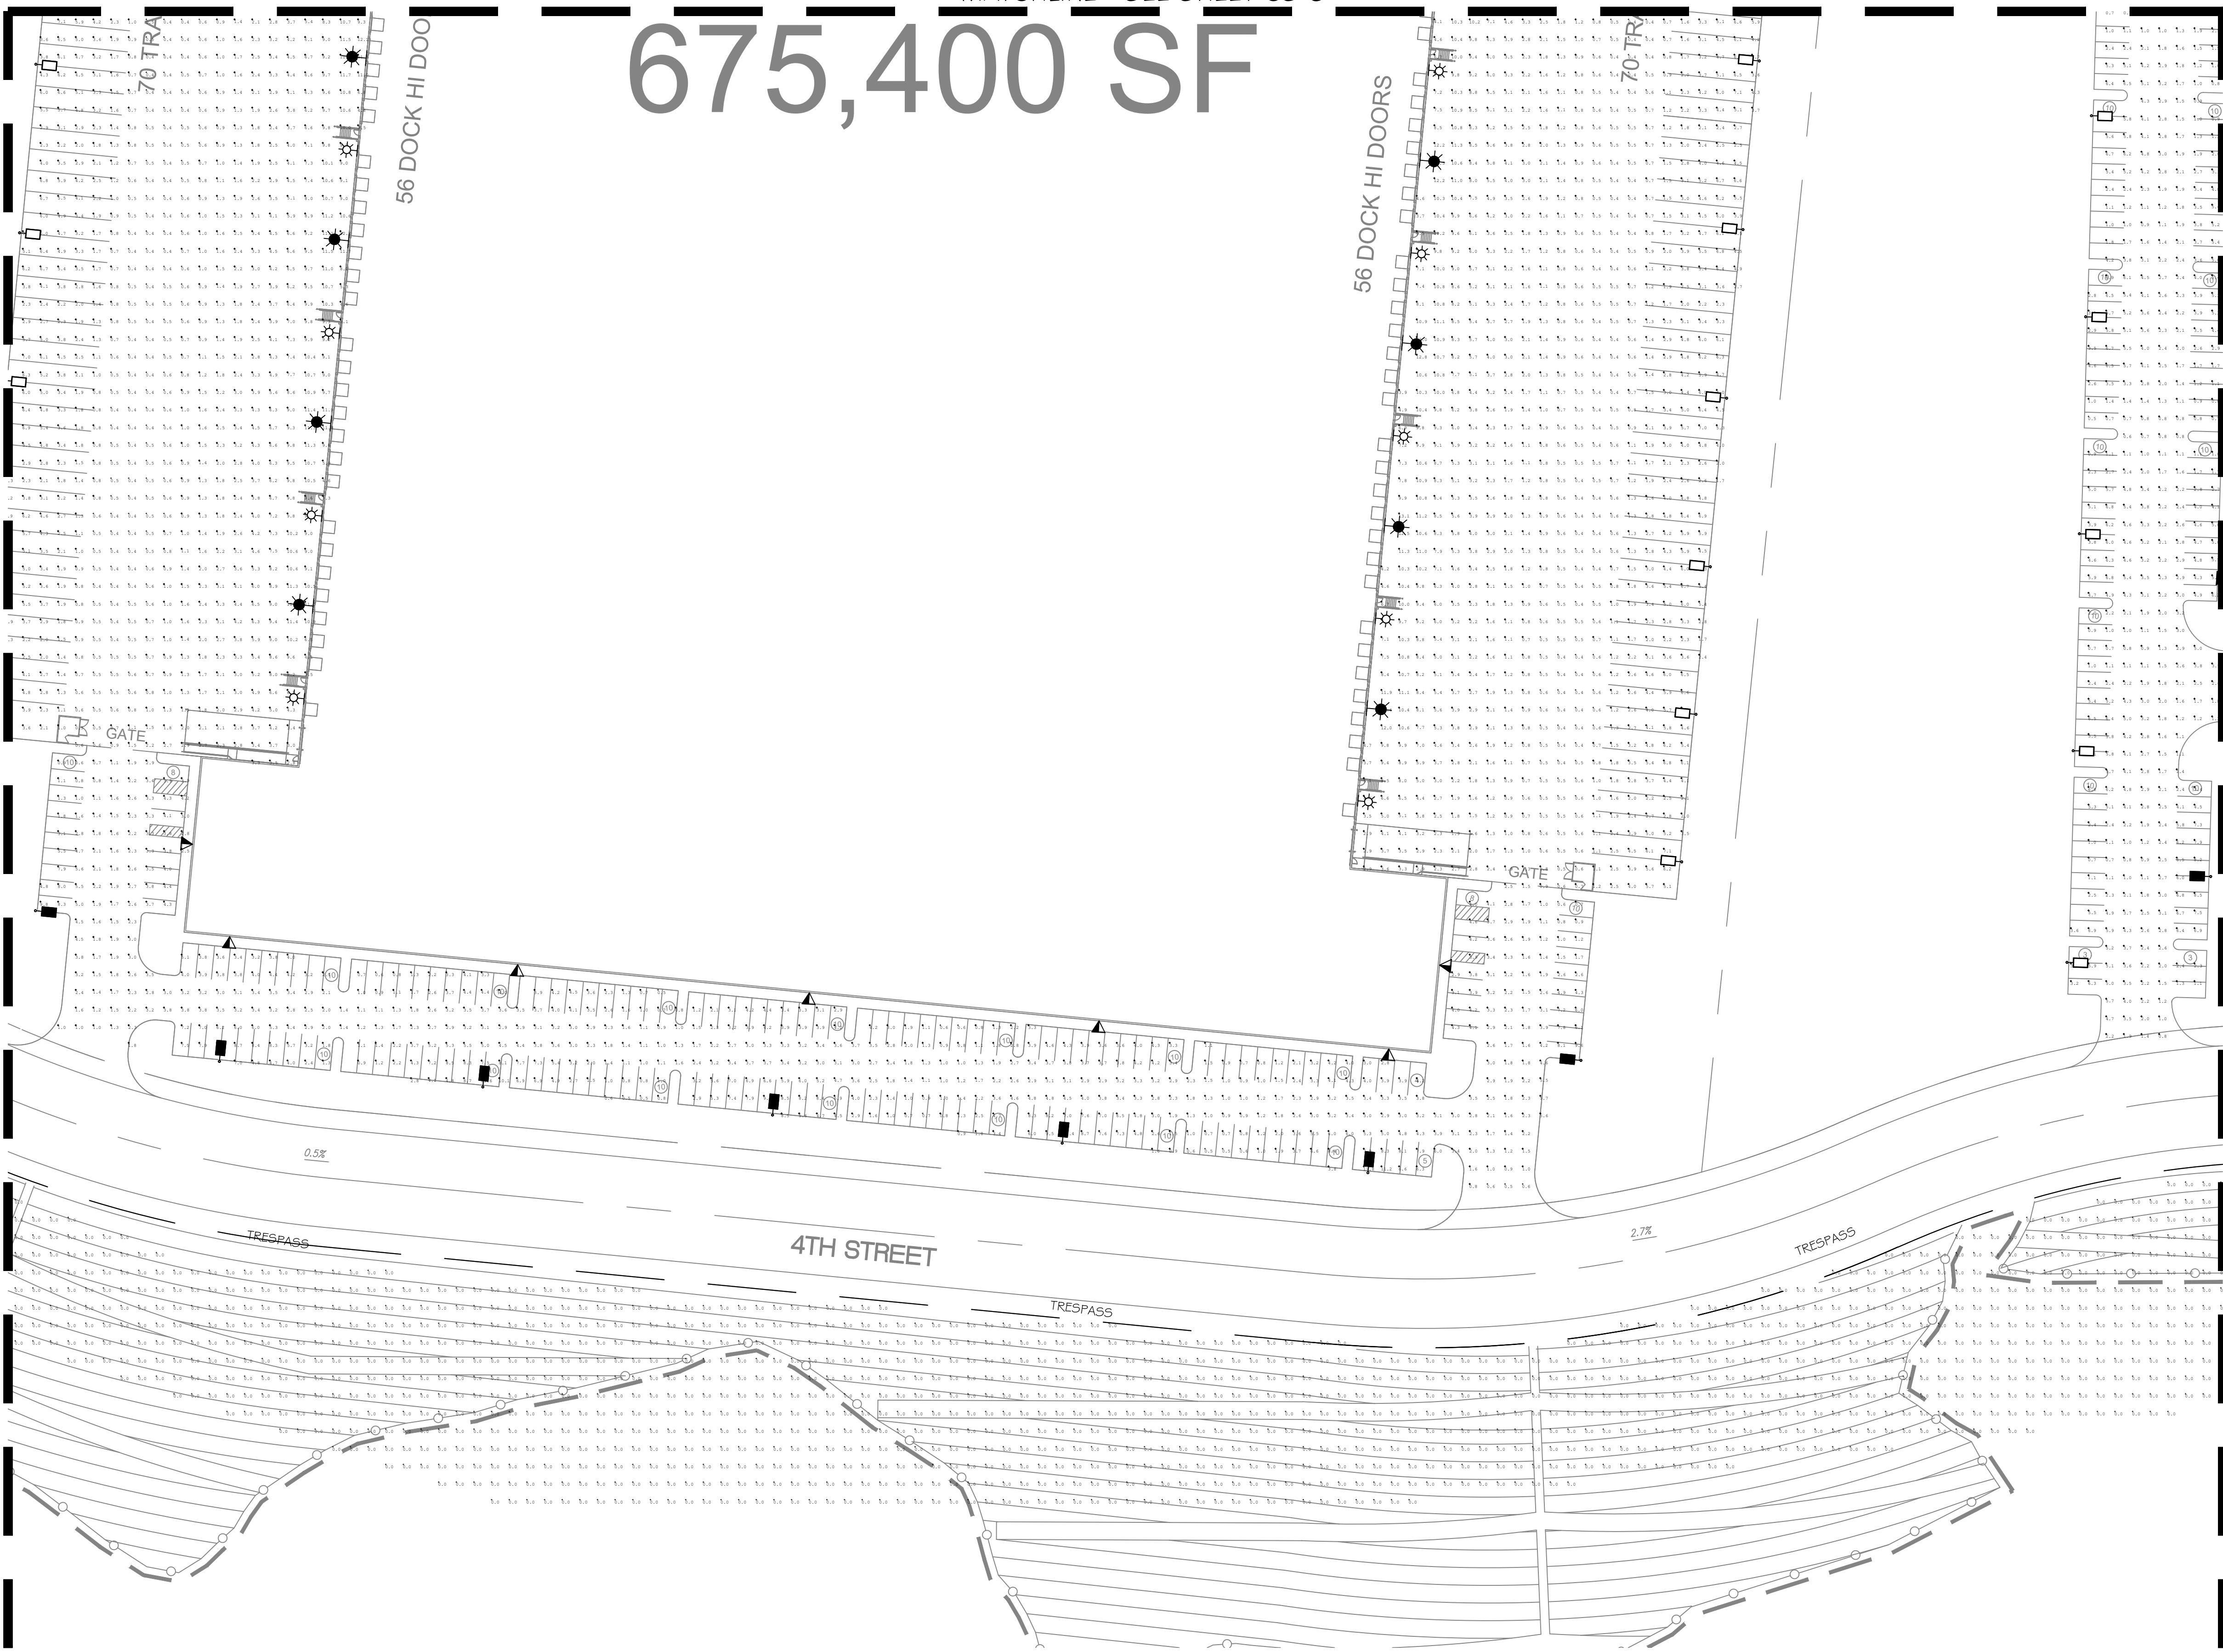

Luminaire Schedule										Calculation Summary							
Symbol	Qty	Tag	Label	Arrangement	Lum. Lumens	BUG Rating	LLF	Description	Wattage	Label	CalcType	Units	Avg	Max	Min	Avg/Min	Max/Min
☼	115	WALL LIGHT	HUBBELL - AIRO MICRO STRIKE	SINGLE	32152	B3-U0-G5	0.900	ASL2-320L-235-4K7-4W-U @ 39'	235	BLDG1	Illuminance	Fc	3.03	14.0	0.2	15.15	70.00
☼	115	WALL LIGHT	HUBBELL - AIRO MICRO STRIKE	SINGLE	32796	B3-U0-G4	0.900	ASL2-320L-235-4K7-2-U @ 39'	235	BLDG2	Illuminance	Fc	3.04	13.8	0.3	10.13	46.00
▽	30	WALL LIGHT	HUBBELL - AIRO MICRO STRIKE	SINGLE	23853	B3-U0-G4	0.900	ASL2-320L-170-4K7-4W-U @ 25'	168	BLDG3	Illuminance	Fc	3.37	13.5	0.3	11.23	45.00
▽	29	WALL LIGHT	HUBBELL - AIRO MICRO STRIKE	SINGLE	24139	B3-U0-G4	0.900	ASL2-320L-170-4K7-3-U @ 25'	168	BLDG4	Illuminance	Fc	3.26	14.6	0.2	16.30	73.00
▽	20	WALL LIGHT	HUBBELL - AIRO MICRO STRIKE	SINGLE	24330	B3-U0-G3	0.900	ASL2-320L-170-4K7-2-U @ 25'	168	BLDG5	Illuminance	Fc	3.12	14.2	0.3	10.40	47.33
☼	32	POLE LIGHT	HUBBELL - AIRO MICRO STRIKE	SINGLE	23853	B1-U0-G2	0.900	ASL2-320L-170-4K7-4W-BC @ 20'	168	RETAIL SITE	Illuminance	Fc	3.64	12.2	0.7	5.20	17.43
☼	174	POLE LIGHT	HUBBELL - AIRO MICRO STRIKE	SINGLE	23853	B3-U0-G4	0.900	ASL2-320L-170-4K7-4W-U @ 20'	168	TRESPASS	Illuminance	Fc	0.00	0.7	0.0	N.A.	N.A.
☼	8	POLE LIGHT	HUBBELL - AIRO MICRO STRIKE	SINGLE	24139	B1-U0-G2	0.900	ASL2-320L-170-4K7-3-BC @ 20'	168								
☼	23	POLE LIGHT	HUBBELL - AIRO MICRO STRIKE	SINGLE	24139	B3-U0-G4	0.900	ASL2-320L-170-4K7-3-U @ 20'	168								
☼	5	POLE LIGHT	HUBBELL - AIRO MICRO STRIKE	SINGLE	24330	B1-U0-G2	0.900	ASL2-320L-170-4K7-2-BC @ 20'	168								
☼	28	POLE LIGHT	HUBBELL - AIRO MICRO STRIKE	SINGLE	24330	B3-U0-G3	0.900	ASL2-320L-170-4K7-2-U @ 20'	168								
☼	3	POLE LIGHT DBL	HUBBELL - AIRO MICRO STRIKE	2 @ 90 DEGREES	23853	B3-U0-G4	0.900	ASL2-320L-170-4K7-4W-U @ 20'	168								
☼	44	POLE LIGHT DBL	HUBBELL - AIRO MICRO STRIKE	BACK-BACK	23853	B3-U0-G4	0.900	ASL2-320L-170-4K7-4W-U @ 20'	168								

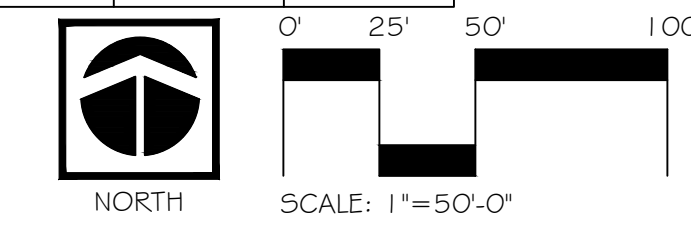

PRELIMINARY - NOT FOR CONSTRUCTION

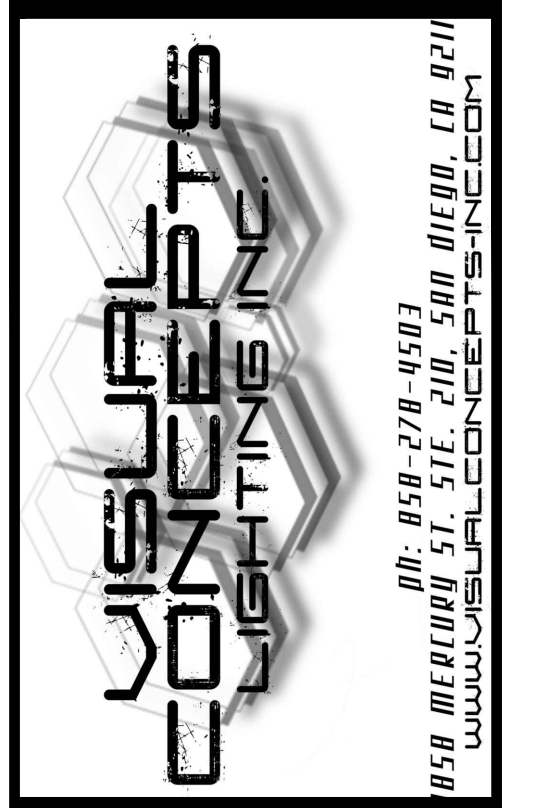

Project:  
BEAUMONT POINTE  
SITE LIGHTS  
BEAUMONT, CA.

Client:  
JRT PBI, LLC  
18032 LEMON DE. STE. 367  
YORBA LINDA, CA 92886



Revisions:

Sheet Info:  
Drawn By: AZ  
Checked By: KPJR  
Scale: 1"=50'-0"  
Date: 2/18/2021  
Job No.: JRT21/02011




Sheet Title:  
CONCEPTUAL  
SHEET 9

Sheet Reference:

CS-9  
Sheet: 9 of 19

Luminaire Schedule									
Symbol	Qty	Tag	Label	Arrangement	Lum. Lumens	BUG Rating	LLF	Description	Wattage
☼	115	WALL LIGHT	HUBBELL - AIRO MICRO STRIKE	SINGLE	32152	B3-U0-G5	0.900	ASL2-320L-235-4K7-4W-U @ 39'	235
☼	115	WALL LIGHT	HUBBELL - AIRO MICRO STRIKE	SINGLE	32796	B3-U0-G4	0.900	ASL2-320L-235-4K7-2-U @ 39'	235
▽	30	WALL LIGHT	HUBBELL - AIRO MICRO STRIKE	SINGLE	23853	B3-U0-G4	0.900	ASL2-320L-170-4K7-4W-U @ 25'	168
▽	29	WALL LIGHT	HUBBELL - AIRO MICRO STRIKE	SINGLE	24139	B3-U0-G4	0.900	ASL2-320L-170-4K7-3-U @ 25'	168
▽	20	WALL LIGHT	HUBBELL - AIRO MICRO STRIKE	SINGLE	24330	B3-U0-G3	0.900	ASL2-320L-170-4K7-2-U @ 25'	168
☼	32	POLE LIGHT	HUBBELL - AIRO MICRO STRIKE	SINGLE	23853	B1-U0-G2	0.900	ASL2-320L-170-4K7-4W-BC @ 20'	168
☼	174	POLE LIGHT	HUBBELL - AIRO MICRO STRIKE	SINGLE	23853	B3-U0-G4	0.900	ASL2-320L-170-4K7-4W-U @ 20'	168
☼	8	POLE LIGHT	HUBBELL - AIRO MICRO STRIKE	SINGLE	24139	B1-U0-G2	0.900	ASL2-320L-170-4K7-3-BC @ 20'	168
☼	23	POLE LIGHT	HUBBELL - AIRO MICRO STRIKE	SINGLE	24139	B3-U0-G4	0.900	ASL2-320L-170-4K7-3-U @ 20'	168
☼	5	POLE LIGHT	HUBBELL - AIRO MICRO STRIKE	SINGLE	24330	B1-U0-G2	0.900	ASL2-320L-170-4K7-2-BC @ 20'	168
☼	28	POLE LIGHT	HUBBELL - AIRO MICRO STRIKE	SINGLE	24330	B3-U0-G3	0.900	ASL2-320L-170-4K7-2-U @ 20'	168
☼	3	POLE LIGHT DBL	HUBBELL - AIRO MICRO STRIKE	2 @ 90 DEGREES	23853	B3-U0-G4	0.900	ASL2-320L-170-4K7-4W-U @ 20'	168
☼	44	POLE LIGHT DBL	HUBBELL - AIRO MICRO STRIKE	BACK-BACK	23853	B3-U0-G4	0.900	ASL2-320L-170-4K7-4W-U @ 20'	168

Calculation Summary									
Label	CalcType	Units	Avg	Max	Min	Avg/Min	Max/Min		
BLDG1	Illuminance	Fc	3.03	14.0	0.2	15.15	70.00		
BLDG2	Illuminance	Fc	3.04	13.8	0.3	10.13	46.00		
BLDG3	Illuminance	Fc	3.37	13.5	0.3	11.23	45.00		
BLDG4	Illuminance	Fc	3.26	14.6	0.2	16.30	73.00		
BLDG5	Illuminance	Fc	3.12	14.2	0.3	10.40	47.33		
RETAIL SITE	Illuminance	Fc	3.64	12.2	0.7	5.20	17.43		
TRESPASS	Illuminance	Fc	0.00	0.7	0.0	N.A.	N.A.		

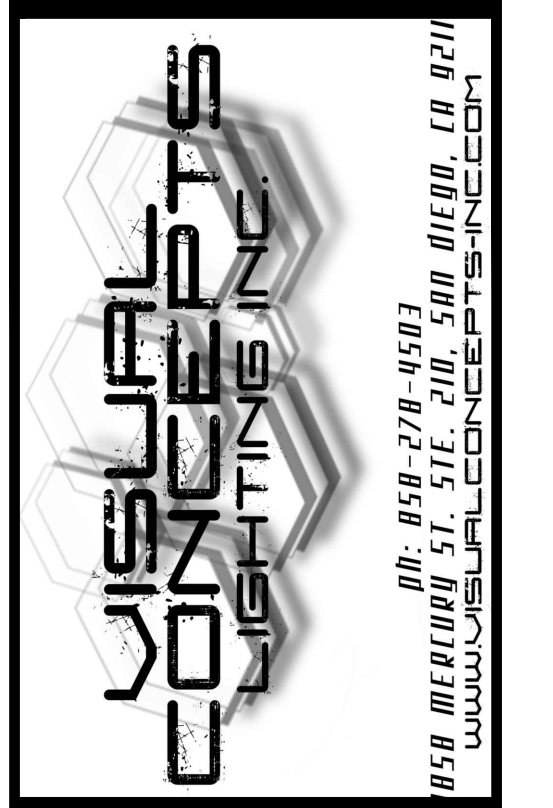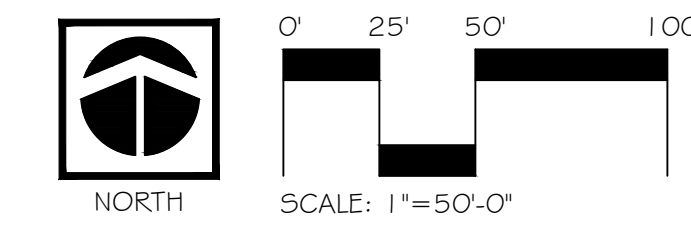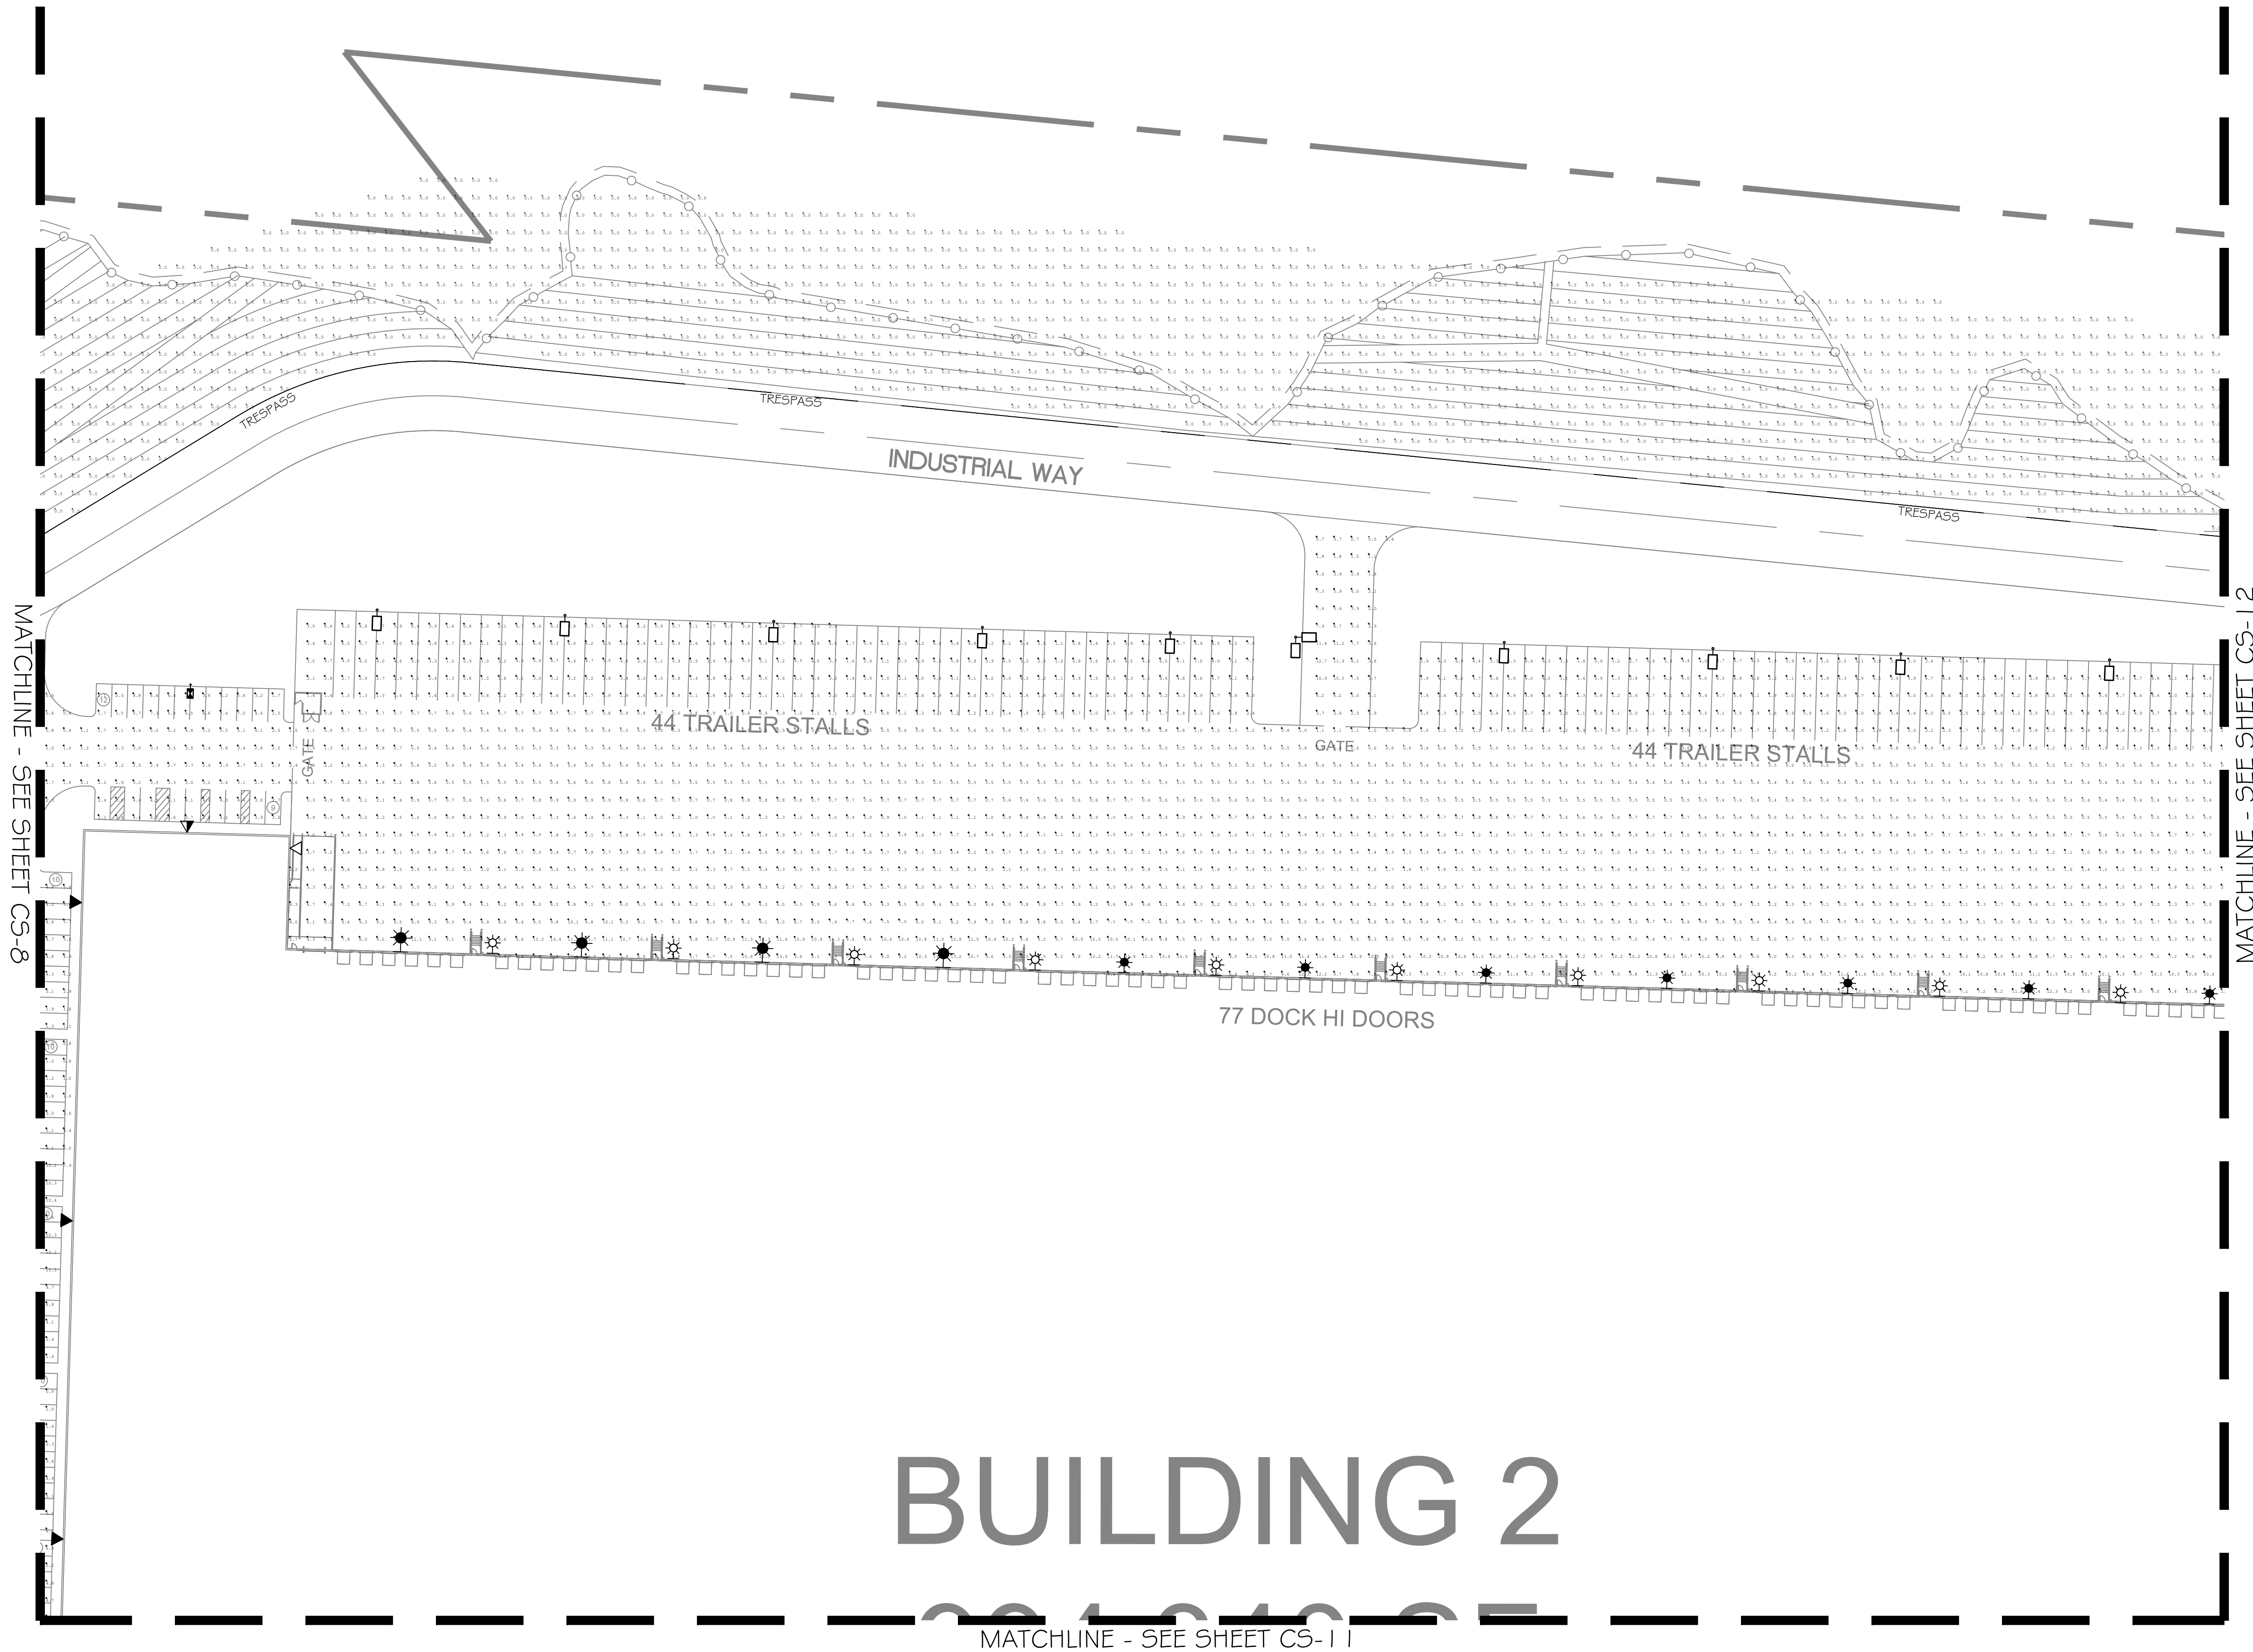

Project:  
 BEAUMONT POINTE  
 SITE LIGHTS  
 BEAUMONT, CA.

Client:  
 JRT PBI, LLC  
 18032 LEMON DE. STE. 367  
 YORBA LINDA, CA 92886



Revisions:


Sheet Info:  
 Drawn By: AZ  
 Checked By: KPJR  
 Scale: 1" = 50'-0"  
 Date: 2/18/2021  
 Job No.: JRT21/02011

Sheet Title:  
 CONCEPTUAL  
 PLAN 10

Sheet Reference:


CS-10  
 Sheet: 10 of 19

PRELIMINARY - NOT FOR CONSTRUCTION

Luminaire Schedule										Calculation Summary							
Symbol	Qty	Tag	Label	Arrangement	Lum. Lumens	BUG Rating	LLF	Description	Wattage	Label	CalcType	Units	Avg	Max	Min	Avg/Min	Max/Min
☼	115	WALL LIGHT	HUBBELL - AIRO MICRO STRIKE	SINGLE	32152	B3-U0-G5	0.900	ASL2-320L-235-4K7-4W-U @ 39'	235	BLDG1	Illuminance	Fc	3.03	14.0	0.2	15.15	70.00
☼	115	WALL LIGHT	HUBBELL - AIRO MICRO STRIKE	SINGLE	32796	B3-U0-G4	0.900	ASL2-320L-235-4K7-2-U @ 39'	235	BLDG2	Illuminance	Fc	3.04	13.8	0.3	10.13	46.00
▽	30	WALL LIGHT	HUBBELL - AIRO MICRO STRIKE	SINGLE	23853	B3-U0-G4	0.900	ASL2-320L-170-4K7-4W-U @ 25'	168	BLDG3	Illuminance	Fc	3.37	13.5	0.3	11.23	45.00
▽	29	WALL LIGHT	HUBBELL - AIRO MICRO STRIKE	SINGLE	24139	B3-U0-G4	0.900	ASL2-320L-170-4K7-3-U @ 25'	168	BLDG4	Illuminance	Fc	3.26	14.6	0.2	16.30	73.00
▽	20	WALL LIGHT	HUBBELL - AIRO MICRO STRIKE	SINGLE	24330	B3-U0-G3	0.900	ASL2-320L-170-4K7-2-U @ 25'	168	BLDG5	Illuminance	Fc	3.12	14.2	0.3	10.40	47.33
□	32	POLE LIGHT	HUBBELL - AIRO MICRO STRIKE	SINGLE	23853	B1-U0-G2	0.900	ASL2-320L-170-4K7-4W-BC @ 20'	168	RETAIL SITE	Illuminance	Fc	3.64	12.2	0.7	5.20	17.43
□	174	POLE LIGHT	HUBBELL - AIRO MICRO STRIKE	SINGLE	23853	B3-U0-G4	0.900	ASL2-320L-170-4K7-4W-U @ 20'	168	TRESPASS	Illuminance	Fc	0.00	0.7	0.0	N.A.	N.A.
□	8	POLE LIGHT	HUBBELL - AIRO MICRO STRIKE	SINGLE	24139	B1-U0-G2	0.900	ASL2-320L-170-4K7-3-BC @ 20'	168								
□	23	POLE LIGHT	HUBBELL - AIRO MICRO STRIKE	SINGLE	24139	B3-U0-G4	0.900	ASL2-320L-170-4K7-3-U @ 20'	168								
□	5	POLE LIGHT	HUBBELL - AIRO MICRO STRIKE	SINGLE	24330	B1-U0-G2	0.900	ASL2-320L-170-4K7-2-BC @ 20'	168								
□	28	POLE LIGHT	HUBBELL - AIRO MICRO STRIKE	SINGLE	24330	B3-U0-G3	0.900	ASL2-320L-170-4K7-2-U @ 20'	168								
□	3	POLE LIGHT DBL	HUBBELL - AIRO MICRO STRIKE	2 @ 90 DEGREES	23853	B3-U0-G4	0.900	ASL2-320L-170-4K7-4W-U @ 20'	168								
□	44	POLE LIGHT DBL	HUBBELL - AIRO MICRO STRIKE	BACK-BACK	23853	B3-U0-G4	0.900	ASL2-320L-170-4K7-4W-U @ 20'	168								

MATCHLINE - SEE SHEET CS-10

# 994,340 SF

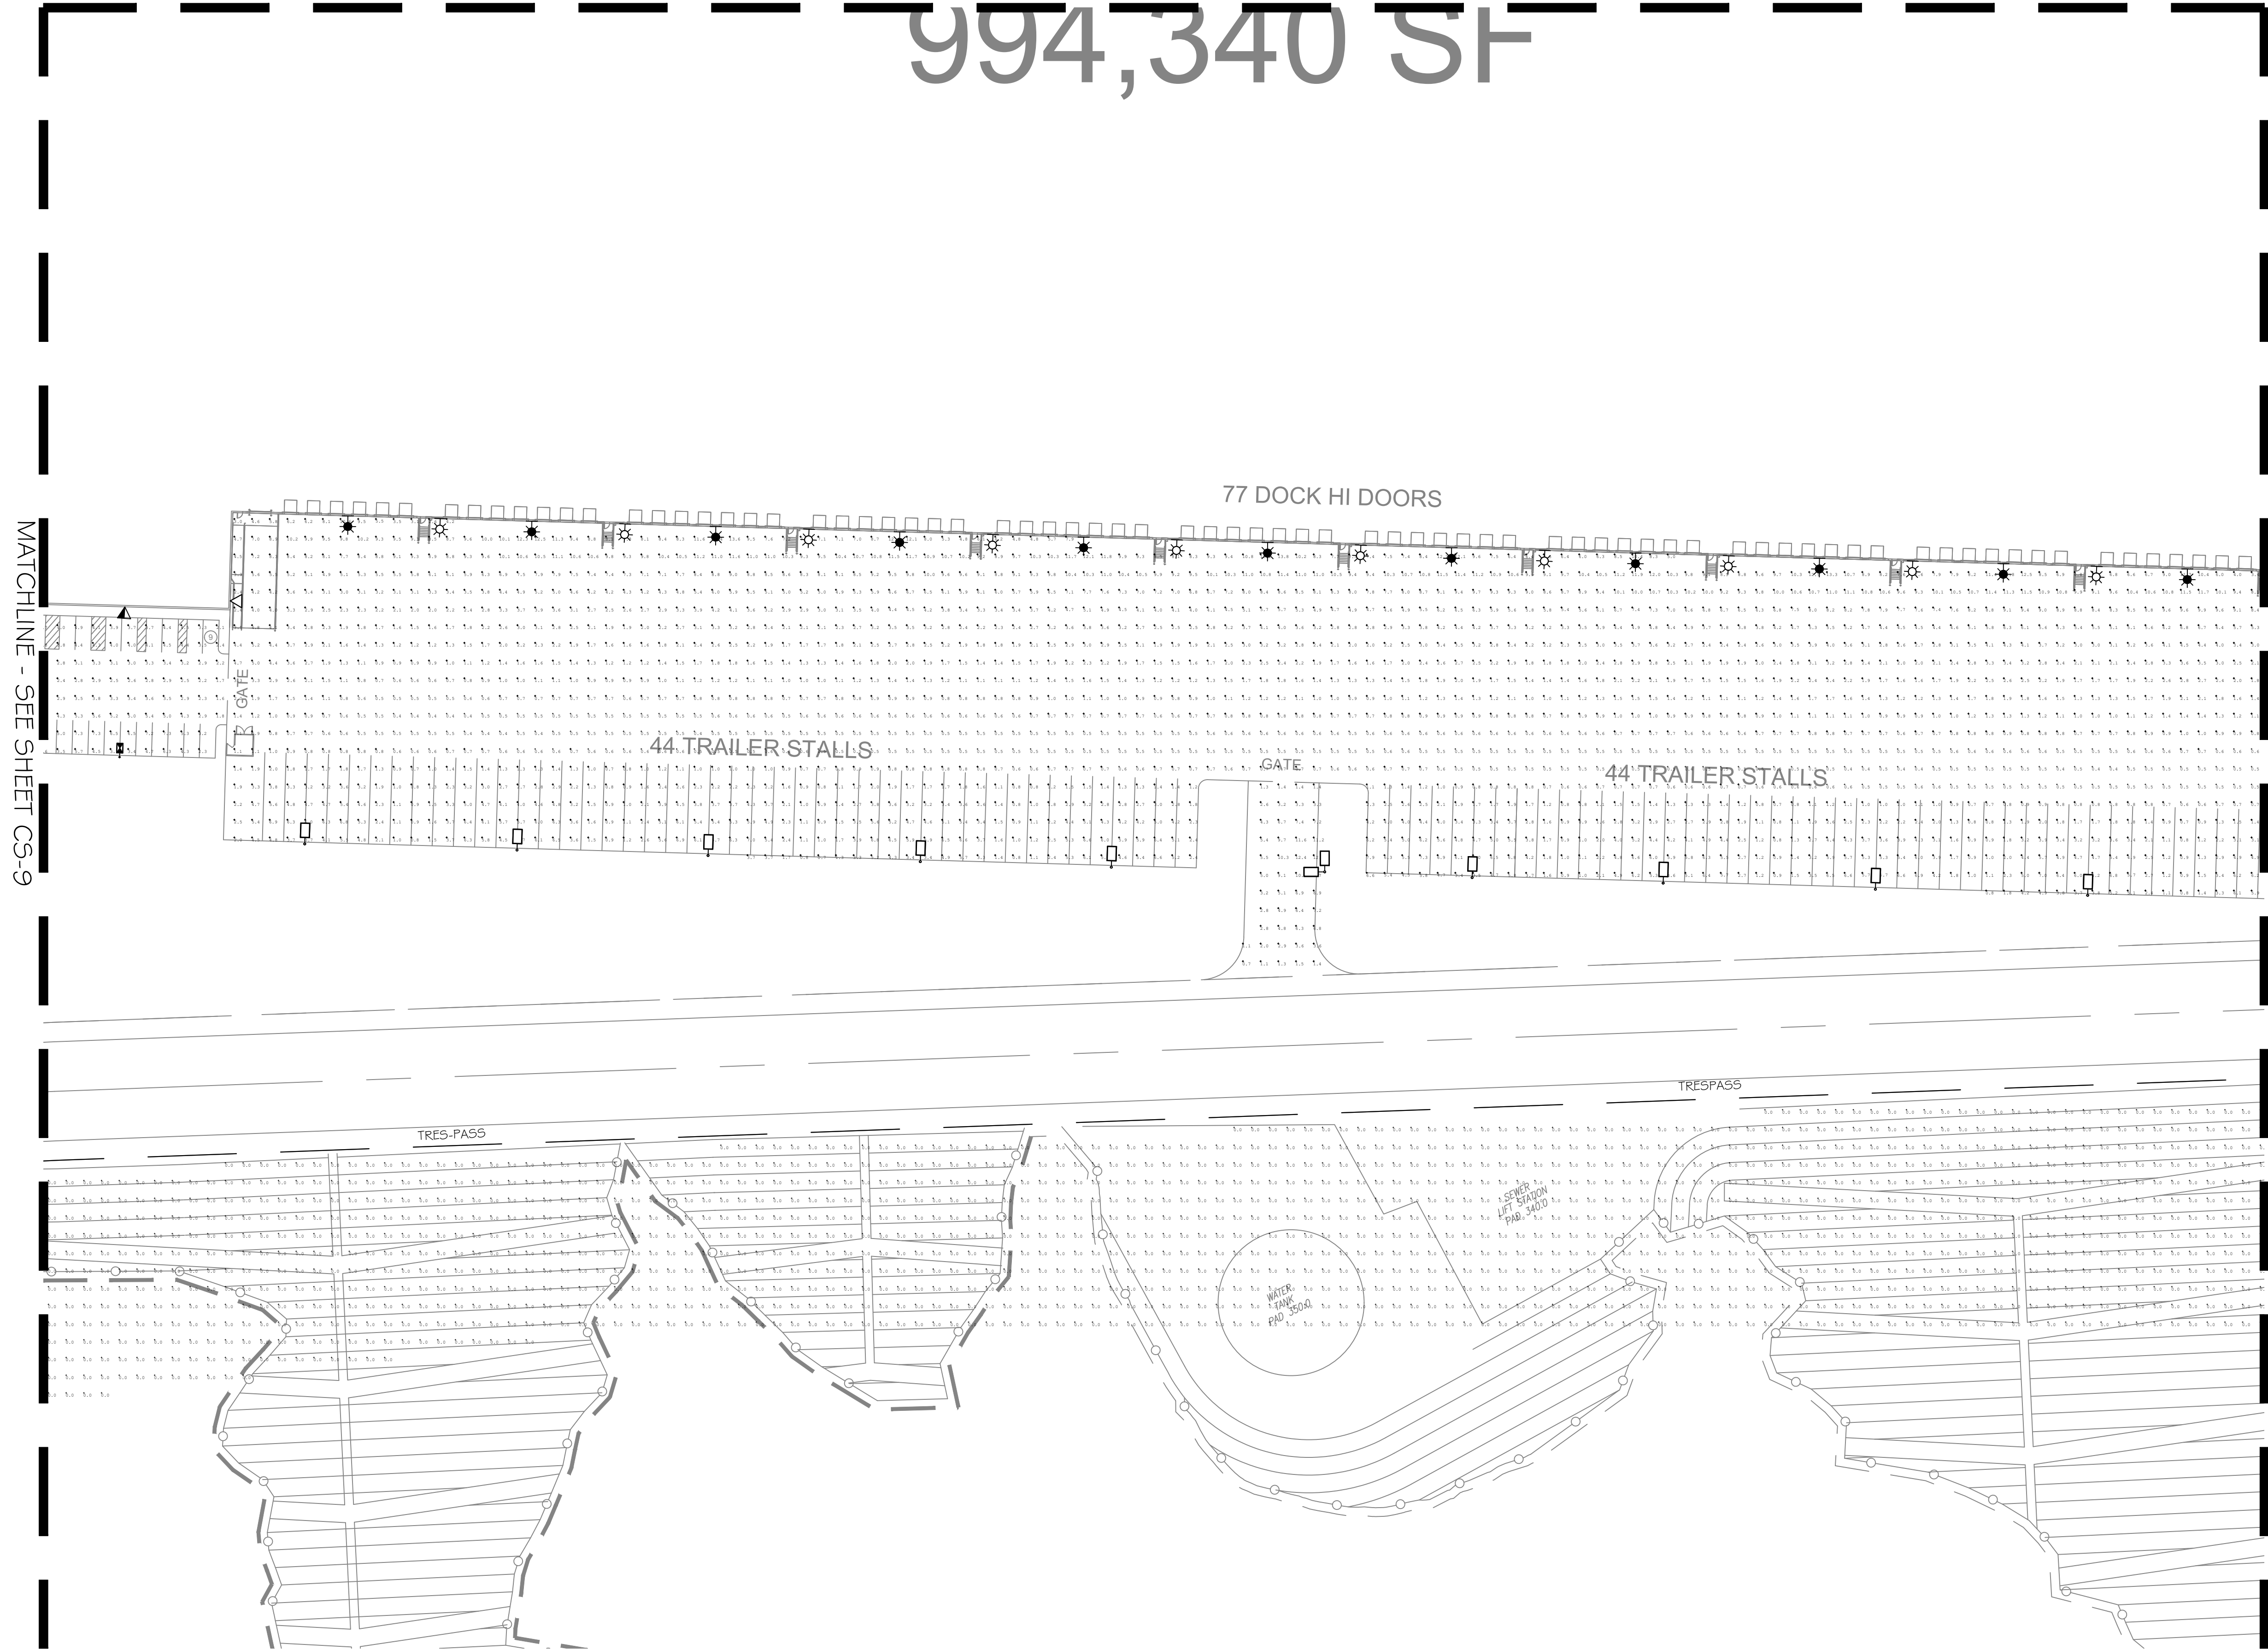

Project:  
BEAUMONT POINTE  
SITE LIGHTS  
BEAUMONT, CA.

Client:  
JRT PBI, LLC  
18032 LEMON DE. STE. 367  
YORBA LINDA, CA 92886



Revisions:

Sheet Info:  
Drawn By: AZ  
Checked By: KPJR  
Scale: 1"=50'-0"  
Date: 2/18/2021  
Job No.: JRT21/02011

Sheet Title:  
CONCEPTUAL  
SHEET 11


Sheet Reference:

# CS-11

Sheet: 11 of 19

PRELIMINARY - NOT FOR CONSTRUCTION


Luminaire Schedule										Calculation Summary							
Symbol	Qty	Tag	Label	Arrangement	Lum. Lumens	BUG Rating	LLF	Description	Wattage	Label	CalcType	Units	Avg	Max	Min	Avg/Min	Max/Min
☼	115	WALL LIGHT	HUBBELL - AIRO MICRO STRIKE	SINGLE	32152	B3-U0-G5	0.900	ASL2-320L-235-4K7-4W-U @ 39'	235	BLDG1	Illuminance	Fc	3.03	14.0	0.2	15.15	70.00
☼	115	WALL LIGHT	HUBBELL - AIRO MICRO STRIKE	SINGLE	32796	B3-U0-G4	0.900	ASL2-320L-235-4K7-2-U @ 39'	235	BLDG2	Illuminance	Fc	3.04	13.8	0.3	10.13	46.00
▽	30	WALL LIGHT	HUBBELL - AIRO MICRO STRIKE	SINGLE	23853	B3-U0-G4	0.900	ASL2-320L-170-4K7-4W-U @ 25'	168	BLDG3	Illuminance	Fc	3.37	13.5	0.3	11.23	45.00
▽	29	WALL LIGHT	HUBBELL - AIRO MICRO STRIKE	SINGLE	24139	B3-U0-G4	0.900	ASL2-320L-170-4K7-3-U @ 25'	168	BLDG4	Illuminance	Fc	3.26	14.6	0.2	16.30	73.00
▽	20	WALL LIGHT	HUBBELL - AIRO MICRO STRIKE	SINGLE	24330	B3-U0-G3	0.900	ASL2-320L-170-4K7-2-U @ 25'	168	BLDG5	Illuminance	Fc	3.12	14.2	0.3	10.40	47.33
☼	32	POLE LIGHT	HUBBELL - AIRO MICRO STRIKE	SINGLE	23853	B1-U0-G2	0.900	ASL2-320L-170-4K7-4W-BC @ 20'	168	RETAIL SITE	Illuminance	Fc	3.64	12.2	0.7	5.20	17.43
☼	174	POLE LIGHT	HUBBELL - AIRO MICRO STRIKE	SINGLE	23853	B3-U0-G4	0.900	ASL2-320L-170-4K7-4W-U @ 20'	168	TRESPASS	Illuminance	Fc	0.00	0.7	0.0	N.A.	N.A.
☼	8	POLE LIGHT	HUBBELL - AIRO MICRO STRIKE	SINGLE	24139	B1-U0-G2	0.900	ASL2-320L-170-4K7-3-BC @ 20'	168								
☼	23	POLE LIGHT	HUBBELL - AIRO MICRO STRIKE	SINGLE	24139	B3-U0-G4	0.900	ASL2-320L-170-4K7-3-U @ 20'	168								
☼	5	POLE LIGHT	HUBBELL - AIRO MICRO STRIKE	SINGLE	24330	B1-U0-G2	0.900	ASL2-320L-170-4K7-2-BC @ 20'	168								
☼	28	POLE LIGHT	HUBBELL - AIRO MICRO STRIKE	SINGLE	24330	B3-U0-G3	0.900	ASL2-320L-170-4K7-2-U @ 20'	168								
☼	3	POLE LIGHT DBL	HUBBELL - AIRO MICRO STRIKE	2 @ 90 DEGREES	23853	B3-U0-G4	0.900	ASL2-320L-170-4K7-4W-U @ 20'	168								
☼	44	POLE LIGHT DBL	HUBBELL - AIRO MICRO STRIKE	BACK-BACK	23853	B3-U0-G4	0.900	ASL2-320L-170-4K7-4W-U @ 20'	168								

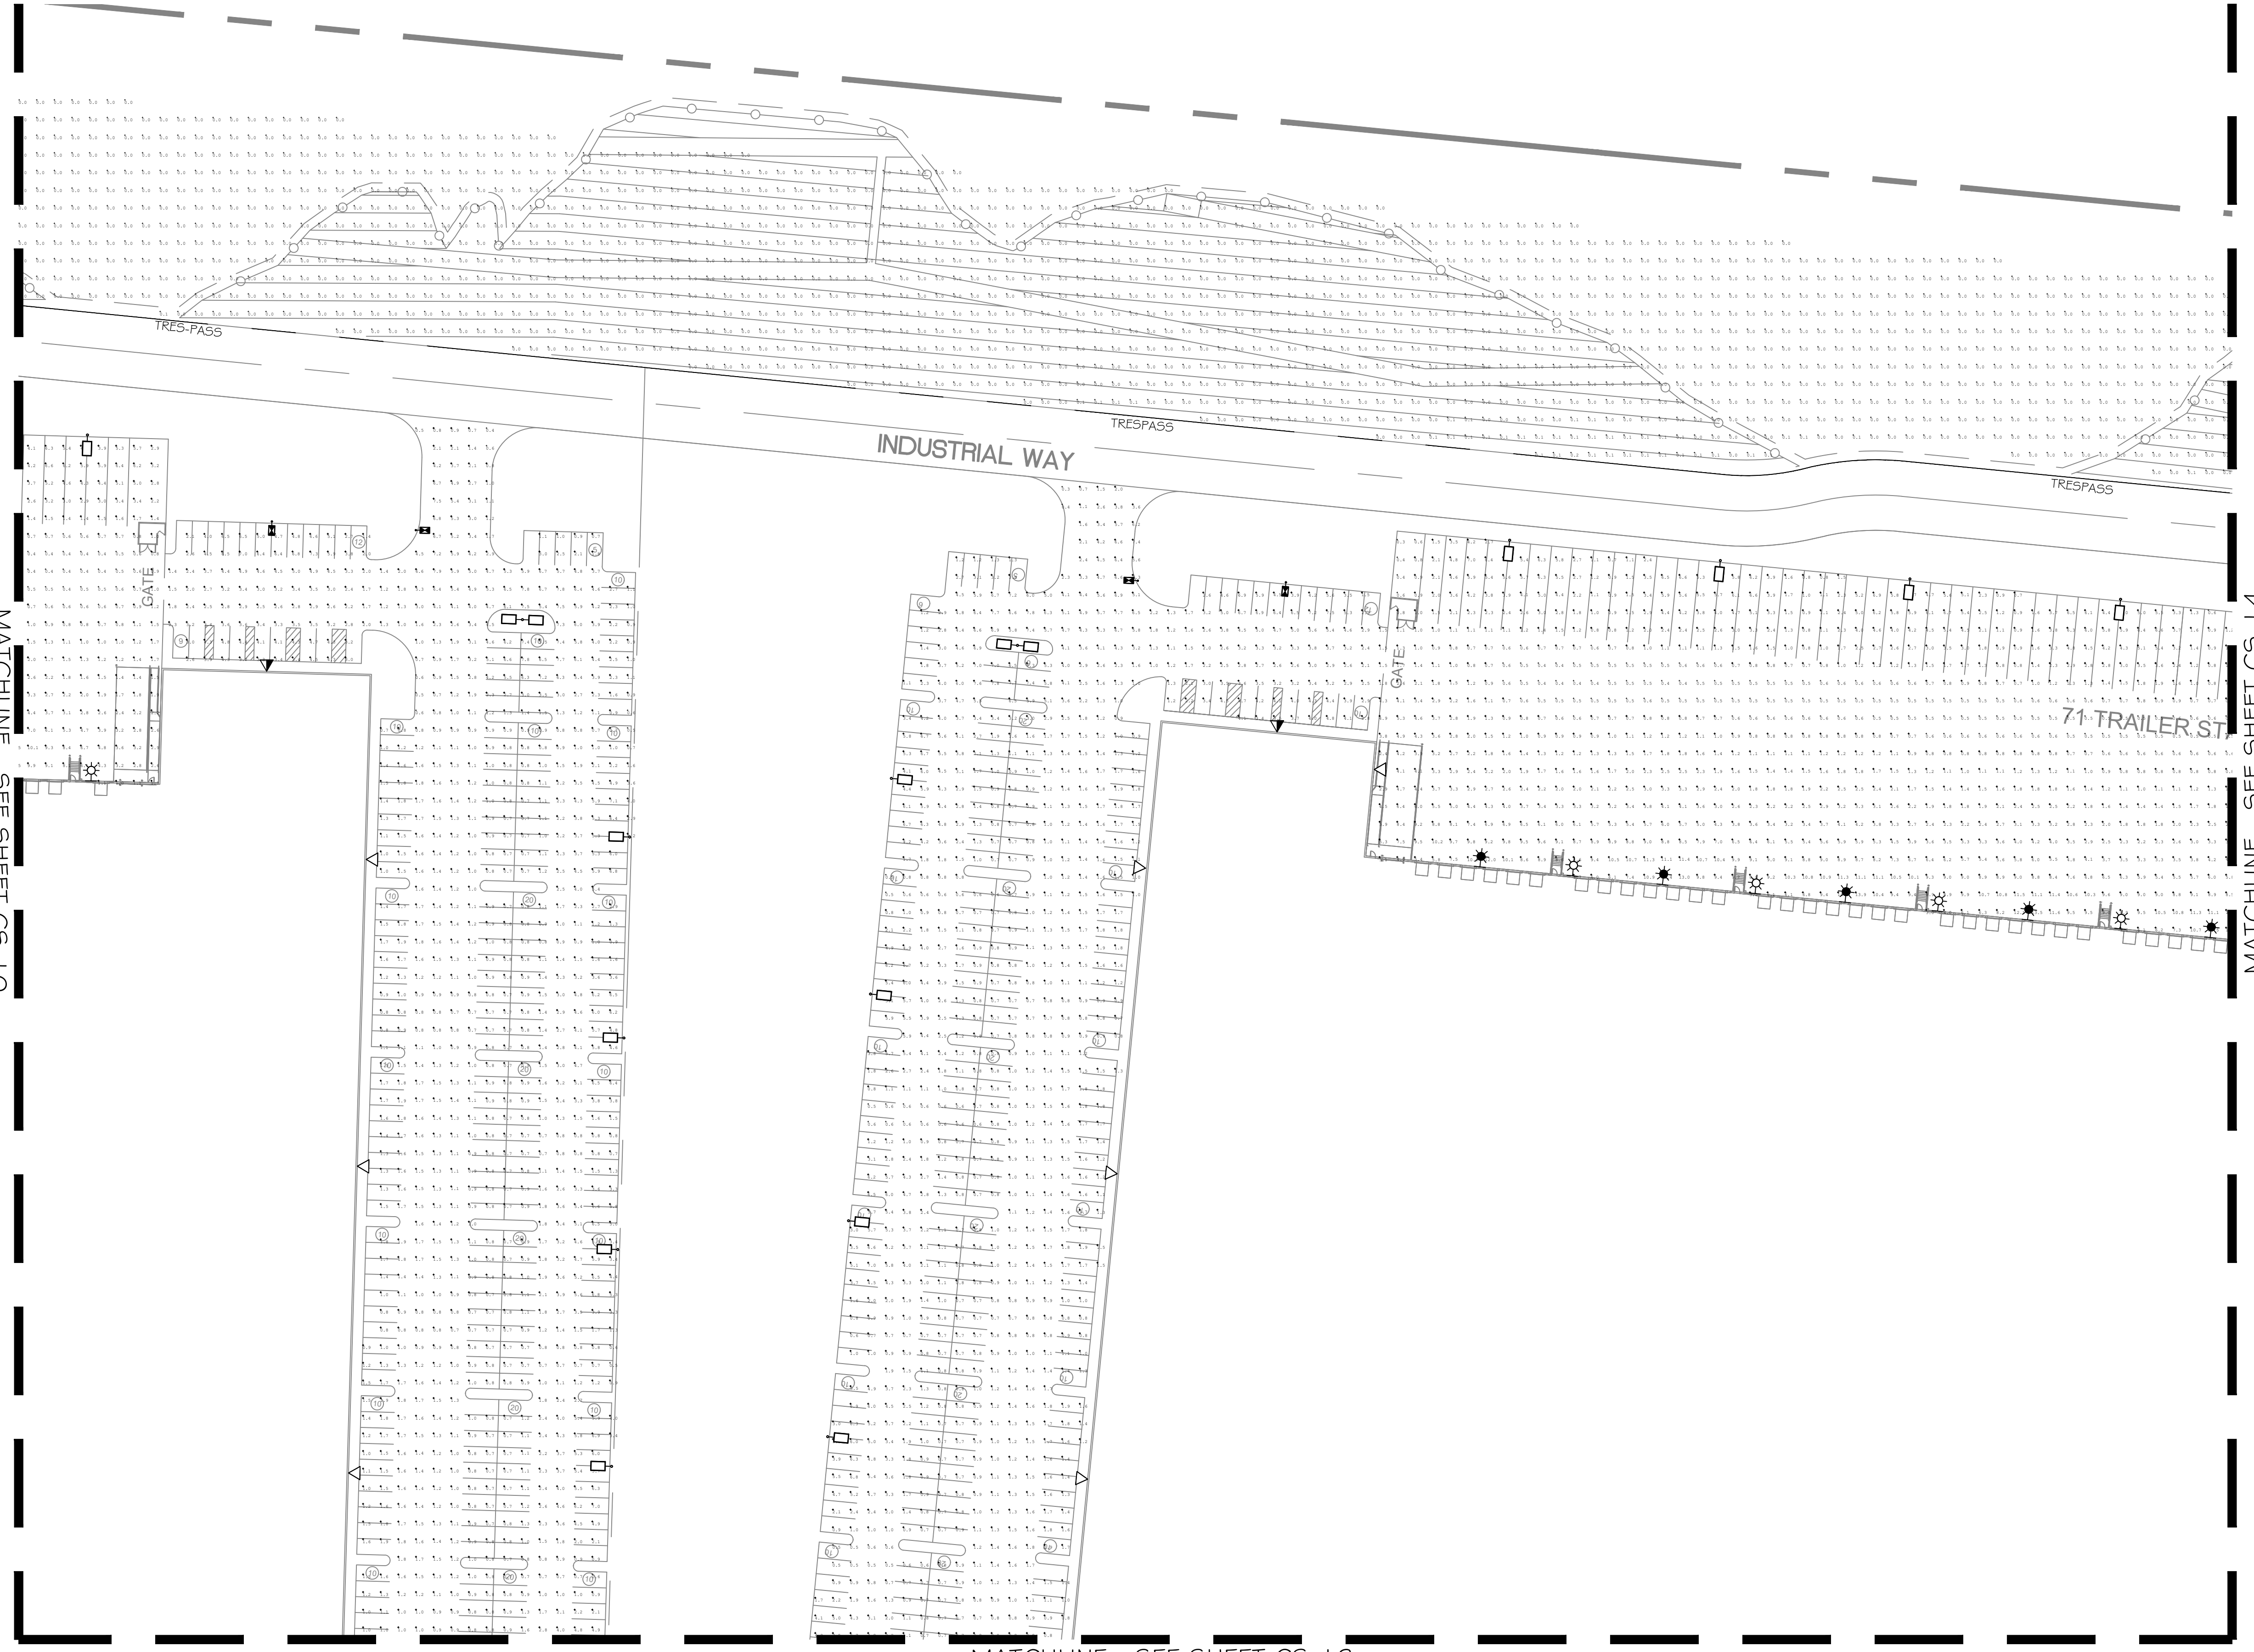

MATCHLINE - SEE SHEET CS-10

MATCHLINE - SEE SHEET CS-14

MATCHLINE - SEE SHEET CS-13

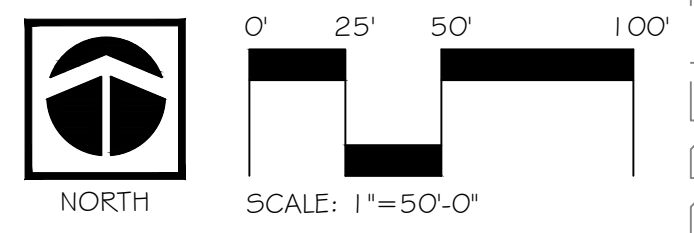


PRELIMINARY - NOT FOR CONSTRUCTION



Project:  
BEAUMONT POINTE  
SITE LIGHTS  
BEAUMONT, CA.

Client:  
JRT PBI, LLC  
18032 LEMON DE. STE. 367  
YORBA LINDA, CA 92886

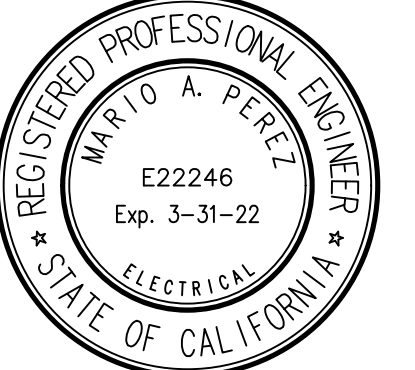

Revisions:


Sheet Info:  
Drawn By: AZ  
Checked By: KPJR  
Scale: 1"= 50'-0"  
Date: 2/18/2021  
Job No.: JRT21/02011


Sheet Title:  
CONCEPTUAL  
PLAN 12

Sheet Reference:

CS-12

Sheet: 12 of 19


MATCHLINE - SEE SHEET CS-12

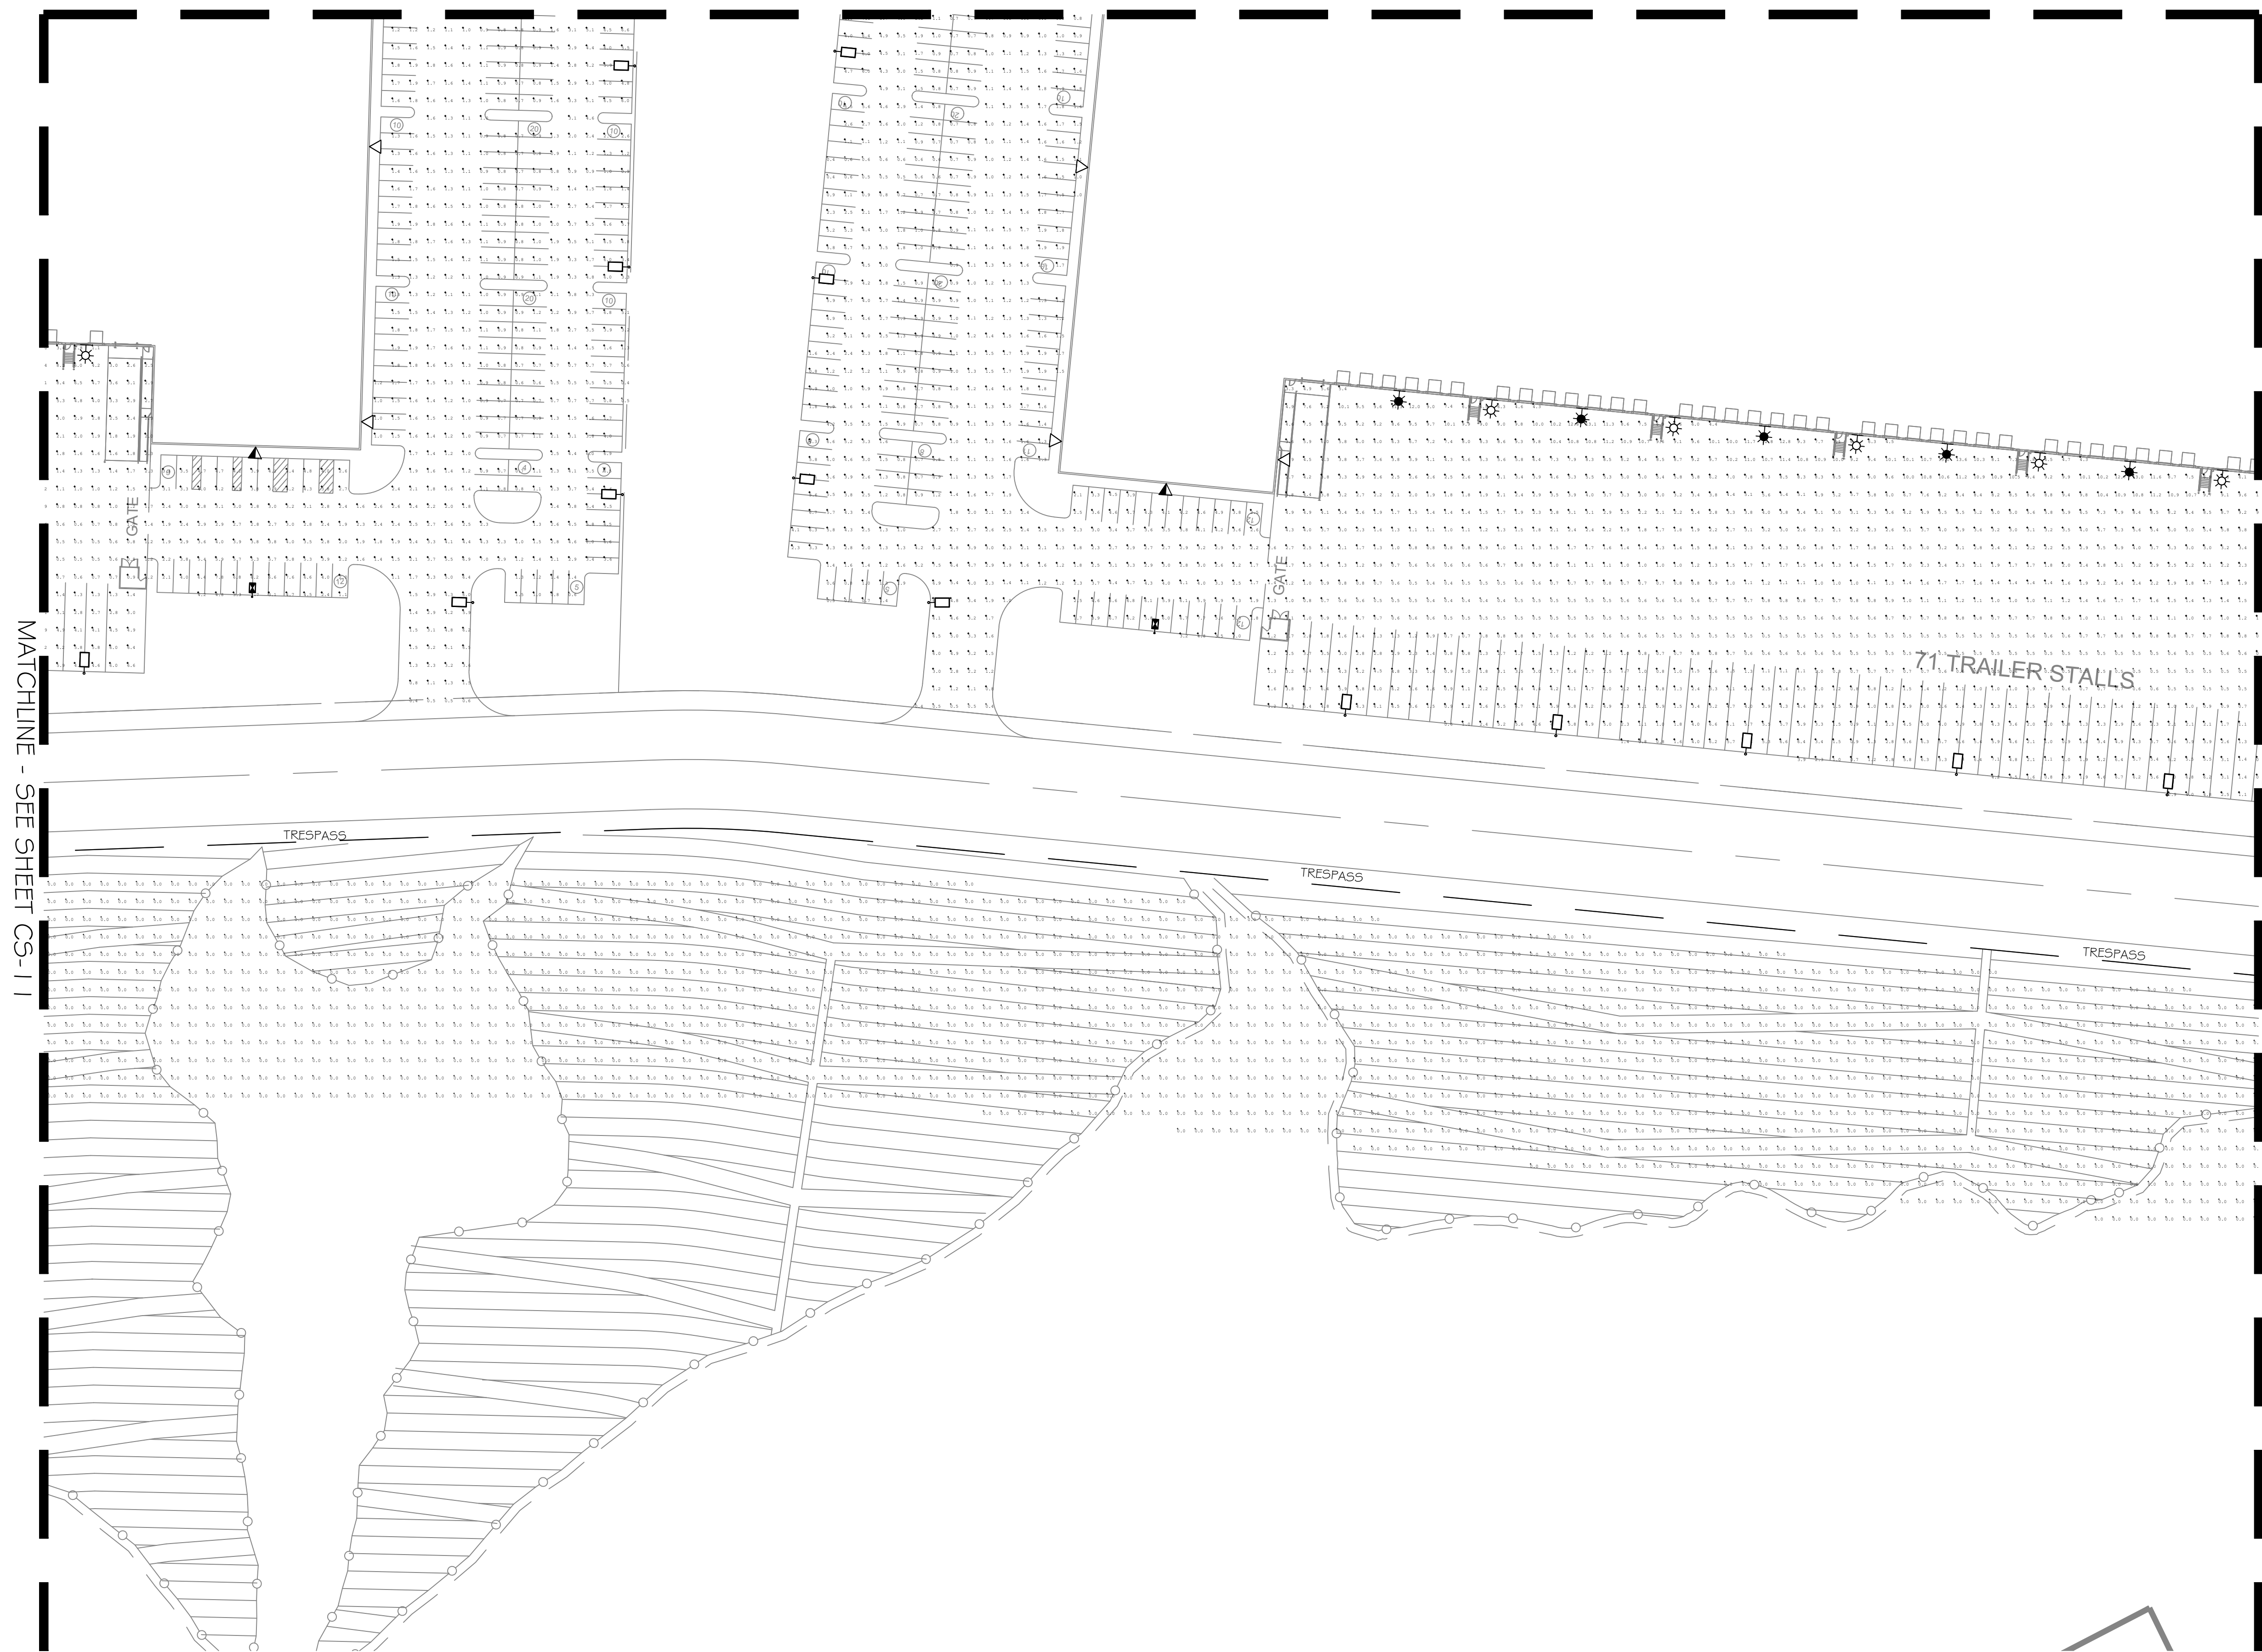


MATCHLINE - SEE SHEET CS-11

MATCHLINE - SEE SHEET CS-15

Luminaire Schedule										Calculation Summary							
Symbol	Qty	Tag	Label	Arrangement	Lum. Lumens	BUG Rating	LLF	Description	Wattage	Label	CalcType	Units	Avg	Max	Min	Avg/Min	Max/Min
✱	115		WALL LIGHT	HUBBELL - AIRO MICRO STRIKE	SINGLE	32152	0.900	B3-U0-G5 ASL2-320L-235-4K7-4W-U @ 39'	235	BLDG1	Illuminance	Fc	3.03	14.0	0.2	15.15	70.00
✱	115		WALL LIGHT	HUBBELL - AIRO MICRO STRIKE	SINGLE	32796	0.900	ASL2-320L-235-4K7-2-U @ 39'	235	BLDG2	Illuminance	Fc	3.04	13.8	0.3	10.13	46.00
▽	30		WALL LIGHT	HUBBELL - AIRO MICRO STRIKE	SINGLE	23853	0.900	ASL2-320L-170-4K7-4W-U @ 25'	168	BLDG3	Illuminance	Fc	3.37	13.5	0.3	11.23	45.00
▽	29		WALL LIGHT	HUBBELL - AIRO MICRO STRIKE	SINGLE	24139	0.900	B3-U0-G4 ASL2-320L-170-4K7-3-U @ 25'	168	BLDG4	Illuminance	Fc	3.26	14.6	0.2	16.30	73.00
▽	20		WALL LIGHT	HUBBELL - AIRO MICRO STRIKE	SINGLE	24330	0.900	ASL2-320L-170-4K7-2-U @ 25'	168	BLDG5	Illuminance	Fc	3.12	14.2	0.3	10.40	47.33
□	32		POLE LIGHT	HUBBELL - AIRO MICRO STRIKE	SINGLE	23853	0.900	ASL2-320L-170-4K7-4W-BC @ 20'	168	RETAIL SITE	Illuminance	Fc	3.64	12.2	0.7	5.20	17.43
□	174		POLE LIGHT	HUBBELL - AIRO MICRO STRIKE	SINGLE	23853	0.900	ASL2-320L-170-4K7-4W-U @ 20'	168	TRESPASS	Illuminance	Fc	0.00	0.7	0.0	N.A.	N.A.
□	8		POLE LIGHT	HUBBELL - AIRO MICRO STRIKE	SINGLE	24139	0.900	B1-U0-G2 ASL2-320L-170-4K7-3-BC @ 20'	168								
□	23		POLE LIGHT	HUBBELL - AIRO MICRO STRIKE	SINGLE	24139	0.900	ASL2-320L-170-4K7-3-U @ 20'	168								
□	5		POLE LIGHT	HUBBELL - AIRO MICRO STRIKE	SINGLE	24330	0.900	ASL2-320L-170-4K7-2-BC @ 20'	168								
□	28		POLE LIGHT	HUBBELL - AIRO MICRO STRIKE	SINGLE	24330	0.900	ASL2-320L-170-4K7-2-U @ 20'	168								
□	3		POLE LIGHT DBL	HUBBELL - AIRO MICRO STRIKE	2 @ 90 DEGREES	23853	0.900	ASL2-320L-170-4K7-4W-U @ 20'	168								
□	44		POLE LIGHT DBL	HUBBELL - AIRO MICRO STRIKE	BACK-BACK	23853	0.900	ASL2-320L-170-4K7-4W-U @ 20'	168								

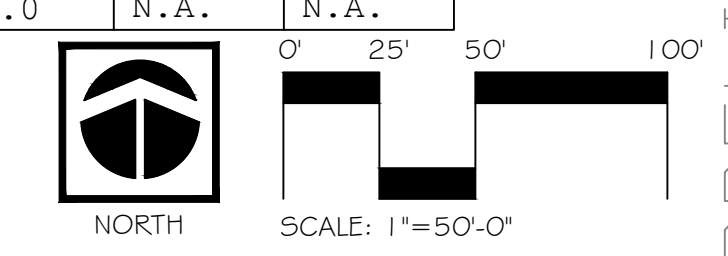

PRELIMINARY - NOT FOR CONSTRUCTION

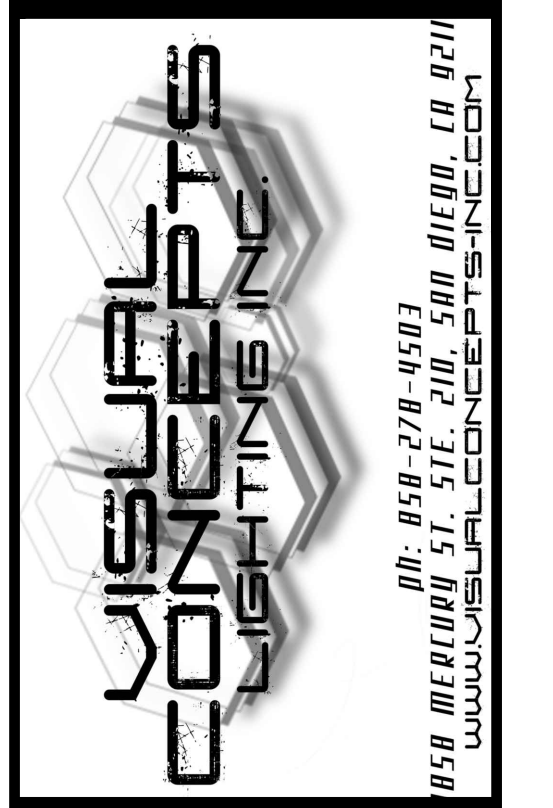

Project:  
BEAUMONT POINTE  
SITE LIGHTS  
BEAUMONT, CA.

Client:  
JRT PBI, LLC  
18032 LEMON DE. STE. 367  
YORBA LINDA, CA 92886



Revisions:



Sheet Info:  
Drawn By: AZ  
Checked By: KPJR  
Scale: 1"=50'-0"  
Date: 2/18/2021  
Job No.: JRT21/02011

Sheet Title:  
CONCEPTUAL  
PLAN 13



Sheet Reference:

CS-13  
Sheet: 13 of 19

Luminaire Schedule										Calculation Summary							
Symbol	Qty	Tag	Label	Arrangement	Lum. Lumens	BUG Rating	LLF	Description	Wattage	Label	CalcType	Units	Avg	Max	Min	Avg/Min	Max/Min
☼	115	WALL LIGHT	HUBBELL - AIRO MICRO STRIKE	SINGLE	32152	B3-U0-G5	0.900	ASL2-320L-235-4K7-4W-U @ 39'	235	BLDG1	Illuminance	Fc	3.03	14.0	0.2	15.15	70.00
☼	115	WALL LIGHT	HUBBELL - AIRO MICRO STRIKE	SINGLE	32796	B3-U0-G4	0.900	ASL2-320L-235-4K7-2-U @ 39'	235	BLDG2	Illuminance	Fc	3.04	13.8	0.3	10.13	46.00
▽	30	WALL LIGHT	HUBBELL - AIRO MICRO STRIKE	SINGLE	23853	B3-U0-G4	0.900	ASL2-320L-170-4K7-4W-U @ 25'	168	BLDG3	Illuminance	Fc	3.37	13.5	0.3	11.23	45.00
▽	29	WALL LIGHT	HUBBELL - AIRO MICRO STRIKE	SINGLE	24139	B3-U0-G4	0.900	ASL2-320L-170-4K7-3-U @ 25'	168	BLDG4	Illuminance	Fc	3.26	14.6	0.2	16.30	73.00
▽	20	WALL LIGHT	HUBBELL - AIRO MICRO STRIKE	SINGLE	24330	B3-U0-G3	0.900	ASL2-320L-170-4K7-2-U @ 25'	168	BLDG5	Illuminance	Fc	3.12	14.2	0.3	10.40	47.33
□	32	POLE LIGHT	HUBBELL - AIRO MICRO STRIKE	SINGLE	23853	B1-U0-G2	0.900	ASL2-320L-170-4K7-4W-BC @ 20'	168	RETAIL SITE	Illuminance	Fc	3.64	12.2	0.7	5.20	17.43
□	174	POLE LIGHT	HUBBELL - AIRO MICRO STRIKE	SINGLE	23853	B3-U0-G4	0.900	ASL2-320L-170-4K7-4W-U @ 20'	168	TRESPASS	Illuminance	Fc	0.00	0.7	0.0	N.A.	N.A.
□	8	POLE LIGHT	HUBBELL - AIRO MICRO STRIKE	SINGLE	24139	B1-U0-G2	0.900	ASL2-320L-170-4K7-3-BC @ 20'	168								
□	23	POLE LIGHT	HUBBELL - AIRO MICRO STRIKE	SINGLE	24139	B3-U0-G4	0.900	ASL2-320L-170-4K7-3-U @ 20'	168								
□	5	POLE LIGHT	HUBBELL - AIRO MICRO STRIKE	SINGLE	24330	B1-U0-G2	0.900	ASL2-320L-170-4K7-2-BC @ 20'	168								
□	28	POLE LIGHT	HUBBELL - AIRO MICRO STRIKE	SINGLE	24330	B3-U0-G3	0.900	ASL2-320L-170-4K7-2-U @ 20'	168								
□	3	POLE LIGHT DBL	HUBBELL - AIRO MICRO STRIKE	2 @ 90 DEGREES	23853	B3-U0-G4	0.900	ASL2-320L-170-4K7-4W-U @ 20'	168								
□	44	POLE LIGHT DBL	HUBBELL - AIRO MICRO STRIKE	BACK-BACK	23853	B3-U0-G4	0.900	ASL2-320L-170-4K7-4W-U @ 20'	168								

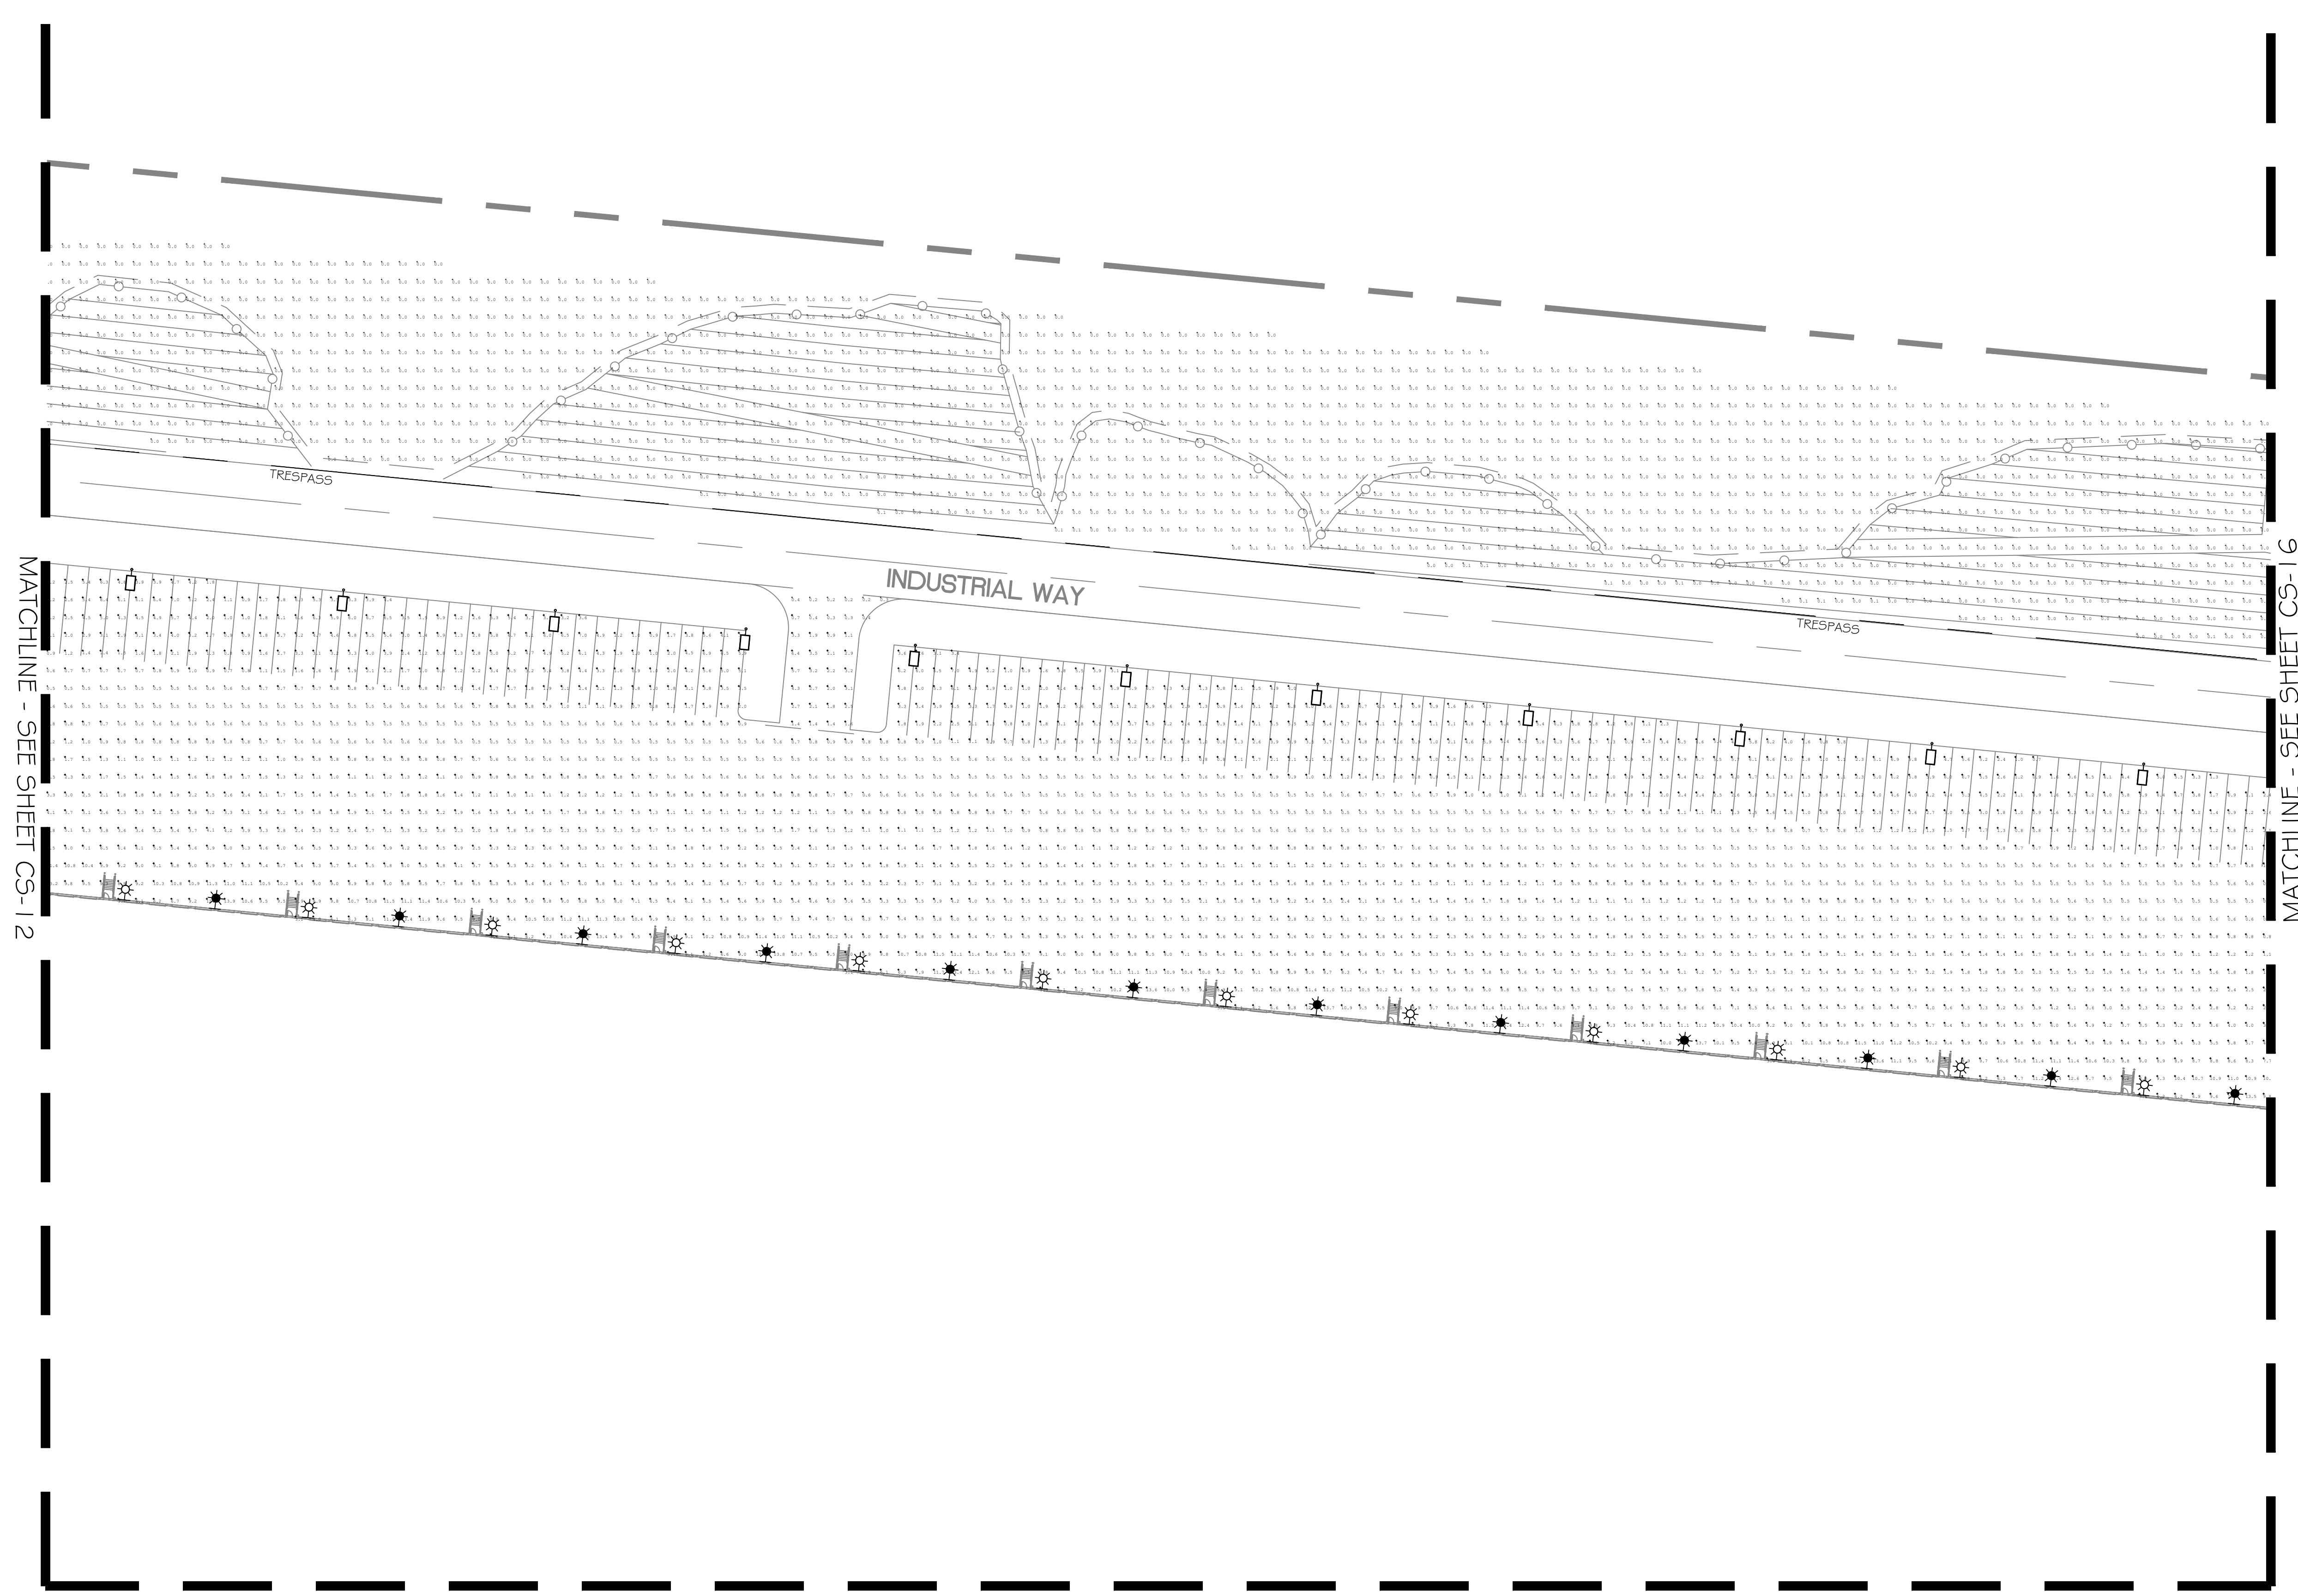


MATCHLINE - SEE SHEET CS-15

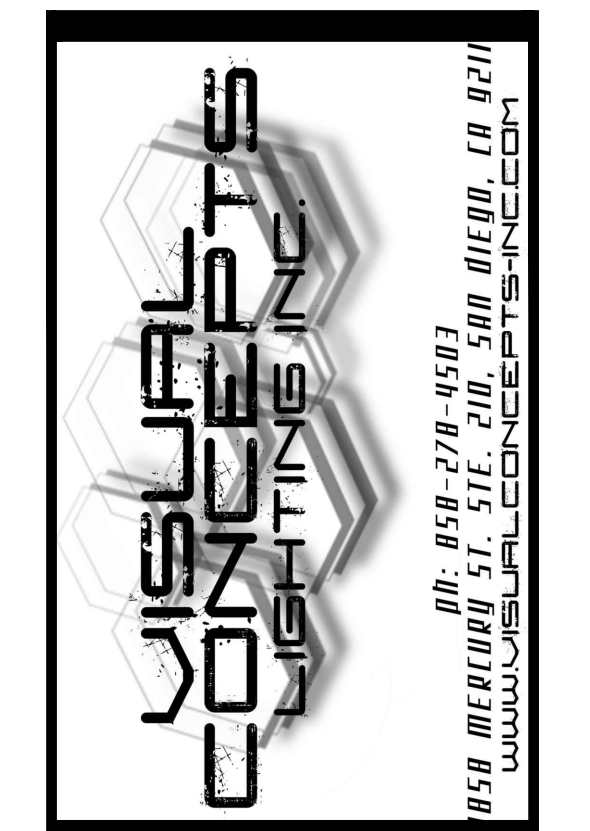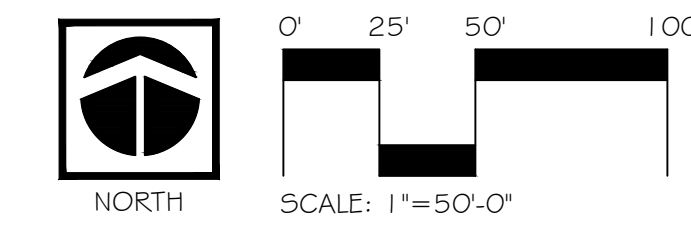

Project:  
BEAUMONT POINTE  
SITE LIGHTS  
BEAUMONT, CA.

Client:  
JRT PBI, LLC  
18032 LEMON DE. STE. 367  
YORBA LINDA, CA 92886

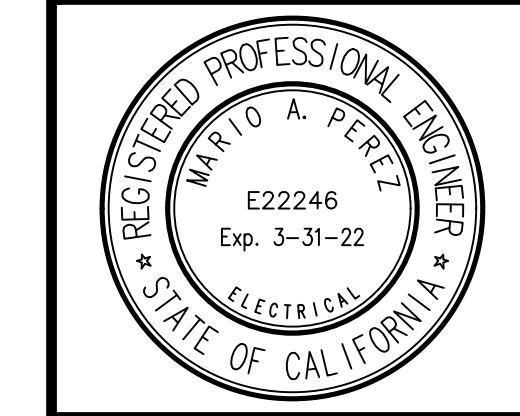

Revisions:


Sheet Info:  
Drawn By: AZ  
Checked By: KPJR  
Scale: 1"= 50'-0"  
Date: 2/18/2021  
Job No.: JRT21/02011

Sheet Title:  
CONCEPTUAL  
PLAN 14

Sheet Reference:

CS-14  
Sheet: 14 of 19


PRELIMINARY - NOT FOR CONSTRUCTION



OFF: 959-279-4503  
 858 MERCURY ST. STE. 200, SAN MATEO, CA 94021  
 WWW.VISUALCONCEPTS.COM

Project:  
 BEAUMONT POINTE  
 SITE LIGHTS  
 BEAUMONT, CA.

Client:  
 JRT PBI, LLC  
 18032 LEMON DE. STE. 367  
 YORBA LINDA, CA 92886

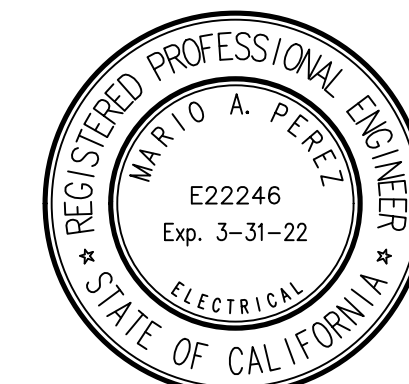

Revisions:

Sheet Info:

Drawn By: AZ  
 Checked By: KPJR  
 Scale: 1"=50'-0"  
 Date: 2/18/2021  
 Job No.: JRT21/02011

Sheet Title:  
 CONCEPTUAL  
 PLAN 15


Sheet Reference:

CS-15

Sheet: 15 of 19


MATCHLINE - SEE SHEET CS-13

MATCHLINE - SEE SHEET CS-17

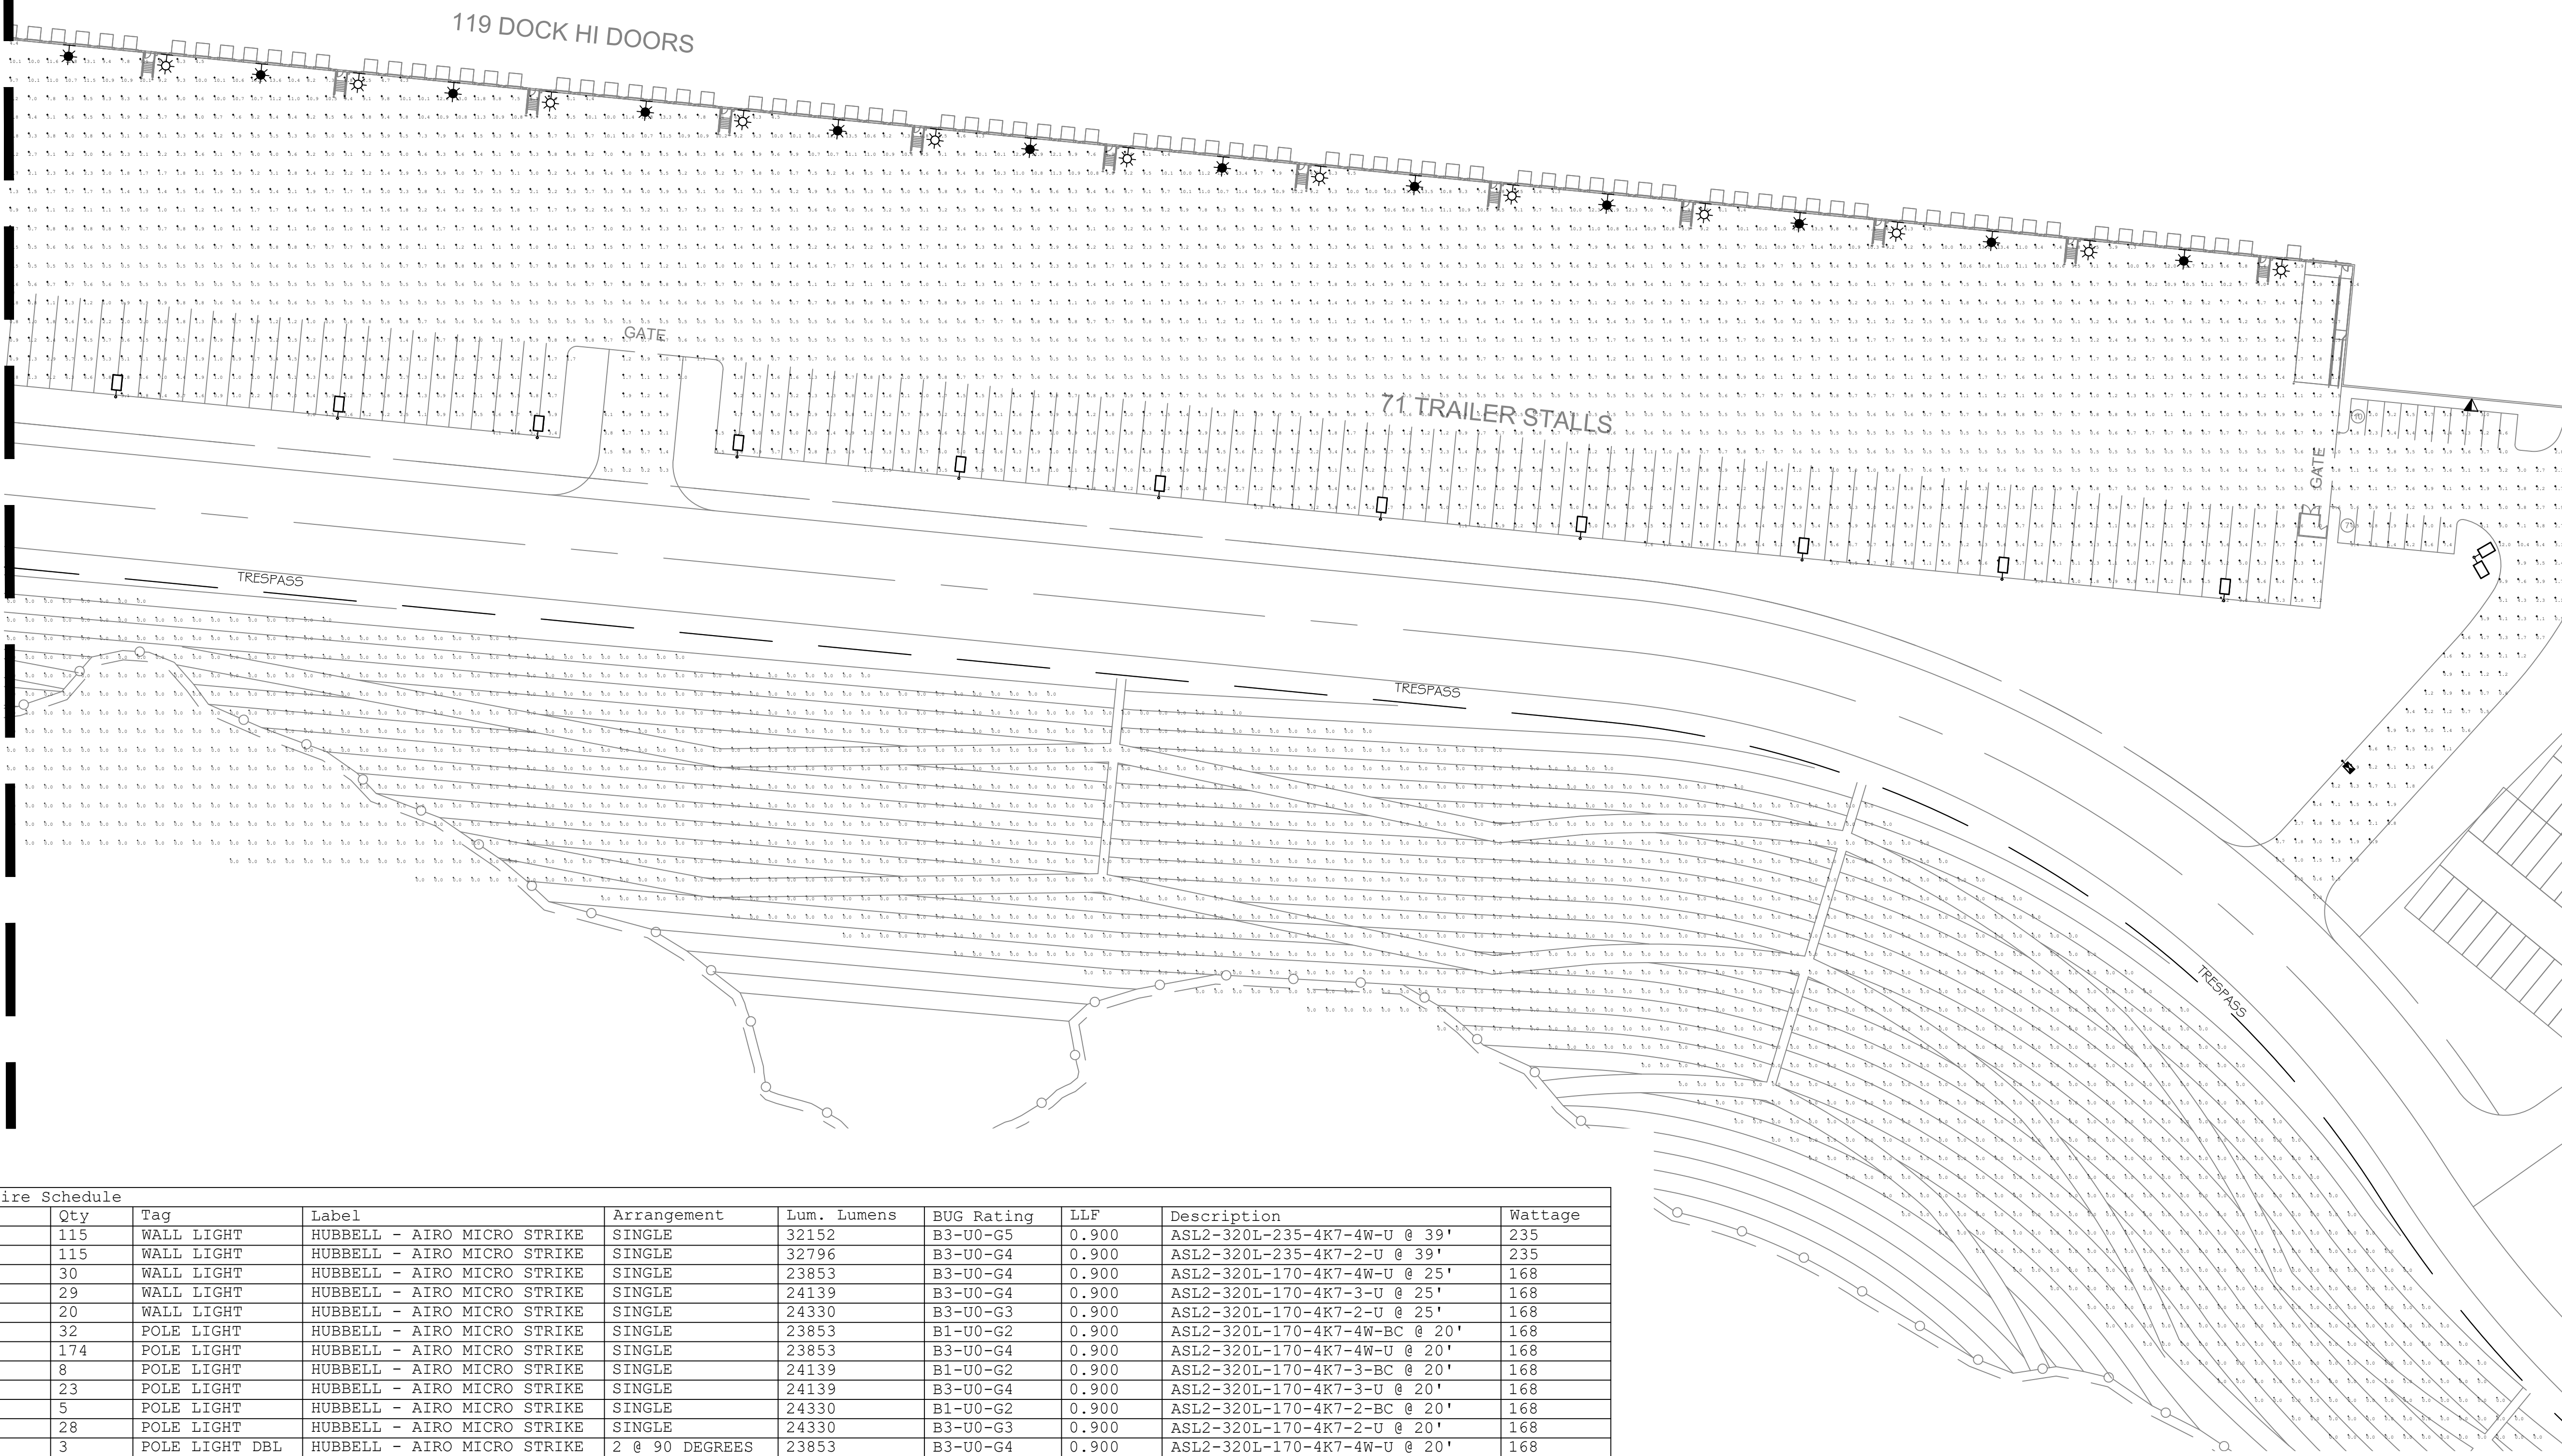

Symbol	Qty	Tag	Label	Arrangement	Lum. Lumens	BUG Rating	LLF	Description	Wattage
⊗	115	WALL LIGHT	HUBBELL - AIRO MICRO STRIKE	SINGLE	32152	B3-U0-G5	0.900	ASL2-320L-235-4K7-4W-U @ 39'	235
⊗	115	WALL LIGHT	HUBBELL - AIRO MICRO STRIKE	SINGLE	32796	B3-U0-G4	0.900	ASL2-320L-235-4K7-2-U @ 39'	235
▽	30	WALL LIGHT	HUBBELL - AIRO MICRO STRIKE	SINGLE	23853	B3-U0-G4	0.900	ASL2-320L-170-4K7-4W-U @ 25'	168
▽	29	WALL LIGHT	HUBBELL - AIRO MICRO STRIKE	SINGLE	24139	B3-U0-G4	0.900	ASL2-320L-170-4K7-3-U @ 25'	168
▽	20	WALL LIGHT	HUBBELL - AIRO MICRO STRIKE	SINGLE	24330	B3-U0-G3	0.900	ASL2-320L-170-4K7-2-U @ 25'	168
□	32	POLE LIGHT	HUBBELL - AIRO MICRO STRIKE	SINGLE	23853	B1-U0-G2	0.900	ASL2-320L-170-4K7-4W-BC @ 20'	168
□	174	POLE LIGHT	HUBBELL - AIRO MICRO STRIKE	SINGLE	23853	B3-U0-G4	0.900	ASL2-320L-170-4K7-4W-U @ 20'	168
□	8	POLE LIGHT	HUBBELL - AIRO MICRO STRIKE	SINGLE	24139	B1-U0-G2	0.900	ASL2-320L-170-4K7-3-BC @ 20'	168
□	23	POLE LIGHT	HUBBELL - AIRO MICRO STRIKE	SINGLE	24139	B3-U0-G4	0.900	ASL2-320L-170-4K7-3-U @ 20'	168
□	5	POLE LIGHT	HUBBELL - AIRO MICRO STRIKE	SINGLE	24330	B1-U0-G2	0.900	ASL2-320L-170-4K7-2-BC @ 20'	168
□	28	POLE LIGHT	HUBBELL - AIRO MICRO STRIKE	SINGLE	24330	B3-U0-G3	0.900	ASL2-320L-170-4K7-2-U @ 20'	168
□	3	POLE LIGHT DBL	HUBBELL - AIRO MICRO STRIKE	2 @ 90 DEGREES	23853	B3-U0-G4	0.900	ASL2-320L-170-4K7-4W-U @ 20'	168
□	44	POLE LIGHT DBL	HUBBELL - AIRO MICRO STRIKE	BACK-BACK	23853	B3-U0-G4	0.900	ASL2-320L-170-4K7-4W-U @ 20'	168


Label	CalcType	Units	Avg	Max	Min	Avg/Min	Max/Min
BLDG1	Illuminance	Fc	3.03	14.0	0.2	15.15	70.00
BLDG2	Illuminance	Fc	3.04	13.8	0.3	10.13	46.00
BLDG3	Illuminance	Fc	3.37	13.5	0.3	11.23	45.00
BLDG4	Illuminance	Fc	3.26	14.6	0.2	16.30	73.00
BLDG5	Illuminance	Fc	3.12	14.2	0.3	10.40	47.33
RETAIL SITE	Illuminance	Fc	3.64	12.2	0.7	5.20	17.43
TRESPASS	Illuminance	Fc	0.00	0.7	0.0	N.A.	N.A.

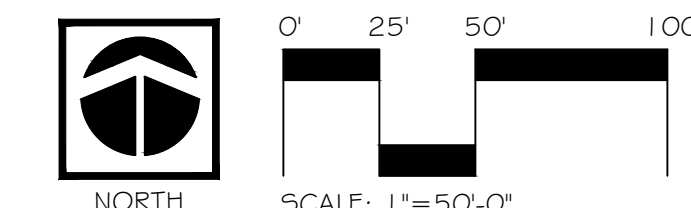

PRELIMINARY - NOT FOR CONSTRUCTION


Symbol	Qty	Tag	Label	Arrangement	Lum. Lumens	BUG Rating	LLF	Description	Wattage
⊛	115	WALL LIGHT	HUBBELL - AIRO MICRO STRIKE	SINGLE	32152	B3-U0-G5	0.900	ASL2-320L-235-4K7-4W-U @ 39'	235
⊛	115	WALL LIGHT	HUBBELL - AIRO MICRO STRIKE	SINGLE	32796	B3-U0-G4	0.900	ASL2-320L-235-4K7-2-U @ 39'	235
▽	30	WALL LIGHT	HUBBELL - AIRO MICRO STRIKE	SINGLE	23853	B3-U0-G4	0.900	ASL2-320L-170-4K7-4W-U @ 25'	168
▽	29	WALL LIGHT	HUBBELL - AIRO MICRO STRIKE	SINGLE	24139	B3-U0-G4	0.900	ASL2-320L-170-4K7-3-U @ 25'	168
▽	20	WALL LIGHT	HUBBELL - AIRO MICRO STRIKE	SINGLE	24330	B3-U0-G3	0.900	ASL2-320L-170-4K7-2-U @ 25'	168
□	32	POLE LIGHT	HUBBELL - AIRO MICRO STRIKE	SINGLE	23853	B1-U0-G2	0.900	ASL2-320L-170-4K7-4W-BC @ 20'	168
□	174	POLE LIGHT	HUBBELL - AIRO MICRO STRIKE	SINGLE	23853	B3-U0-G4	0.900	ASL2-320L-170-4K7-4W-U @ 20'	168
□	8	POLE LIGHT	HUBBELL - AIRO MICRO STRIKE	SINGLE	24139	B1-U0-G2	0.900	ASL2-320L-170-4K7-3-BC @ 20'	168
□	23	POLE LIGHT	HUBBELL - AIRO MICRO STRIKE	SINGLE	24139	B3-U0-G4	0.900	ASL2-320L-170-4K7-3-U @ 20'	168
□	5	POLE LIGHT	HUBBELL - AIRO MICRO STRIKE	SINGLE	24330	B1-U0-G2	0.900	ASL2-320L-170-4K7-2-BC @ 20'	168
□	28	POLE LIGHT	HUBBELL - AIRO MICRO STRIKE	SINGLE	24330	B3-U0-G3	0.900	ASL2-320L-170-4K7-2-U @ 20'	168
□	3	POLE LIGHT DBL	HUBBELL - AIRO MICRO STRIKE	2 @ 90 DEGREES	23853	B3-U0-G4	0.900	ASL2-320L-170-4K7-4W-U @ 20'	168
□	44	POLE LIGHT DBL	HUBBELL - AIRO MICRO STRIKE	BACK-BACK	23853	B3-U0-G4	0.900	ASL2-320L-170-4K7-4W-U @ 20'	168

Label	CalcType	Units	Avg	Max	Min	Avg/Min	Max/Min
BLDG1	Illuminance	Fc	3.03	14.0	0.2	15.15	70.00
BLDG2	Illuminance	Fc	3.04	13.8	0.3	10.13	46.00
BLDG3	Illuminance	Fc	3.37	13.5	0.3	11.23	45.00
BLDG4	Illuminance	Fc	3.26	14.6	0.2	16.30	73.00
BLDG5	Illuminance	Fc	3.12	14.2	0.3	10.40	47.33
RETAIL SITE	Illuminance	Fc	3.64	12.2	0.7	5.20	17.43
TRESPASS	Illuminance	Fc	0.00	0.7	0.0	N.A.	N.A.

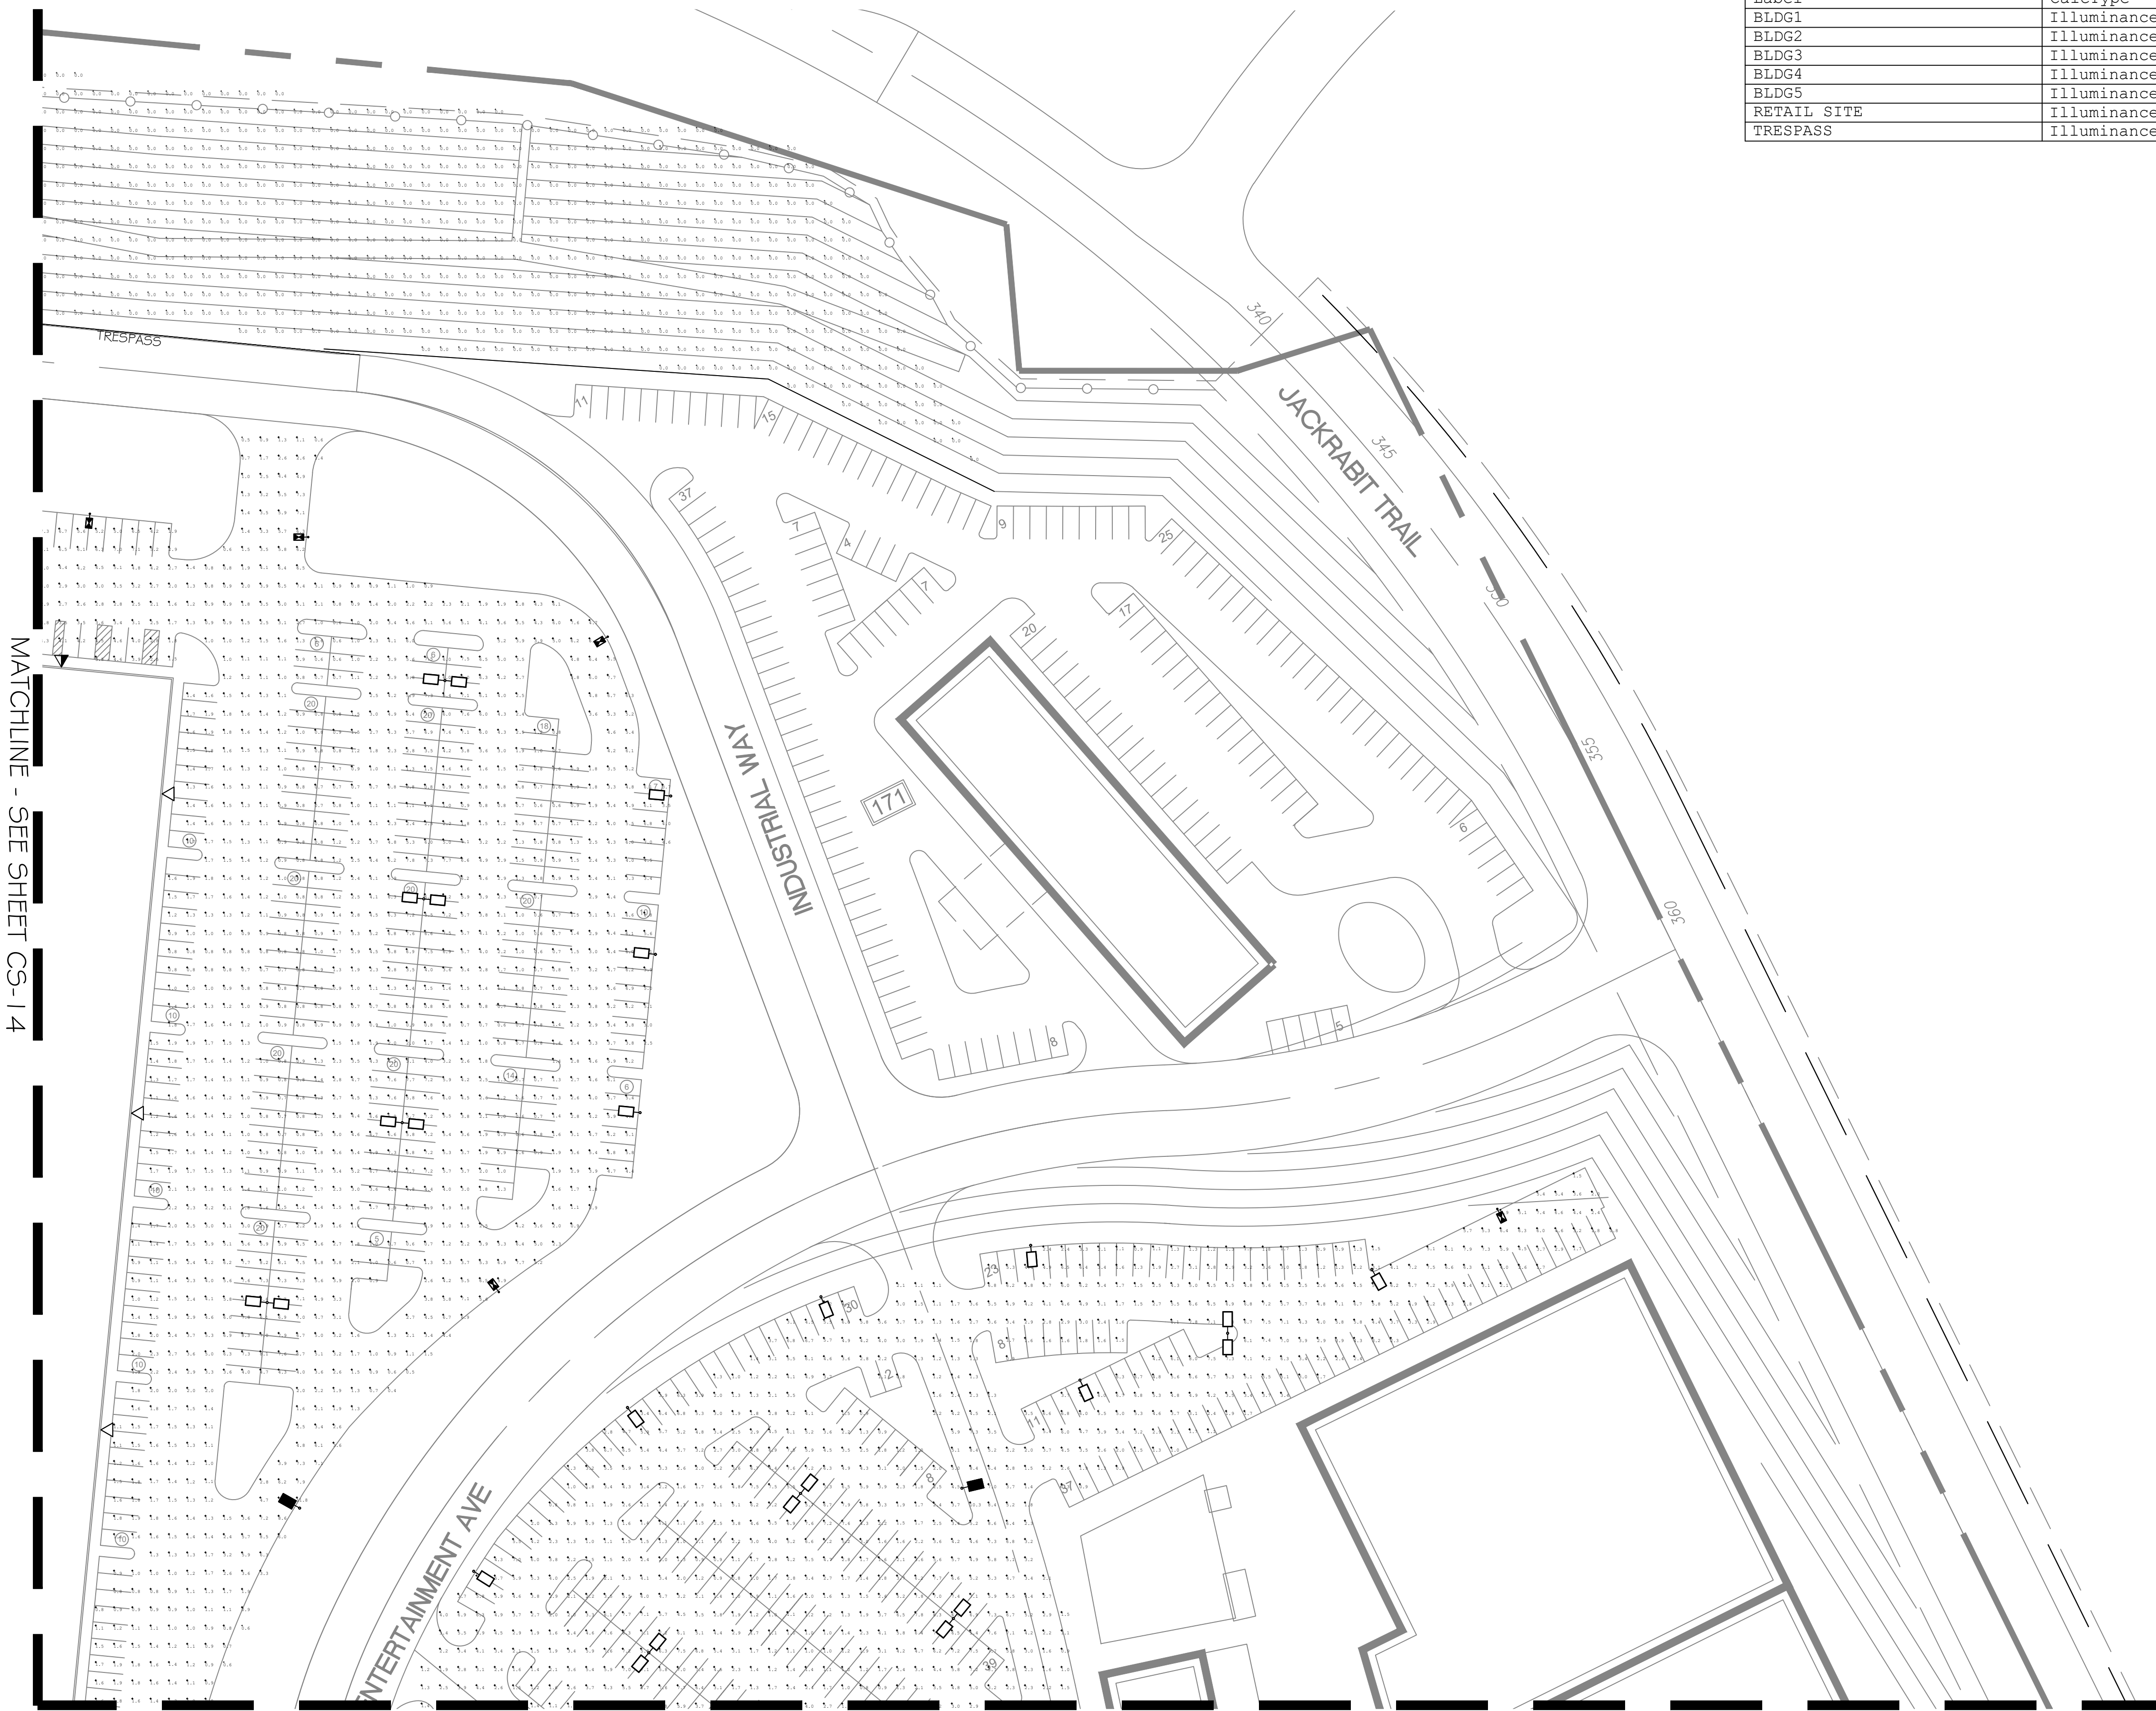


MATCHLINE - SEE SHEET CS-14

MATCHLINE - SEE SHEET CS-17

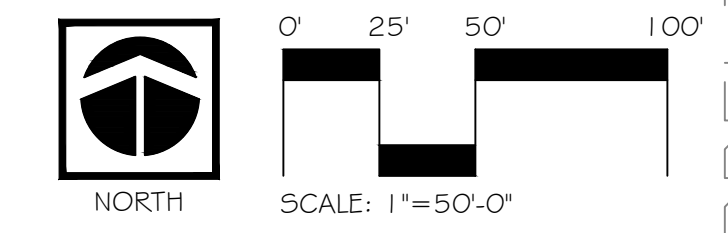

PRELIMINARY - NOT FOR CONSTRUCTION

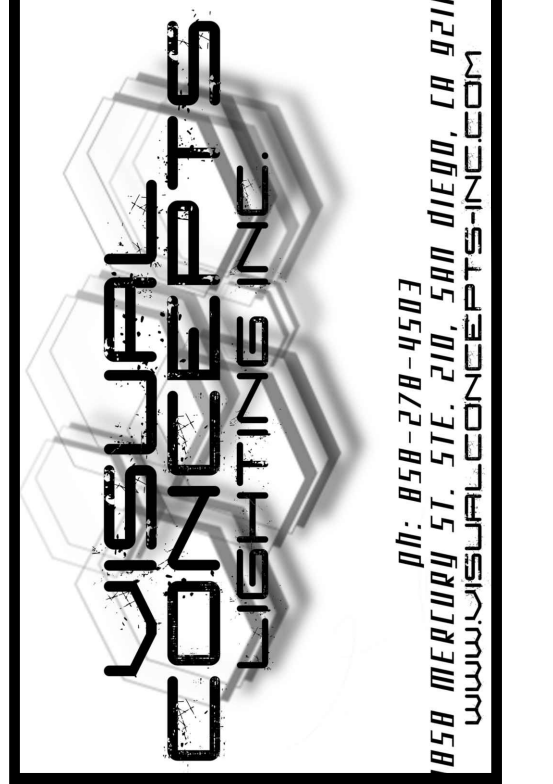

Project:  
BEAUMONT POINTE  
SITE LIGHTS  
BEAUMONT, CA.

Client:  
JRT PBI, LLC  
18032 LEMON DE. STE. 367  
YORBA LINDA, CA 92886



Revisions:


Sheet Info:  
Drawn By: AZ  
Checked By: KPJR  
Scale: 1"=50'-0"  
Date: 2/18/2021  
Job No.: JRT21/02011

Sheet Title:  
CONCEPTUAL  
PLAN

Sheet Reference:

CS-16  
Sheet: 16 of 19




MATCHLINE - SEE SHEET CS-16

MATCHLINE - SEE SHEET CS-15



Calculation Summary							
Label	CalcType	Units	Avg	Max	Min	Avg/Min	Max/Min
BLDG1	Illuminance	Fc	3.03	14.0	0.2	15.15	70.00
BLDG2	Illuminance	Fc	3.04	13.8	0.3	10.13	46.00
BLDG3	Illuminance	Fc	3.37	13.5	0.3	11.23	45.00
BLDG4	Illuminance	Fc	3.26	14.6	0.2	16.30	73.00
BLDG5	Illuminance	Fc	3.12	14.2	0.3	10.40	47.33
RETAIL SITE	Illuminance	Fc	3.64	12.2	0.7	5.20	17.43
TRESPASS	Illuminance	Fc	0.00	0.7	0.0	N.A.	N.A.

Luminaire Schedule									
Symbol	Qty	Tag	Label	Arrangement	Lum. Lumens	BUG Rating	LLF	Description	Wattage
☼	115	WALL LIGHT	HUBBELL - AIRO MICRO STRIKE	SINGLE	32152	B3-U0-G5	0.900	ASL2-320L-235-4K7-4W-U @ 39'	235
☼	115	WALL LIGHT	HUBBELL - AIRO MICRO STRIKE	SINGLE	32796	B3-U0-G4	0.900	ASL2-320L-235-4K7-2-U @ 39'	235
▽	30	WALL LIGHT	HUBBELL - AIRO MICRO STRIKE	SINGLE	23853	B3-U0-G4	0.900	ASL2-320L-170-4K7-4W-U @ 25'	168
▽	29	WALL LIGHT	HUBBELL - AIRO MICRO STRIKE	SINGLE	24139	B3-U0-G4	0.900	ASL2-320L-170-4K7-3-U @ 25'	168
▽	20	WALL LIGHT	HUBBELL - AIRO MICRO STRIKE	SINGLE	24330	B3-U0-G3	0.900	ASL2-320L-170-4K7-2-U @ 25'	168
☐	32	POLE LIGHT	HUBBELL - AIRO MICRO STRIKE	SINGLE	23853	B1-U0-G2	0.900	ASL2-320L-170-4K7-4W-BC @ 20'	168
☐	174	POLE LIGHT	HUBBELL - AIRO MICRO STRIKE	SINGLE	23853	B3-U0-G4	0.900	ASL2-320L-170-4K7-4W-U @ 20'	168
☐	8	POLE LIGHT	HUBBELL - AIRO MICRO STRIKE	SINGLE	24139	B1-U0-G2	0.900	ASL2-320L-170-4K7-3-BC @ 20'	168
☐	23	POLE LIGHT	HUBBELL - AIRO MICRO STRIKE	SINGLE	24139	B3-U0-G4	0.900	ASL2-320L-170-4K7-3-U @ 20'	168
☐	5	POLE LIGHT	HUBBELL - AIRO MICRO STRIKE	SINGLE	24330	B1-U0-G2	0.900	ASL2-320L-170-4K7-2-BC @ 20'	168
☐	28	POLE LIGHT	HUBBELL - AIRO MICRO STRIKE	SINGLE	24330	B3-U0-G3	0.900	ASL2-320L-170-4K7-2-U @ 20'	168
☐	3	POLE LIGHT DBL	HUBBELL - AIRO MICRO STRIKE	2 @ 90 DEGREES	23853	B3-U0-G4	0.900	ASL2-320L-170-4K7-4W-U @ 20'	168
☐	44	POLE LIGHT DBL	HUBBELL - AIRO MICRO STRIKE	BACK-BACK	23853	B3-U0-G4	0.900	ASL2-320L-170-4K7-4W-U @ 20'	168

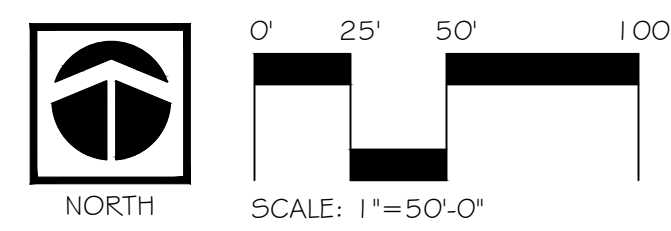


PRELIMINARY - NOT FOR CONSTRUCTION



Project:  
BEAUMONT POINTE  
SITE LIGHTS  
BEAUMONT, CA.

Client:  
JRT PBI, LLC  
18032 LEMON DE. STE. 367  
YORBA LINDA, CA 92886

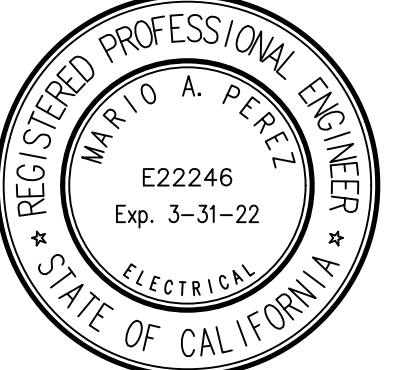

Revisions:


Sheet Info:  
Drawn By: AZ  
Checked By: KPJR  
Scale: 1"=50'-0"  
Date: 2/18/2021  
Job No.: JRT1/2021 I

Sheet Title:  
CONCEPTUAL  
PLAN 17

Sheet Reference:

CS-17

Sheet: 17 of 19



**AIRO Micro Strike**  
AREA/SITE/ROAD LIGHTER

DATE: \_\_\_\_\_ LOCATION: \_\_\_\_\_  
TYPE: \_\_\_\_\_ PROJECT: \_\_\_\_\_  
CATALOG #: \_\_\_\_\_

**ELECTRICAL DATA (CONT'D)**


Family	Nominal Wattage	Input Voltage (Volts)	Current (AMPS)	System Power (Watts)
AIRO (ASL2)	145	120	119	143.0
		208	0.69	
		240	0.60	
		277	0.52	
		347	0.41	
		480	0.30	
	170	120	140	168.0
		208	0.81	
		240	0.70	
		277	0.61	
		347	0.48	
		480	0.35	
185	120	154	185.0	
	208	0.89		
	240	0.77		
	277	0.67		
	347	0.53		
	480	0.39		
210	120	175	210.0	
	208	1.01		
	240	0.88		
	277	0.76		
	347	0.61		
	480	0.44		
235	120	196	235.0	
	208	1.13		
	240	0.98		
	277	0.85		
	347	0.68		
	480	0.49		
255	120	218	261.2	
	208	1.26		
	240	1.09		
	277	0.94		
	347	0.75		
	480	0.54		

**AIRO Micro Strike**  
AREA/SITE/ROAD LIGHTER


DATE: \_\_\_\_\_ LOCATION: \_\_\_\_\_  
TYPE: \_\_\_\_\_ PROJECT: \_\_\_\_\_  
CATALOG #: \_\_\_\_\_

**ADDITIONAL INFORMATION (CONT'D)**


**MOUNTING**

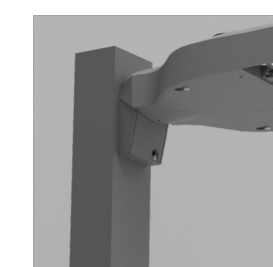

**Arm Mount** - Fixture ships with integral arm for ease of installation. Compatible with Hubbell Outdoor EC drill pattern.

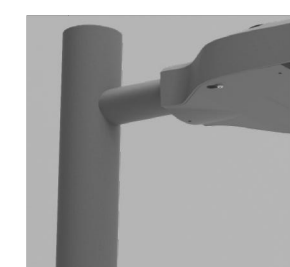


**MAF** - Fits 2-3/8" OD arms. Readyway applications.

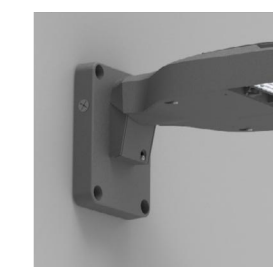


**Wall Mount** - Wall mount bracket designed for building mount applications.

**Universal Mount** - Universal mounting back for ease of installation. Compatible with drill patterns from 2.5" to 4.5"

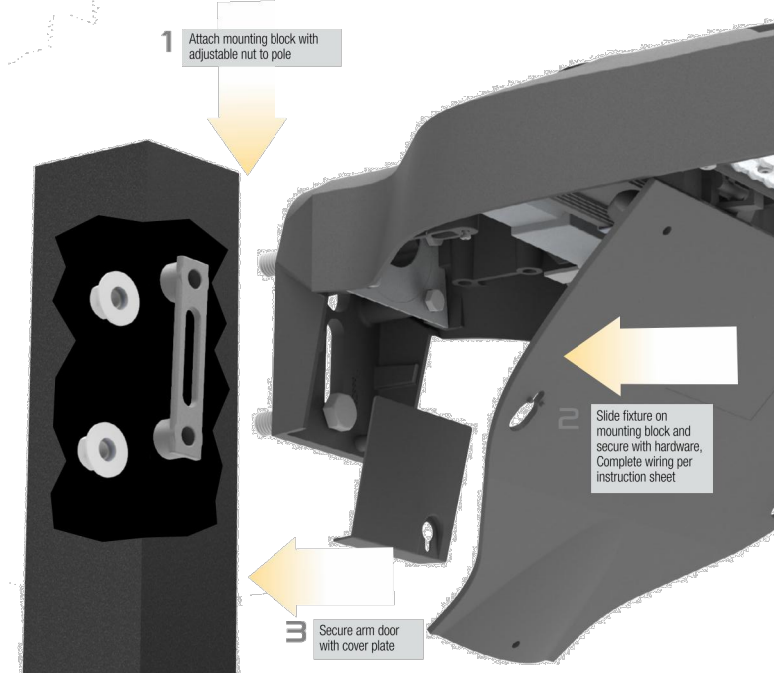

**ACCESSORY**

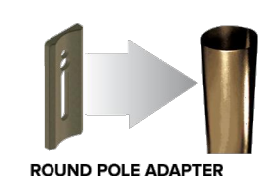

**ROUND POLE ADAPTER**



**WB-AREA-XX**



**SPOKE BRACKET** (single arm shown)

Horizontal round arm tenon adapters for use with MAF mounting type or accessory kit. Reference SH Spoke Pole Top Brackets for ordering information.

**AIRO Micro Strike**  
AREA/SITE/ROAD LIGHTER


DATE: \_\_\_\_\_ LOCATION: \_\_\_\_\_  
TYPE: \_\_\_\_\_ PROJECT: \_\_\_\_\_  
CATALOG #: \_\_\_\_\_

**PROJECTED LUMEN MAINTENANCE**

Ambient Temperature	OPERATING HOURS					
	0	25,000	TM-21-1H L96 60,000	50,000	100,000	L70 (Hours)
25°C / 77°F	1.00	0.97	0.96	0.95	0.91	408,000
40°C / 104°F	0.99	0.96	0.95	0.94	0.89	356,000


1. Projected per IESNA TM-21-11 (" Cree XPL, 2100mA, 105°C Tj, 6,000hrs)

**DIMENSIONS**

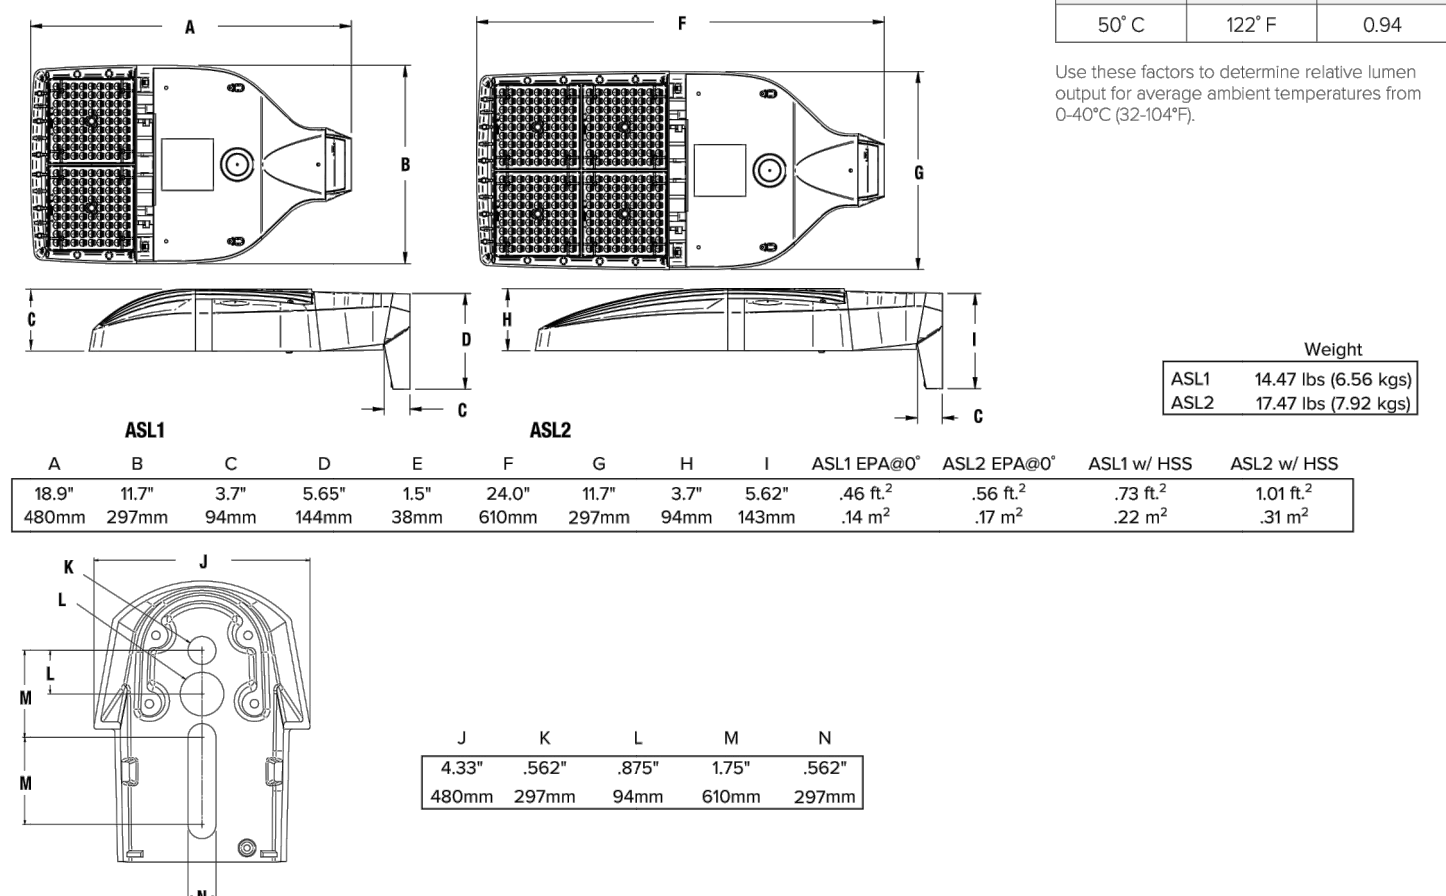

**PHOTOMETRY**

The following diagrams represent the general distribution options offered for this product. For detailed information on specific product configurations, see website photometric test reports.

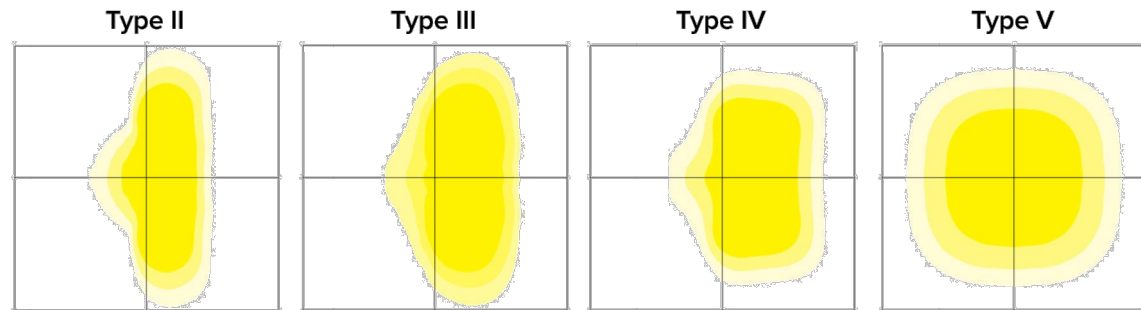

**AIRO Micro Strike**  
AREA/SITE/ROAD LIGHTER

DATE: \_\_\_\_\_ LOCATION: \_\_\_\_\_  
TYPE: \_\_\_\_\_ PROJECT: \_\_\_\_\_  
CATALOG #: \_\_\_\_\_

**ADDITIONAL INFORMATION (CONT'D)**


**OCCUPANCY SENSOR**

- Individual fixture control
- Dims product when space is not occupied



**7-PIN RECEPTACLE**

- Compatible with 3-pin, 5-pin or 7-pin photocells
- Lamps fixture on when sun sets, off when sun rises
- Wireless networked solution
- For use with a variety of control platforms
- Additional accessories required.

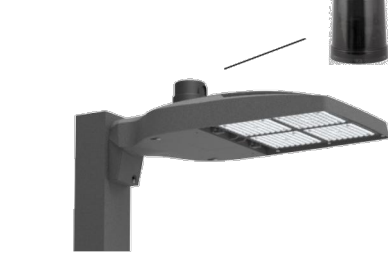

**NX**

**NX DISTRIBUTED INTELLIGENCE**

Hubbell Controls Solutions' NX Distributed Intelligence™ platform delivers a lighting control solution capable of seamlessly connecting exterior and interior applications.

- Standalone or networked fixture control
- Astronomical time scheduling
- BACnet building networking
- Connects with in-cord wired, wireless or hybrid networks
- Wireless setup via app
- Occupancy Sensor option dims product when space is not occupied



**SITESYNC LIGHTING CONTROL**



SiteSync Lighting Control delivers flexible control strategies for reducing power consumption and minimizing maintenance costs while delivering the right light levels with a simple and affordable wireless solution.

- Pre-commissioning options available
- Standalone or networked fixture control
- Astronomical time scheduling
- Occupancy Sensor option dims product when space is not occupied




**AIRO Micro Strike**  
AREA/SITE/ROAD LIGHTER

DATE: \_\_\_\_\_ LOCATION: \_\_\_\_\_  
TYPE: \_\_\_\_\_ PROJECT: \_\_\_\_\_  
CATALOG #: \_\_\_\_\_

**ADDITIONAL INFORMATION (CONT'D)**

**CONFIGURATIONS**

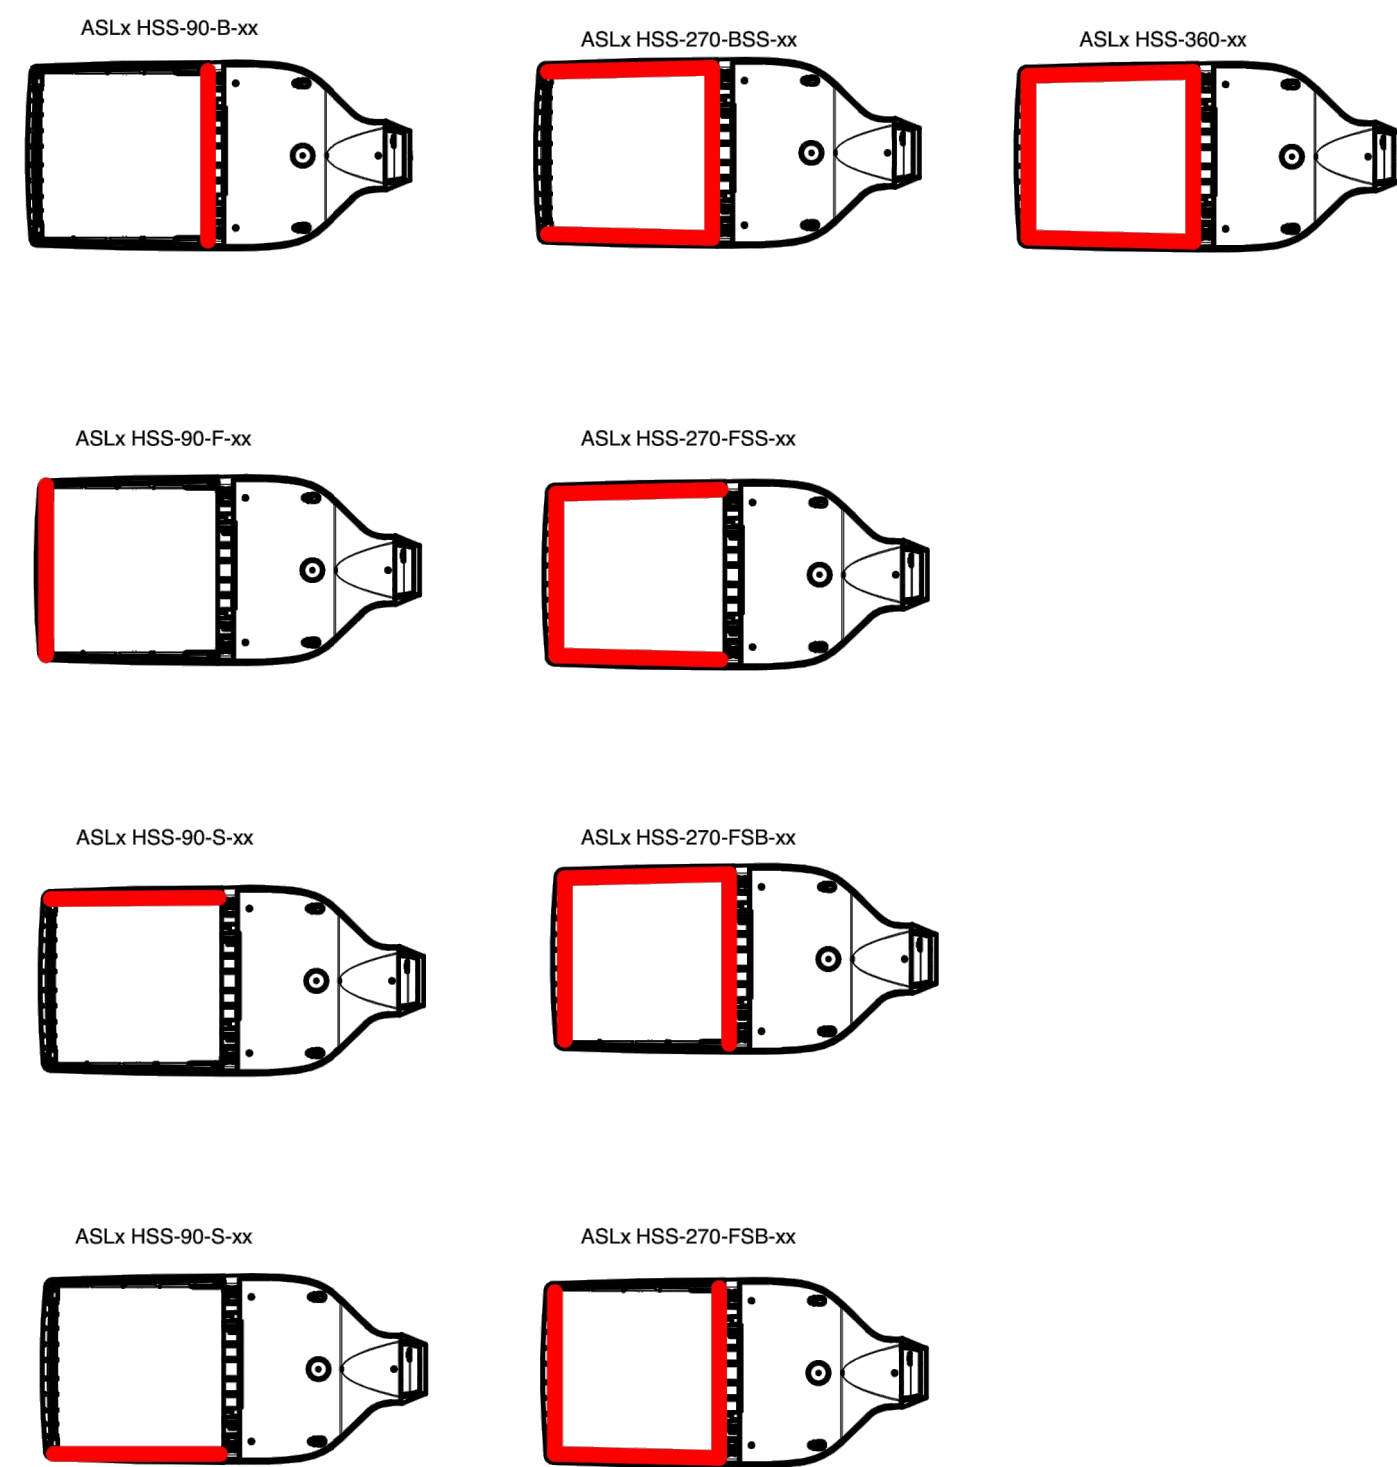

**USE OF TRADEMARKS AND TRADE NAMES MATCHLINE - SEE SHEET CS-2**

All product and company names, logos and product identifies are trademarks ™ or registered trademarks ® of Hubbell Lighting, Inc. or their respective owners. Use of them does not necessarily imply any affiliation with or endorsement by such respective owners.

PRELIMINARY - NOT FOR CONSTRUCTION



OFF: 858-278-4500  
1858 MERCURY ST., STE. 210, SAN MARINO, CA 91761  
WWW.VISUALCONCEPTSLIGHTING.COM

Project:  
BEAUMONT POINTE  
SITE LIGHTS  
BEAUMONT, CA.

Client:  
JRT PBI, LLC  
18032 LEMON DE. STE. 367  
YORBA LINDA, CA 92886



Revisions:


Sheet Info:  
Drawn By: AZ  
Checked By: KPJR  
Scale: N/A  
Date: 2/18/2021  
Job No.: JRT21/02011

Sheet Title:  
DETAILS  
PLAN

Sheet Reference:

CS-19

Sheet: 19 of 19