

# Appendix I Path of Travel Plans

## Appendix

*This page intentionally left blank.*

**GENERAL NOTES**

A. REFER TO ELECTRICAL AND SPECIALTY LIGHTING DRAWINGS FOR MORE INFORMATION.

**KEYNOTES**

202 (E) PITCHING MOUND. PROTECT IN PLACE  
 203 (E) DUGOUT. AVOID STRUCTURE, FOOTINGS, AND ZONE OF INFLUENCE  
 204 (E) BATTING CAGE. AVOID STRUCTURE, FOOTINGS, AND ZONE OF INFLUENCE  
 205 (E) BLEACHERS. AVOID STRUCTURE, FOOTINGS, AND ZONE OF INFLUENCE


ARCHITECTS  
**MOSHER  
 DREW**  
 DESIGN + PLANNING

1775 HANCOCK STREET SUITE 150  
 SAN DIEGO, CALIFORNIA 92110  
 TELEPHONE (619) 223-2400  
 FAX NO. (619) 223-3017

All ideas, designs, and arrangements indicated on these drawings are intended to be used in connection with this specific project only and shall not otherwise be used for any purpose whatsoever without the written consent of Architects Mosher Drew. There shall be no changes or deviations from these drawings or the accompanying specifications without the written consent of Architects Mosher Drew.

**PRELIMINARY  
 NOT FOR  
 CONSTRUCTION**

CONSULTANT LOGO

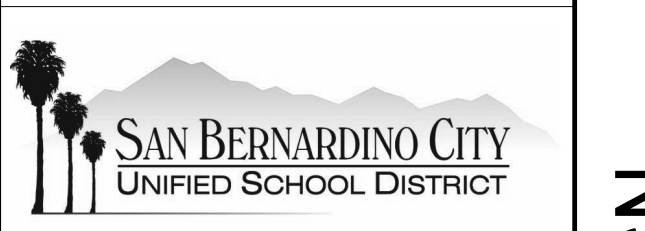

**SBCUSD SPORTS LIGHTING  
 ARROYO VALLEY HIGH SCHOOL**  
 1881 W BASE LINE ST  
 SAN BERNARDINO, CA 92411



**LEGEND**

LIMIT OF WORK  
 NEW LIGHT LOCATION  
 SOFTSCAPE TRENCHING LOCATION  
 HARDSCAPE TRENCHING LOCATION  
 EXISTING FENCE

Project Number : 21211.00  
 Date : 06/25/2020  
 Drawn By :  
 Checked By :  
 Revisions :

**ARROYO VALLEY HS  
 - SITE PLAN**

**A1.0**

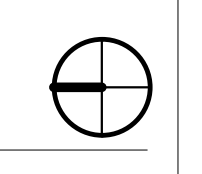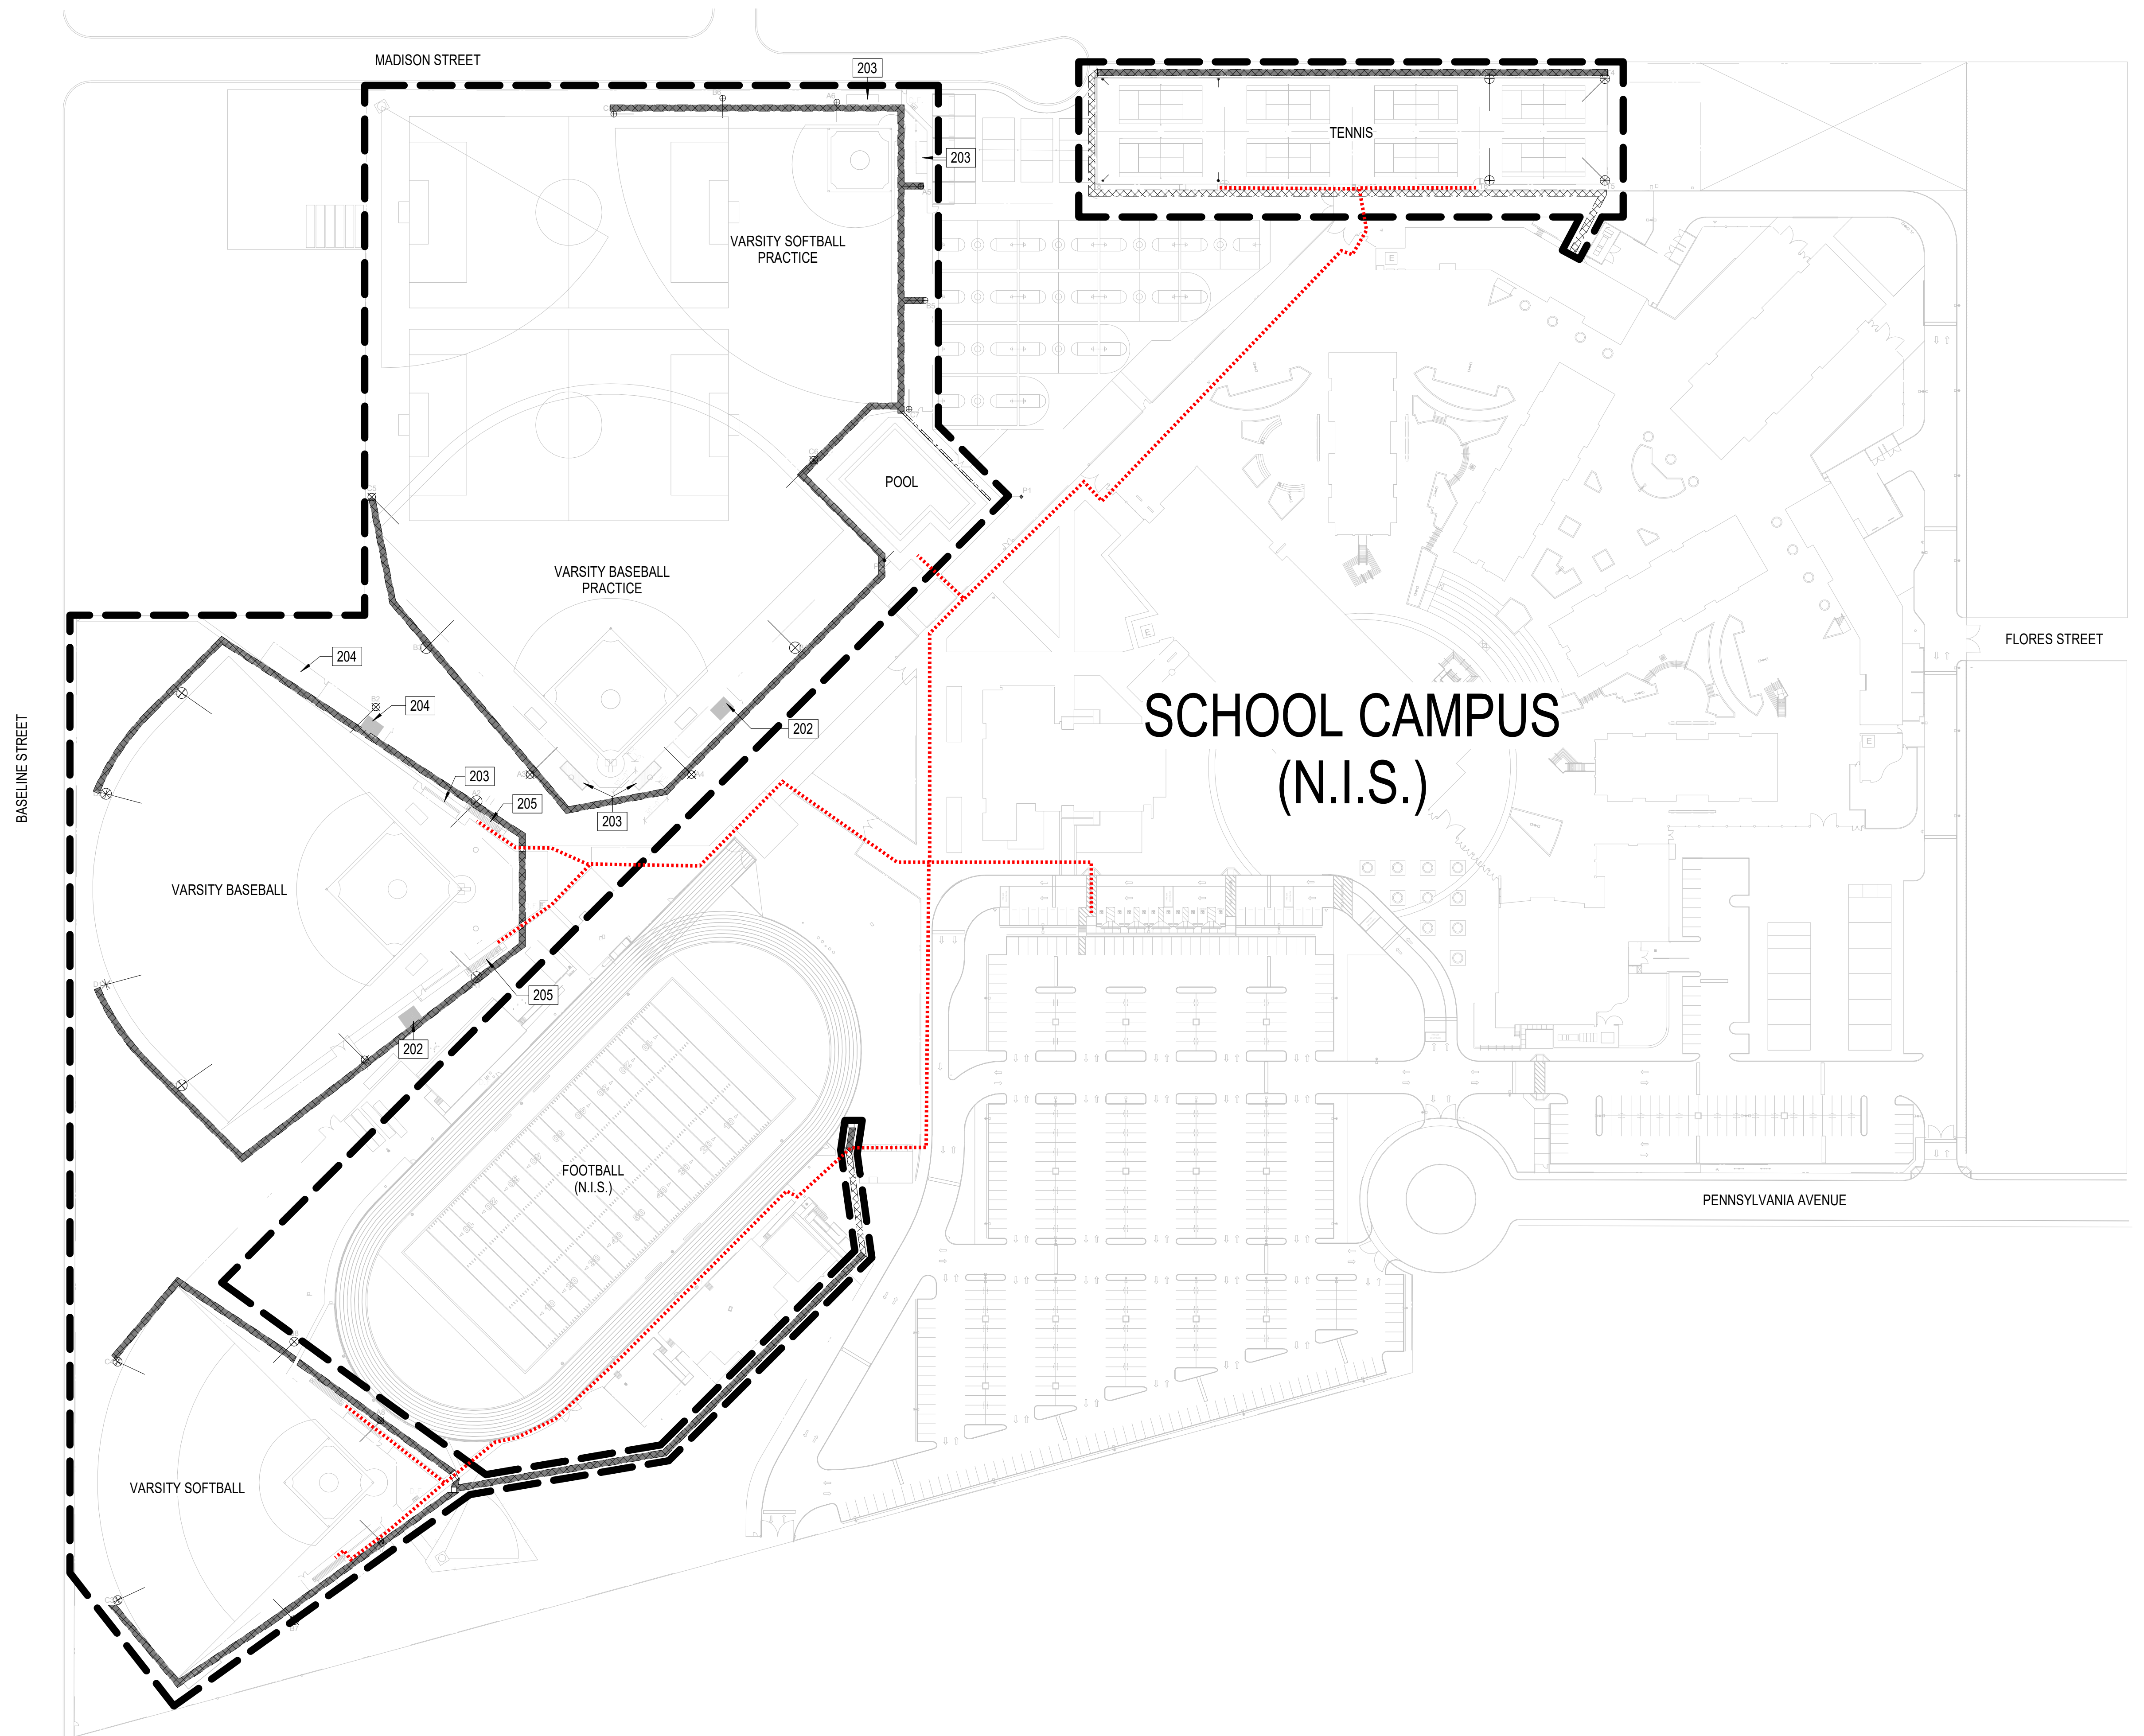

1 2 3 4 5

GENERAL NOTES

A. REFER TO ELECTRICAL AND SPECIALTY LIGHTING DRAWINGS FOR MORE INFORMATION.

KEYNOTES

- 202 (E) PITCHING MOUND, PROTECT IN PLACE
- 203 (E) DUGOUT, AVOID STRUCTURE, FOOTINGS, AND ZONE OF INFLUENCE
- 204 (E) BATTING CAGE, AVOID STRUCTURE, FOOTINGS, AND ZONE OF INFLUENCE
- 206 (E) STORAGE CONTAINER, PROTECT IN PLACE



1775 HANCOCK STREET SUITE 150  
SAN DIEGO, CALIFORNIA 92110  
TELEPHONE (619) 223-2400  
FAX NO. (619) 223-3017

All ideas, designs, and arrangements indicated on these drawings are intended to be used in connection with this specific project only and shall not otherwise be used for any purpose whatsoever without the written consent of Architects Mosher Mosher Drew. There shall be no changes or deviations from these drawings or the accompanying specifications without the written consent of Architects Mosher Mosher Drew.

PRELIMINARY  
NOT FOR  
CONSTRUCTION

ARCHITECT CONSULTANT STAMP

CONSULTANT LOGO



SBCUSD SPORTS LIGHTING  
CAJON HIGH SCHOOL  
1200 W HILL DR  
SAN BERNARDINO, CA 92407

Project Number : 21211.00  
Date : 06/25/2020  
Drawn By : Author  
Checked By : Checker  
Revisions :

CAJON HS - SITE PLAN

A1.0

SCHEMATIC DESIGN


A

B

C

D

E

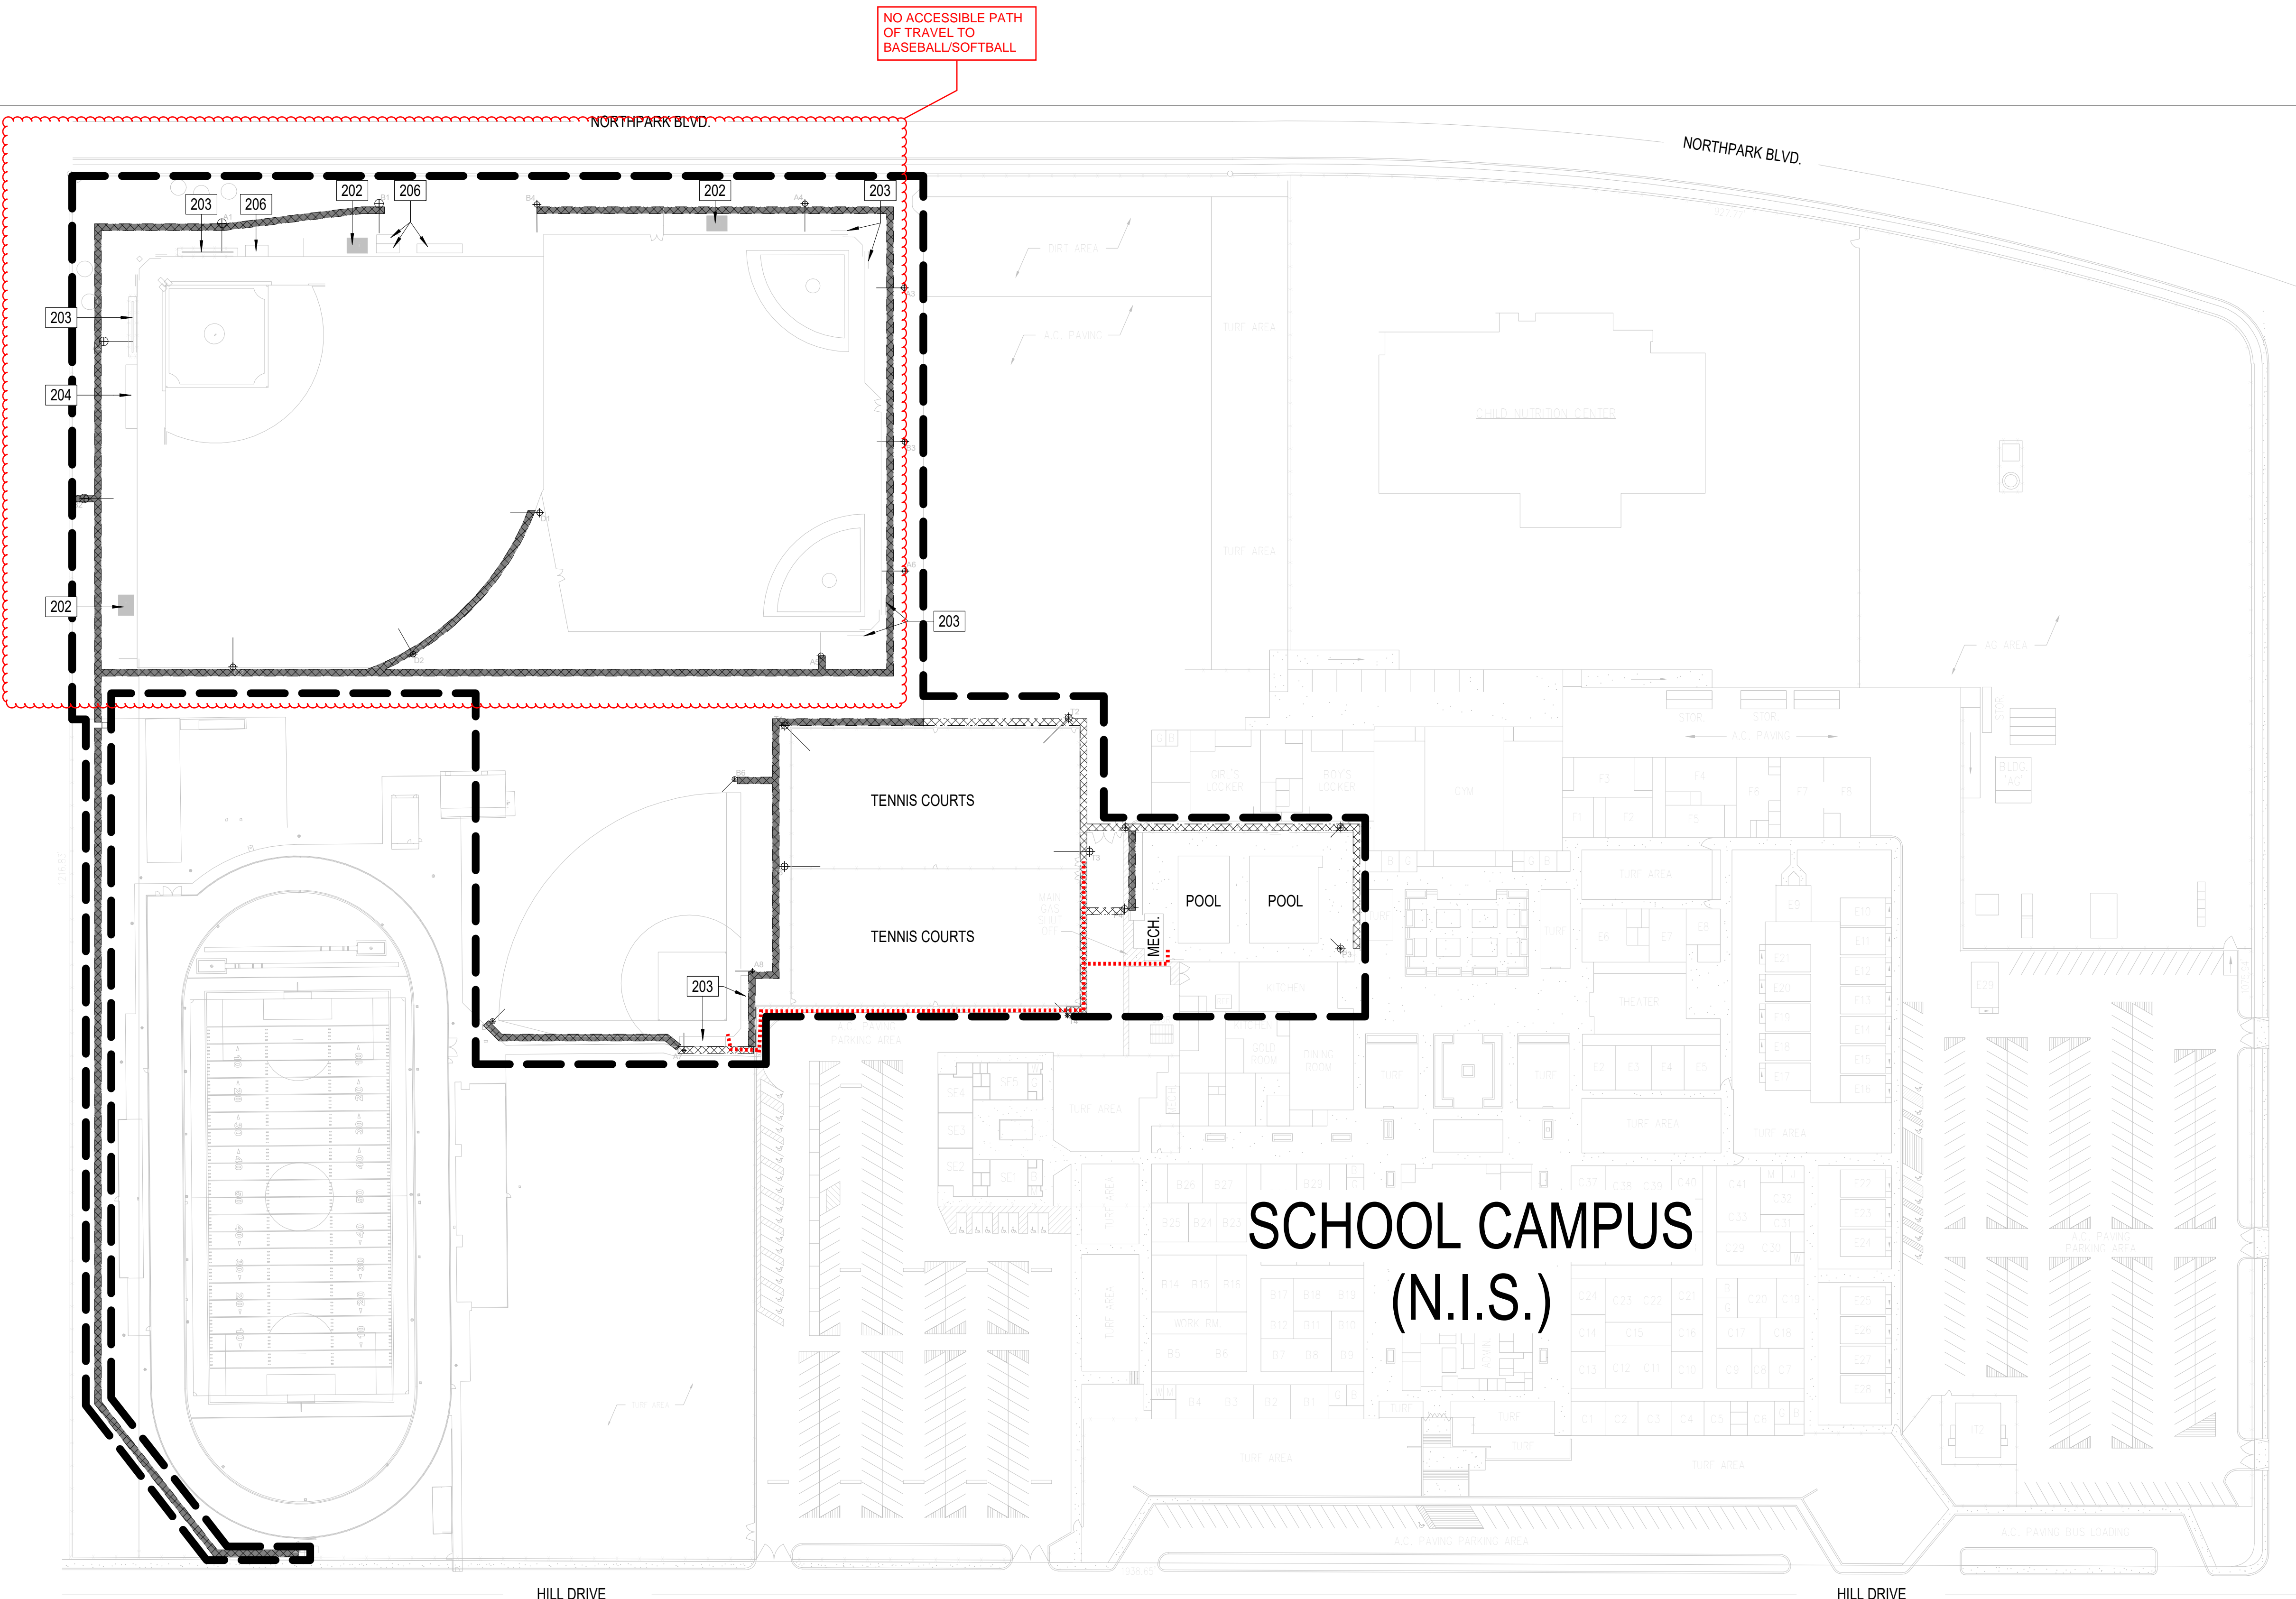

SCHOOL CAMPUS  
(N.I.S.)

- LEGEND
- [Dashed Box] LIMIT OF WORK
  - [Square with X] NEW LIGHT LOCATION
  - [Thick Dashed Line] SOFTSCAPE TRENCHING LOCATION
  - [Thin Dashed Line] HARDSCAPE TRENCHING LOCATION
  - [Line with X] EXISTING FENCE

1 2 3 4 5

6

1

2

3

4

5

6


A

B

C

D

E

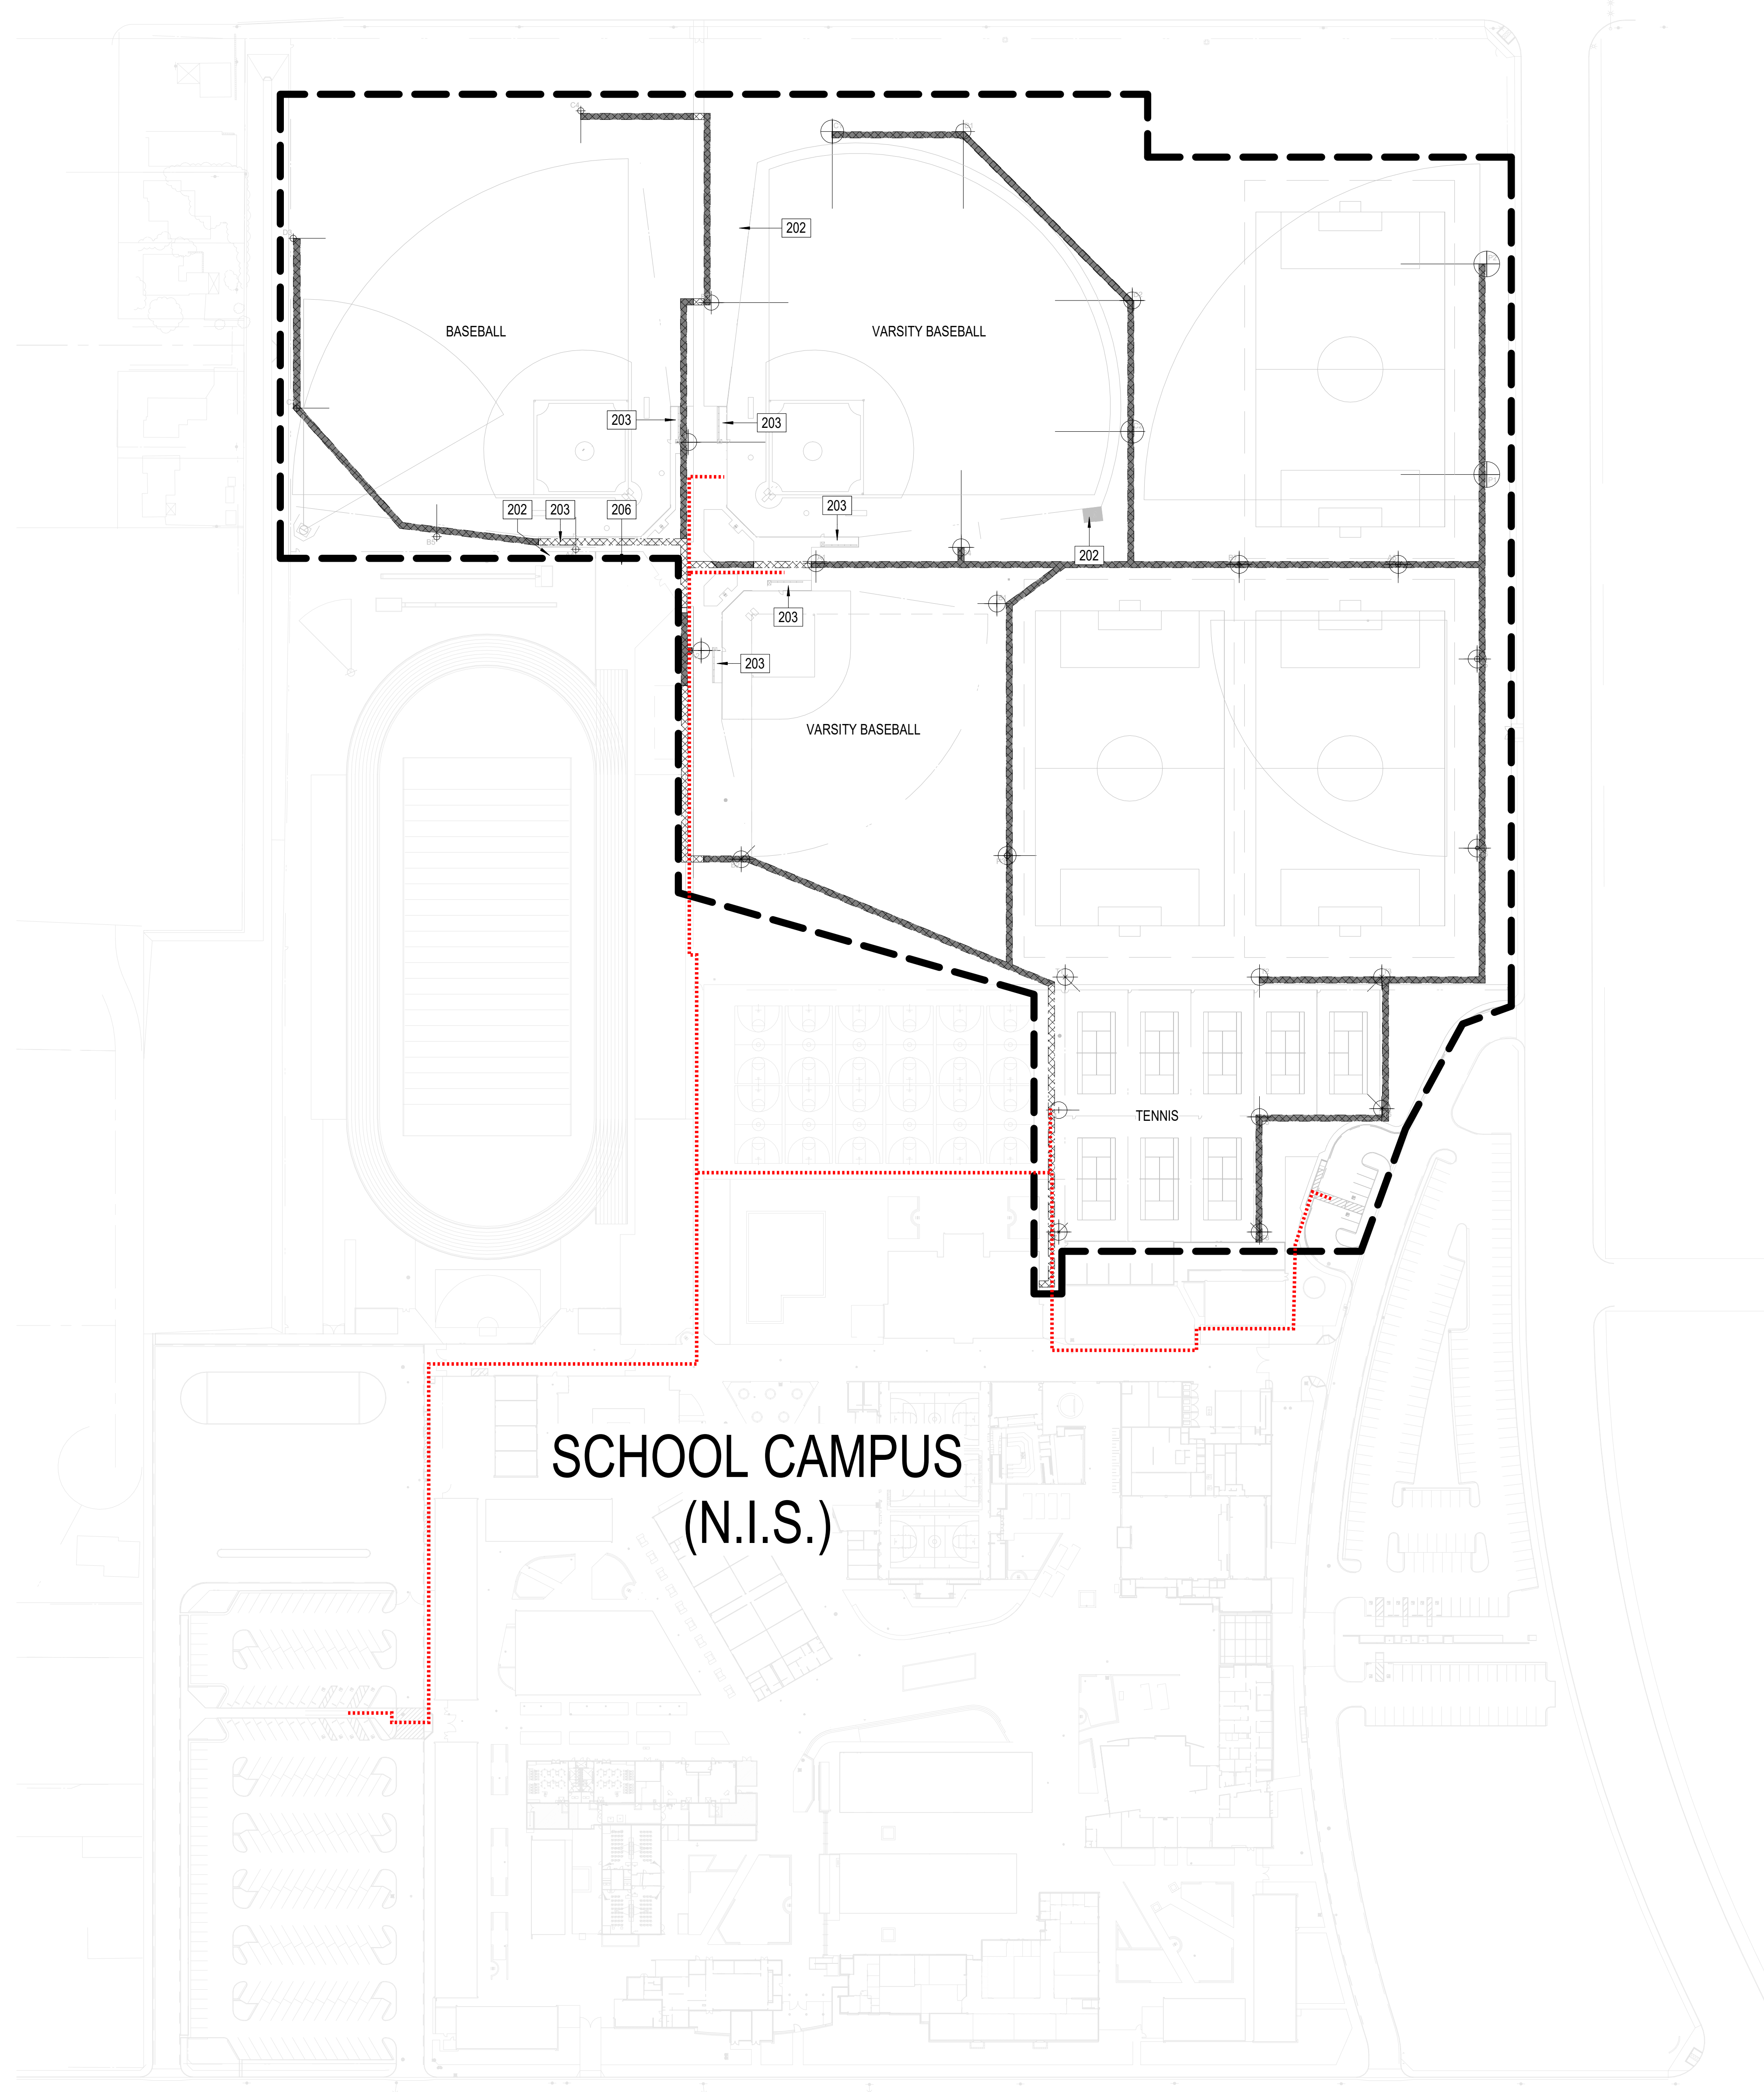

SCHOOL CAMPUS  
(N.I.S.)

<p><b>GENERAL NOTES</b></p> <p>A. REFER TO ELECTRICAL AND SPECIALTY LIGHTING DRAWINGS FOR MORE INFORMATION.</p>		<p>ARCHITECTS <b>MOSHER DREW</b> DESIGN + PLANNING</p> <p>1775 HANCOCK STREET SUITE 150 SAN DIEGO, CALIFORNIA 92110 TELEPHONE (619) 223-2400 FAX NO. (619) 223-3017</p> <p>All ideas, designs, and arrangements indicated on these drawings are intended to be used in connection with this specific project only and shall not otherwise be used for any purpose whatsoever without the written consent of Architects Mosher Drew. There shall be no changes or deviations from these drawings or the accompanying specifications without the written consent of Architects Mosher Drew.</p>	<p>DSB</p>
<p><b>KEYNOTES</b></p> <p>202 (E) PITCHING MOUND. PROTECT IN PLACE 203 (E) DUGOUT. AVOID STRUCTURE, FOOTINGS, AND ZONE OF INFLUENCE 206 (E) STORAGE CONTAINER. PROTECT IN PLACE</p>			
<p><b>LEGEND</b></p> <p> LIMIT OF WORK  NEW LIGHT LOCATION  SOFTSCAPE TRENCHING LOCATION  HARDSCAPE TRENCHING LOCATION  EXISTING FENCE</p>		<p><b>PRELIMINARY NOT FOR CONSTRUCTION</b></p> <p>ARCHITECT CONSULTANT STAMP</p>	<p>CONSULTANT LOGO</p> <p></p>
<p><b>SBCUSD SPORTS LIGHTING INDIAN SPRINGS HIGH SCHOOL 650 N DEL ROSA DR SAN BERNARDINO, CA 92410</b></p>		<p>Project Number : 21211.00 Date : 06/25/2020 Drawn By : Author Checked By : Checker Revisions :</p>	<p><b>INDIAN SPRINGS HS - SITE PLAN</b></p>
<p><b>A1.0</b></p>			



**GENERAL NOTES**  
 A. REFER TO ELECTRICAL AND SPECIALTY LIGHTING DRAWINGS FOR MORE INFORMATION.


**KEYNOTES**  
 201 (E) PLANTER, PROTECT IN PLACE  
 203 (E) DUGOUT, AVOID STRUCTURE, FOOTINGS, AND ZONE OF INFLUENCE  
 206 (E) STORAGE CONTAINER, PROTECT IN PLACE

**ARCHITECTS**  
**MOSHER**  
**DREW**  
DESIGN + PLANNING

1775 HANCOCK STREET SUITE 150  
 SAN DIEGO, CALIFORNIA 92110  
 TELEPHONE (619) 223-2400  
 FAX NO. (619) 223-3017

All ideas, designs, and arrangements indicated on these drawings are intended to be used in connection with this specific project only and shall not otherwise be used for any purpose whatsoever without the written consent of Architects Mosher Drew. There shall be no changes or deviations from these drawings or the accompanying specifications without the written consent of Architects Mosher Drew.

**PRELIMINARY**  
**NOT FOR**  
**CONSTRUCTION**

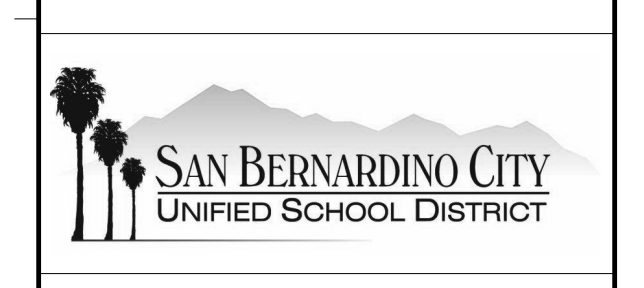

**GENERAL**

- LIMIT OF WORK
- NEW LIGHT LOCATION
- SOFTSCAPE TRENCHING LOCATION
- HARDSCAPE TRENCHING LOCATION
- EXISTING FENCE

**SBCUSD SPORTS LIGHTING**  
**PACIFIC HIGH SCHOOL**  
 1020 PACIFIC ST  
 SAN BERNARDINO, CA 92404

Project Number	: 21211.00
Date	: 06/25/2020
Drawn By	: Author
Checked By	: Checker
Revisions	:

**PACIFIC HS - SITE PLAN**

**A1.0**

1

2

3

4

5

6

A

B

C

D

E

### GENERAL NOTES

A. REFER TO ELECTRICAL AND SPECIALTY LIGHTING DRAWINGS FOR MORE INFORMATION.

### KEYNOTES

- 202 (E) PITCHING MOUND, PROTECT IN PLACE
- 203 (E) DUGOUT, AVOID STRUCTURE, FOOTINGS, AND ZONE OF INFLUENCE
- 204 (E) BATTING CAGE, AVOID STRUCTURE, FOOTINGS, AND ZONE OF INFLUENCE

DCA

**ARCHITECTS**  
**MOSHER**  
**DREW**

DESIGN • PLANNING

1775 HANCOCK STREET SUITE 150  
SAN DIEGO, CALIFORNIA 92110  
TELEPHONE (619) 223-2400  
FAX NO. (619) 223-3017

All ideas, designs, and arrangements indicated on these drawings are intended to be used in connection with this specific project only and shall not otherwise be used for any purpose whatsoever without the written consent of Architects Mosher Drew. There shall be no changes or deviations from these drawings or the accompanying specifications without the written consent of Architects Mosher Drew.

**PRELIMINARY  
NOT FOR  
CONSTRUCTION**

ARCHITECT CONSULTANT STAMP

CONSULTANT LOGO




**SBCUSD SPORTS LIGHTING**  
**SAN BERNARDINO HIGH SCHOOL**  
1850 N E ST  
SAN BERNARDINO, CA 92405

Project Number	: 21211.00
Date	: 06/25/2020
Drawn By	: Author
Checked By	: Checker
Revisions	:


**SAN BERNARDINO  
HS - SITE PLAN**

**A1.0**

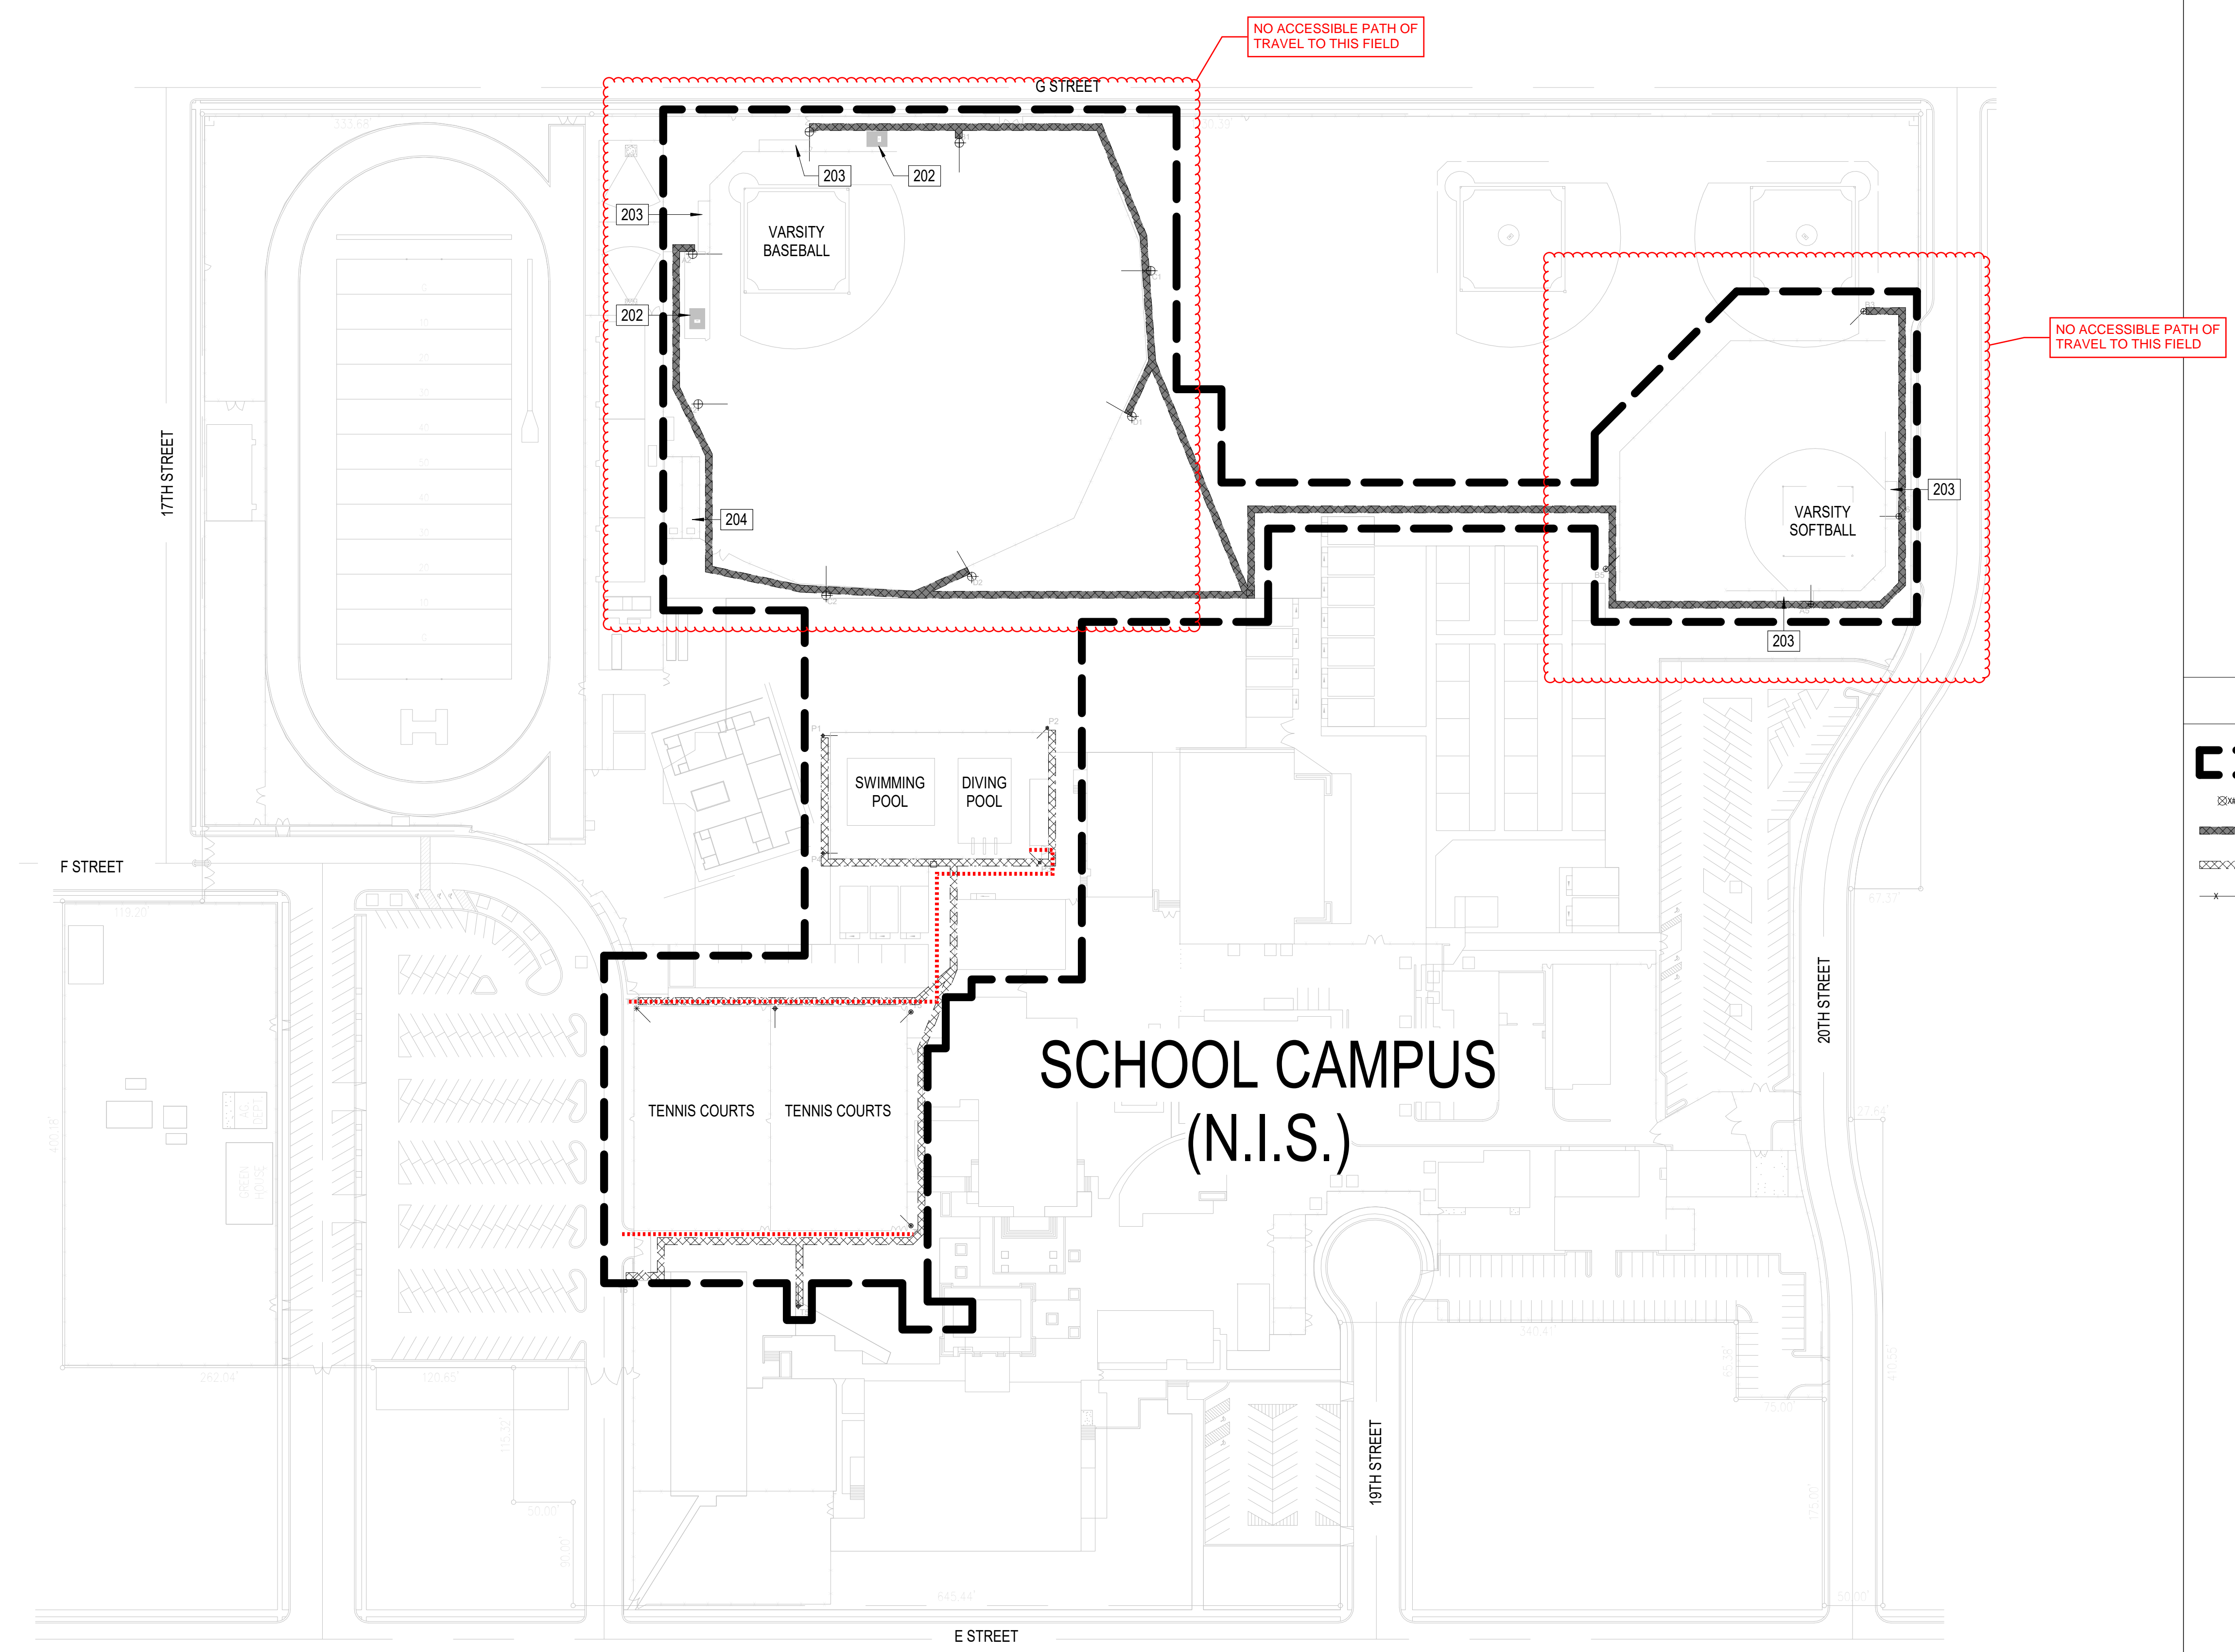

### LEGEND

- LIMIT OF WORK
- NEW LIGHT LOCATION
- SOFTSCAPE TRENCHING LOCATION
- HARDSCAPE TRENCHING LOCATION
- EXISTING FENCE

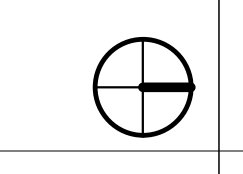

SCHEMATIC DESIGN

1

2

3

4

5

6

A

B

C

D

E

**GENERAL NOTES**

A. REFER TO ELECTRICAL AND SPECIALTY LIGHTING DRAWINGS FOR MORE INFORMATION.

**KEYNOTES**

203 (E) DUGOUT. AVOID STRUCTURE, FOOTINGS, AND ZONE OF INFLUENCE  
 205 (E) BLEACHERS. AVOID STRUCTURE, FOOTINGS, AND ZONE OF INFLUENCE  
 206 (E) STORAGE CONTAINER. PROTECT IN PLACE

**LEGEND**

- LIMIT OF WORK
- NEW LIGHT LOCATION
- SOFTSCAPE TRENCHING LOCATION
- HARDSCAPE TRENCHING LOCATION
- EXISTING FENCE

DCA

**ARCHITECTS**  
**MOSHER**  
**DREW**

DESIGN + PLANNING


1775 HANCOCK STREET SUITE 150  
 SAN DIEGO, CALIFORNIA 92110  
 TELEPHONE (619) 223-2400  
 FAX NO. (619) 223-3017

All ideas, designs, and arrangements indicated on these drawings are intended to be used in connection with this specific project only and shall not otherwise be used for any purpose whatsoever without the written consent of Architects Mosher Drew. There shall be no changes or deviations from these drawings or the accompanying specifications without the written consent of Architects Mosher Drew.

**PRELIMINARY**  
**NOT FOR**  
**CONSTRUCTION**

ARCHITECT CONSULTANT STAMP

CONSULTANT LOGO

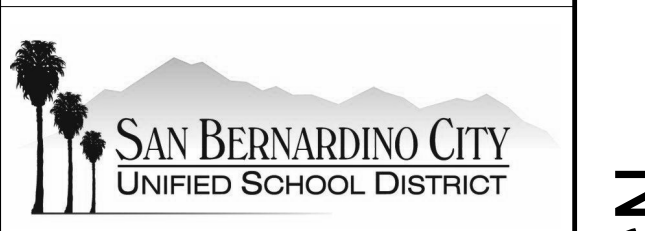


**SBCUSD SPORTS LIGHTING**  
**SAN GORGONIO HIGH SCHOOL**  
2299 PACIFIC ST  
SAN BERNARDINO, CA 92404

Project Number : 21211.00  
 Date : 06/25/2020  
 Drawn By : Author  
 Checked By : Checker  
 Revisions :

▲  
 ▲  
 ▲

**SAN GORGONIO HS -**  
**SITE PLAN**

**A1.0**

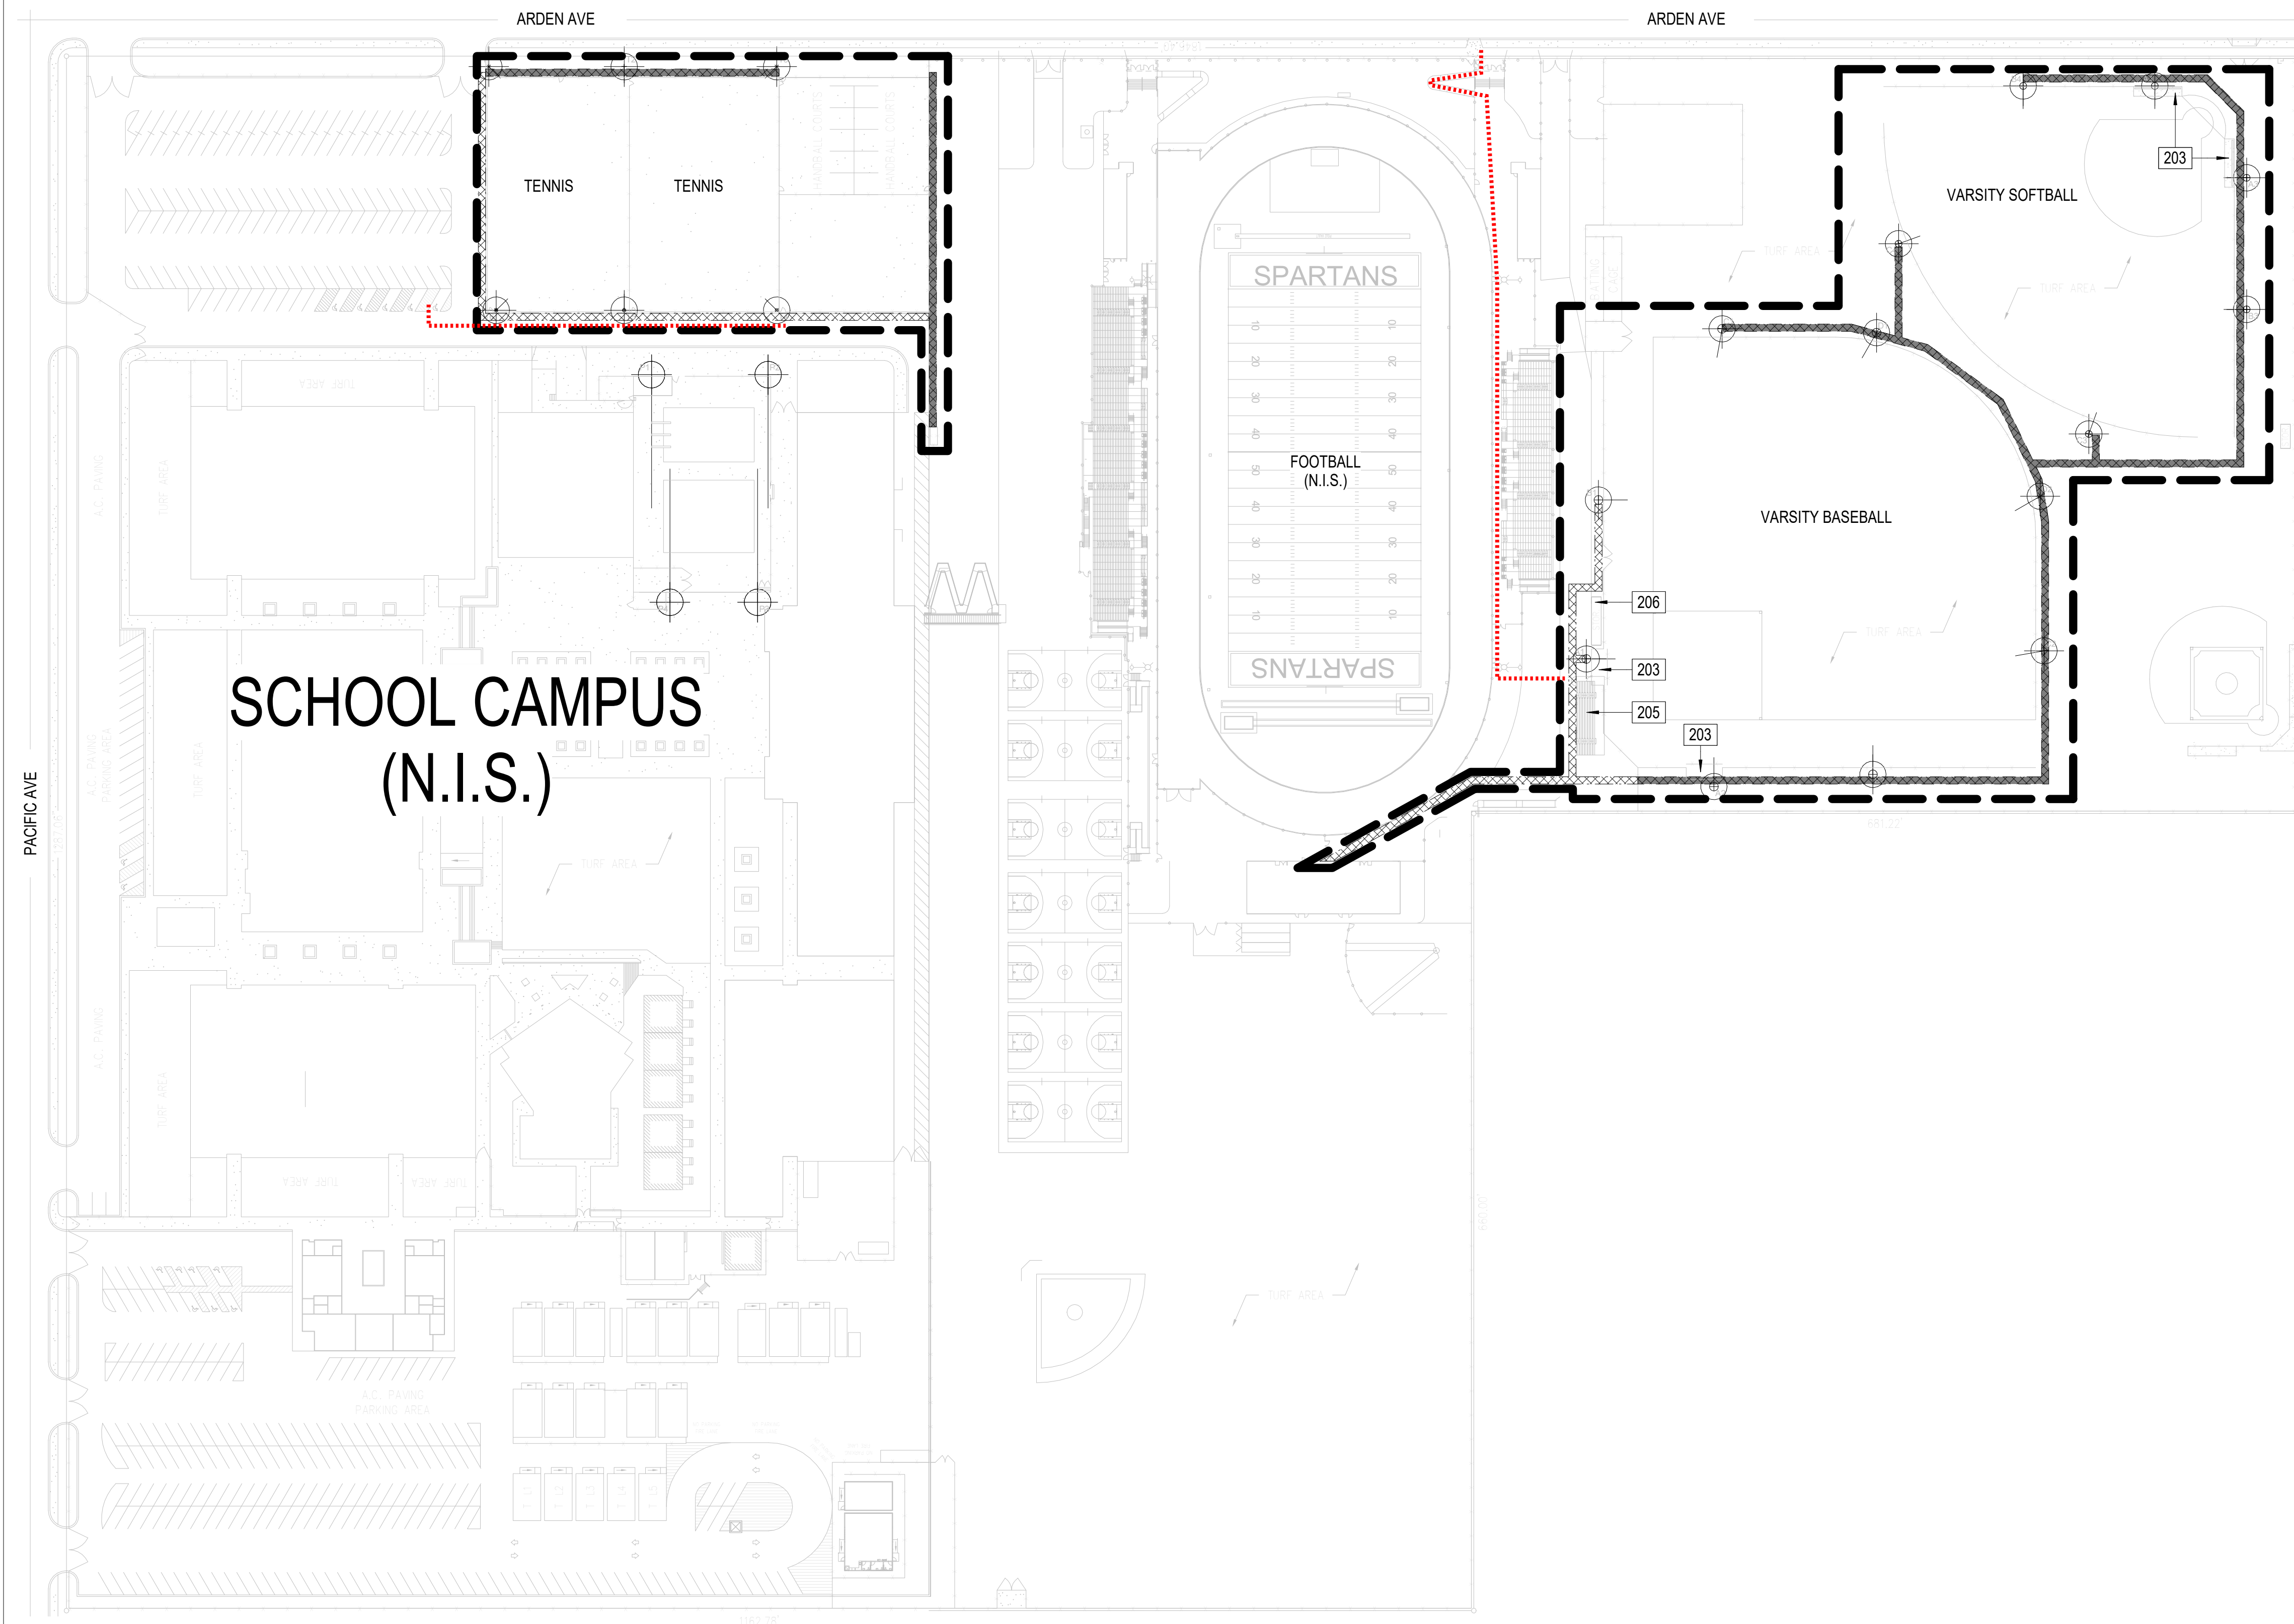

**E2 SAN GORGONIO HS - SITE PLAN**  
 6 A1.0 1" = 80'-0"

**SCHEMATIC DESIGN**